



CAN YOU SEE THE AIRPLANES? THE ADJACENT SAMPLES SHOW THREE DIFFERENT LEVELS OF SHADING. SETTINGS FOR VIEWING AND PRINTING DRAWING CONTENT ARE OPTIMIZED WHEN ALL THREE PLANES ARE VISIBLE. THIS GUIDANCE IS PROVIDED FOR REFERENCE ONLY.

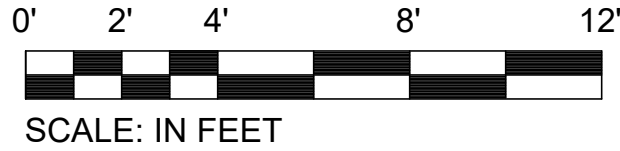

SCALE: IN FEET

| PLUMBING FIXTURE COUNT TOTAL |                                     |                                 |
|------------------------------|-------------------------------------|---------------------------------|
| FIXTURE TYPE                 | EXISTING                            | NEW TOTAL PROVIDED              |
| WC                           | 5 URINALS MEN, 5 WC MEN, 9 WC WOMEN | 5 URINALS, 5 WC MEN, 9 WC WOMEN |
| LAV                          | 7 MEN, 8 WOMEN                      | 7 MEN, 6 WOMEN                  |
| DF                           | 2                                   | 2                               |

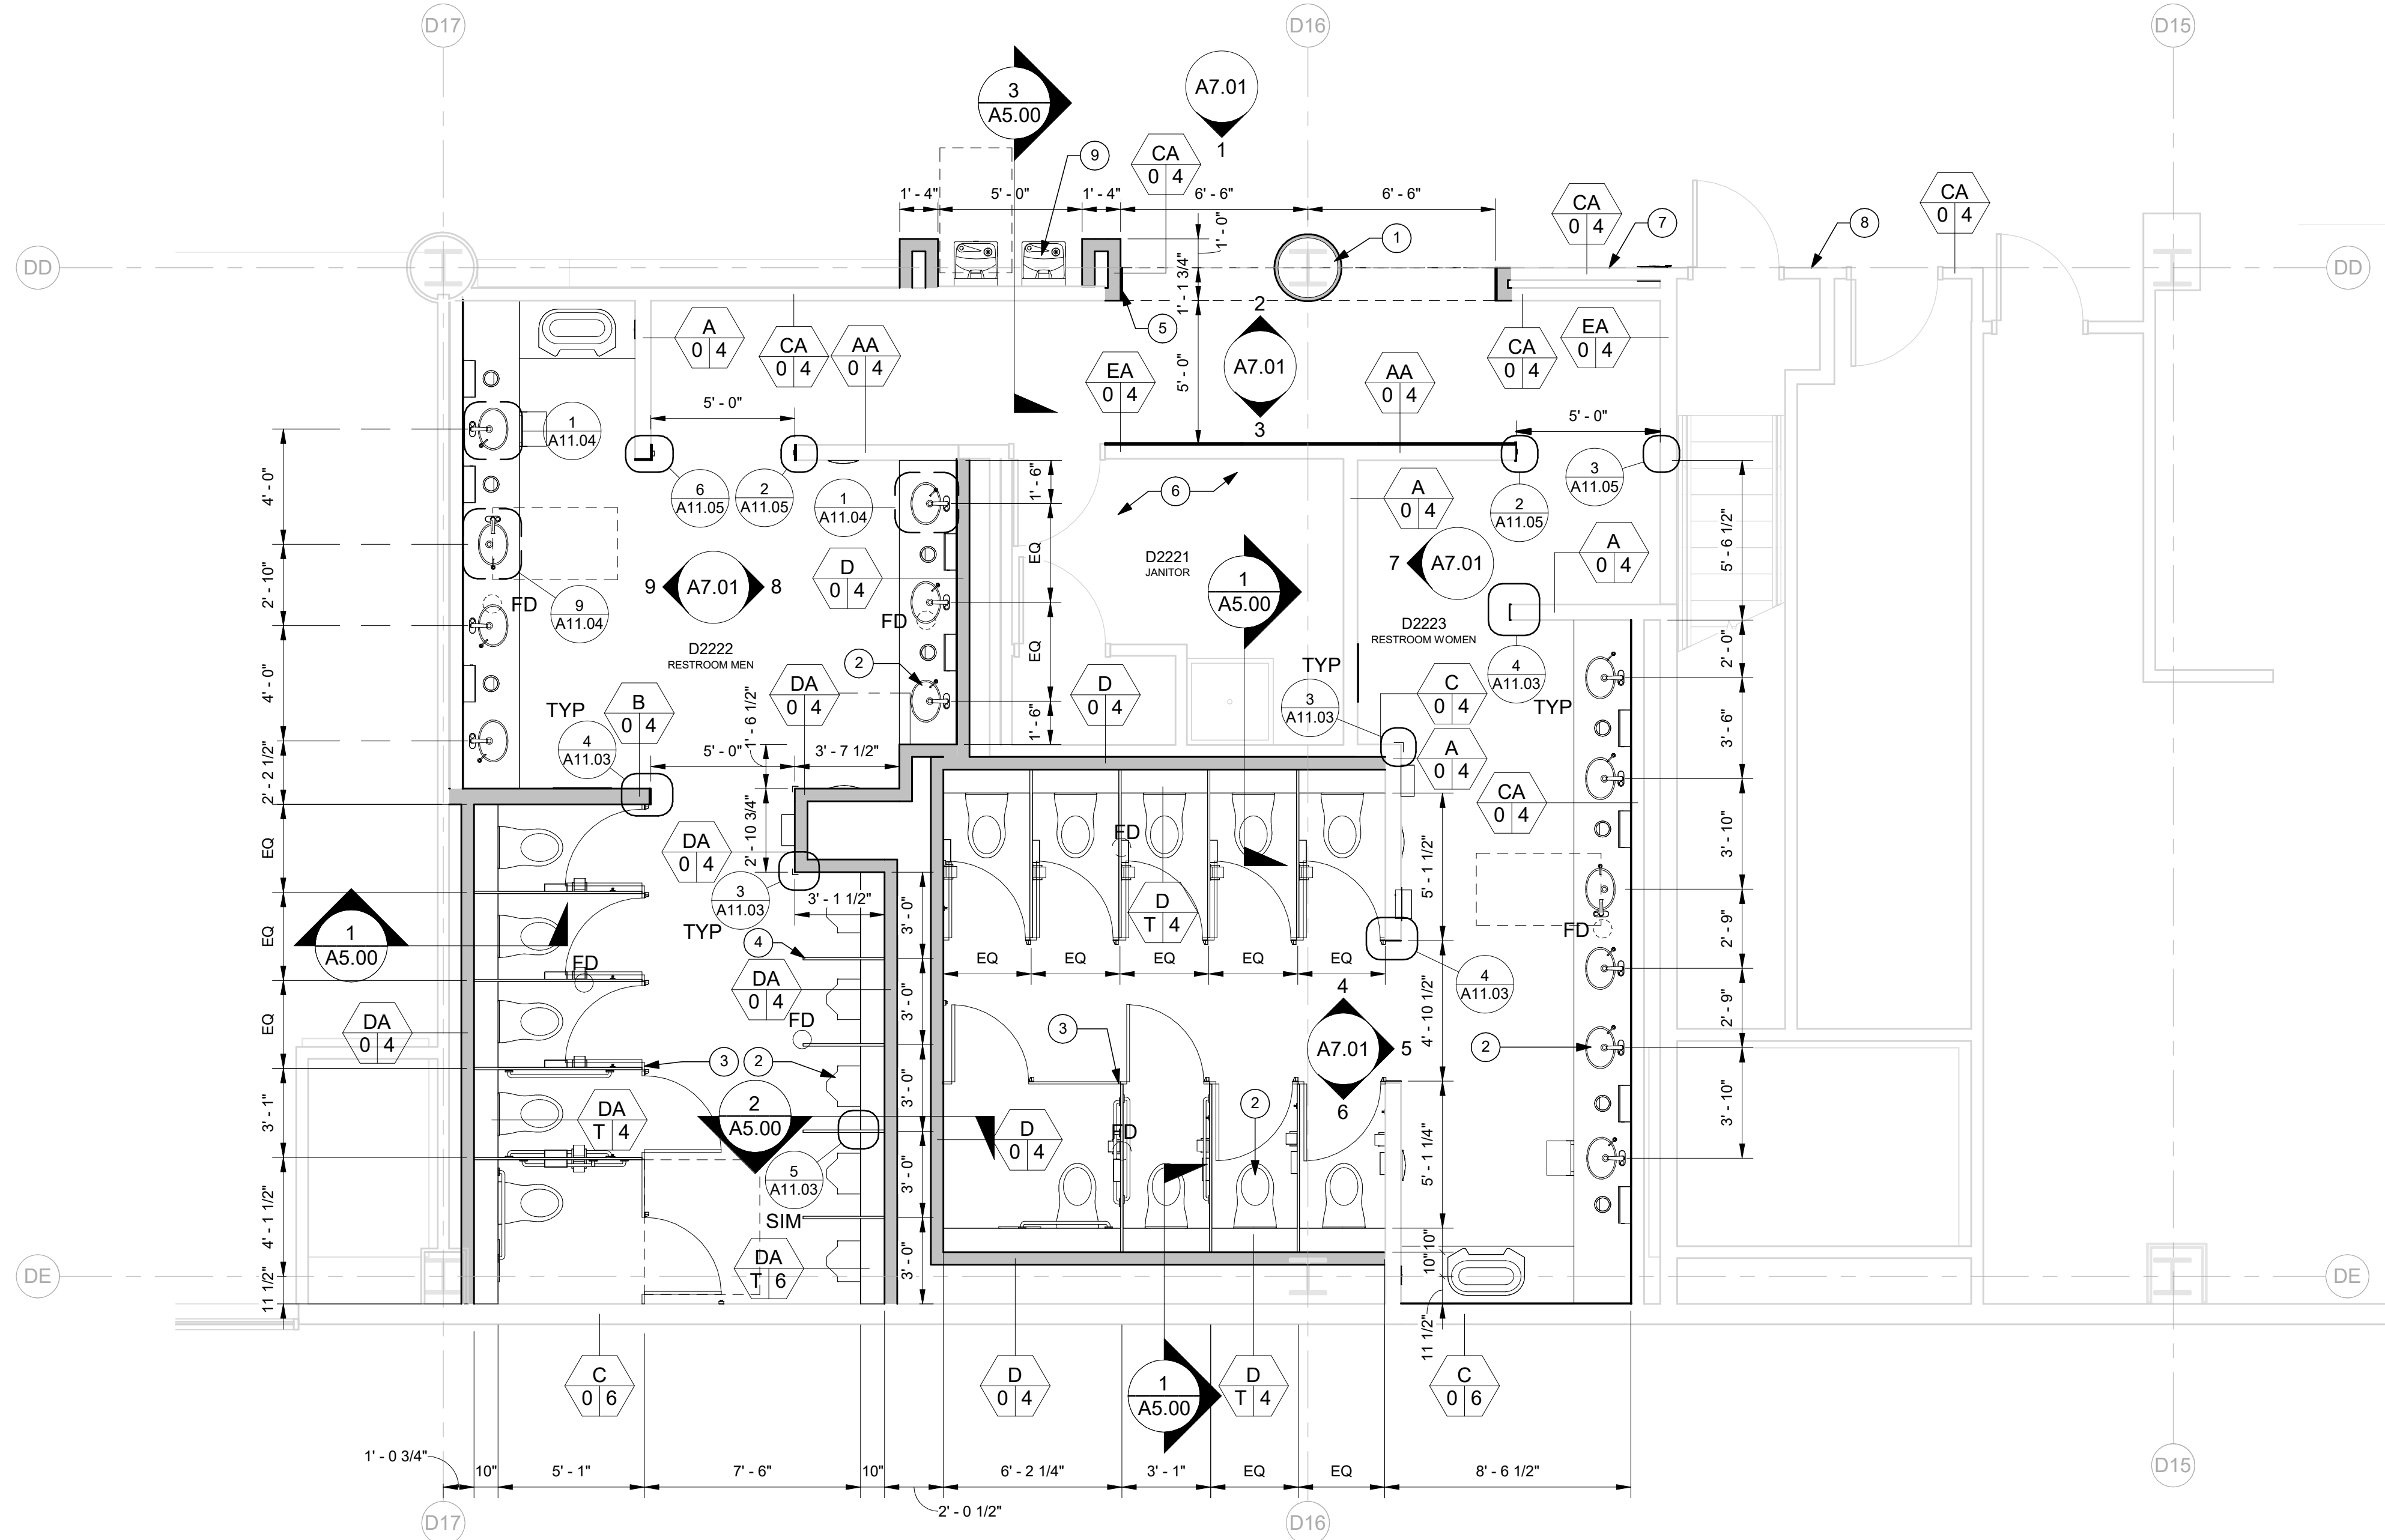

1 CONCURSE D - SECTOR 2 - D2221, D2222, D2223 - ENPLANING - FLOOR PLAN  
SCALE: 1/4" = 1'-0"

#### NOTES

- DIMENSIONS ARE TO FACE OF FINISH AND CENTERLINE OF GRID LINES. THEY ARE FOR REFERENCE ONLY AND SHOULD BE FIELD VERIFIED BY CONTRACTOR FOR ACCURACY.
- CONTRACTOR SHALL MAINTAIN FIRE RATED ASSEMBLIES AS REQUIRED.
- CONTRACTOR SHALL PROTECT ALL (E) ADJACENT SURFACES AND FINISHES NOT RECEIVING WORK. ADJACENT FINISHES SHALL BE RESTORED TO PRE-CONSTRUCTION CONDITION.
- CONTRACTOR TO COORDINATE ALL BACKING FOR WALL MOUNTED ACCESSORIES AS NEEDED. REFERENCE SHEET A11.01 FOR TYPICAL BACKING PLATE SCHEDULES.
- COORDINATE STORAGE OF FURNISHINGS, EQUIPMENT AND OTHER FIXTURES W/ PORT.
- COORDINATE W/ PORT WASTE MINIMIZATION TEAM FOR RECYCLING, RE-PURPOSING, OR DISPOSAL OF DEMOLISHED ITEMS AND CONSTRUCTION WASTE.
- LIGHTING, FIRE ALARM, AND SECURITY TO REMAIN OPERATIONAL DURING CONSTRUCTION. CONTRACTOR TO COORDINATE W/ PORT.
- AREAS BEYOND LINE OF WORK MAY BE INCLUDED TO FACILITATE CONSTRUCTION AND PROJECT COMPLETION.
- REFERENCE SPECIFICATION DIVISIONS 1 AND 2 FOR ADDITIONAL REQUIREMENTS.
- REFERENCE SHEET A11.00 FOR TYPICAL PARTITION TYPES AND METAL STUD FRAMING INFO.
- REFERENCE SHEET A10.00 FOR FINISH AND DOOR / FRAME SCHEDULE
- REFERENCE STRUCTURAL FOR SLAB INFILL DETAILS AT (N) FLOOR DRAINS.
- REPAIR AND REPLACE EXISTING FLOOR, ROOF AND WALL FIREPROOFING AT ALL NEW WALL AND CEILING CONNECTIONS.
- REFERENCE A8 SHEET SERIES FOR FINISH PLANS SHOWING FLOOR AND WALL FINISHES.


#### KEYNOTES

- (N) COLUMN COVER
- (N) PLUMBING FIXTURES, TYP
- TOILET COMPARTMENT, TC2
- URINAL SCREEN, TC2
- SS PLATE AT JAMBS AND ACROSS HEAD OF OPENING, DM1
- NO WORK IN THIS ROOM
- DEFIBRILLATOR CABINET
- FEC
- REMOVE AND REINSTALL (E) WATER FOUNTAINS

#### LEGEND

- (E) 2-HOUR RATED WALL
- (E) 1-HOUR RATED WALL
- (N) FULL HEIGHT WALL WITH FINISH PER SCHEDULE, SEE PARTITION TYPES
- (E) WALL WITH FINISH PER SCHEDULE, SEE PARTITION TYPES

#### KEY PLAN

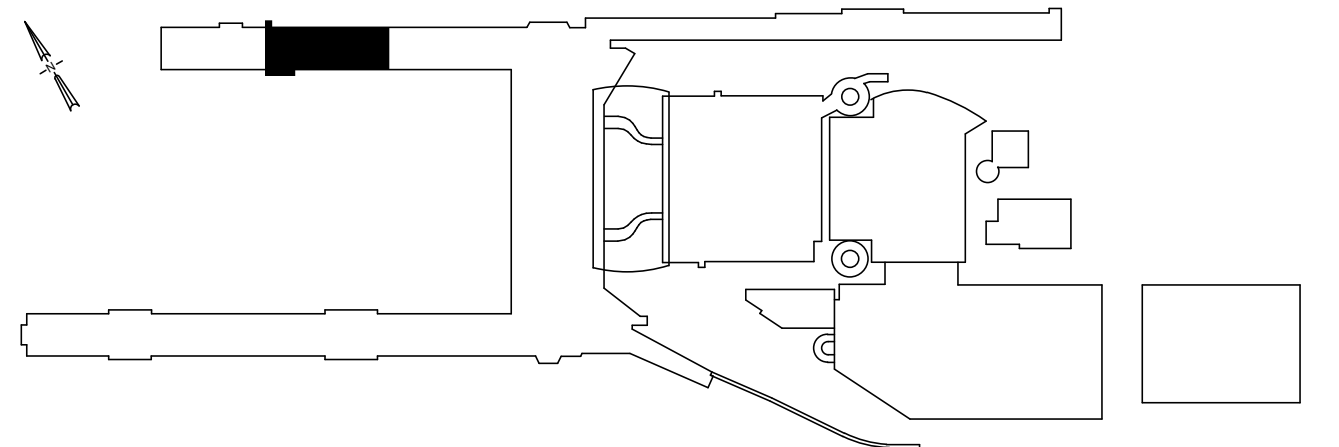

Port of Portland



mwa architects

2025D031  
DESIGN NUMBER

103101  
PROJECT NUMBER

PORTLAND INTERNATIONAL AIRPORT

TERMINAL RESTROOM REHABILITATION 2026

CONCURSE D - SECTOR 2 - D2221, D2222, D2223 - ENPLANING - FLOOR PLAN

|                |               |
|----------------|---------------|
| SUBMITTED BY   | BRIAN FRANCIS |
| DESIGNED BY    | A. COOK       |
| DRAWN BY       | M. PHILLIPS   |
| CHECKED BY     | J. ROOT       |
| DATE           | JULY 2026     |
| SHEET NO.      | 16            |
| TYPE           | CD            |
| DISC. SHT. NO. | A3.01         |