


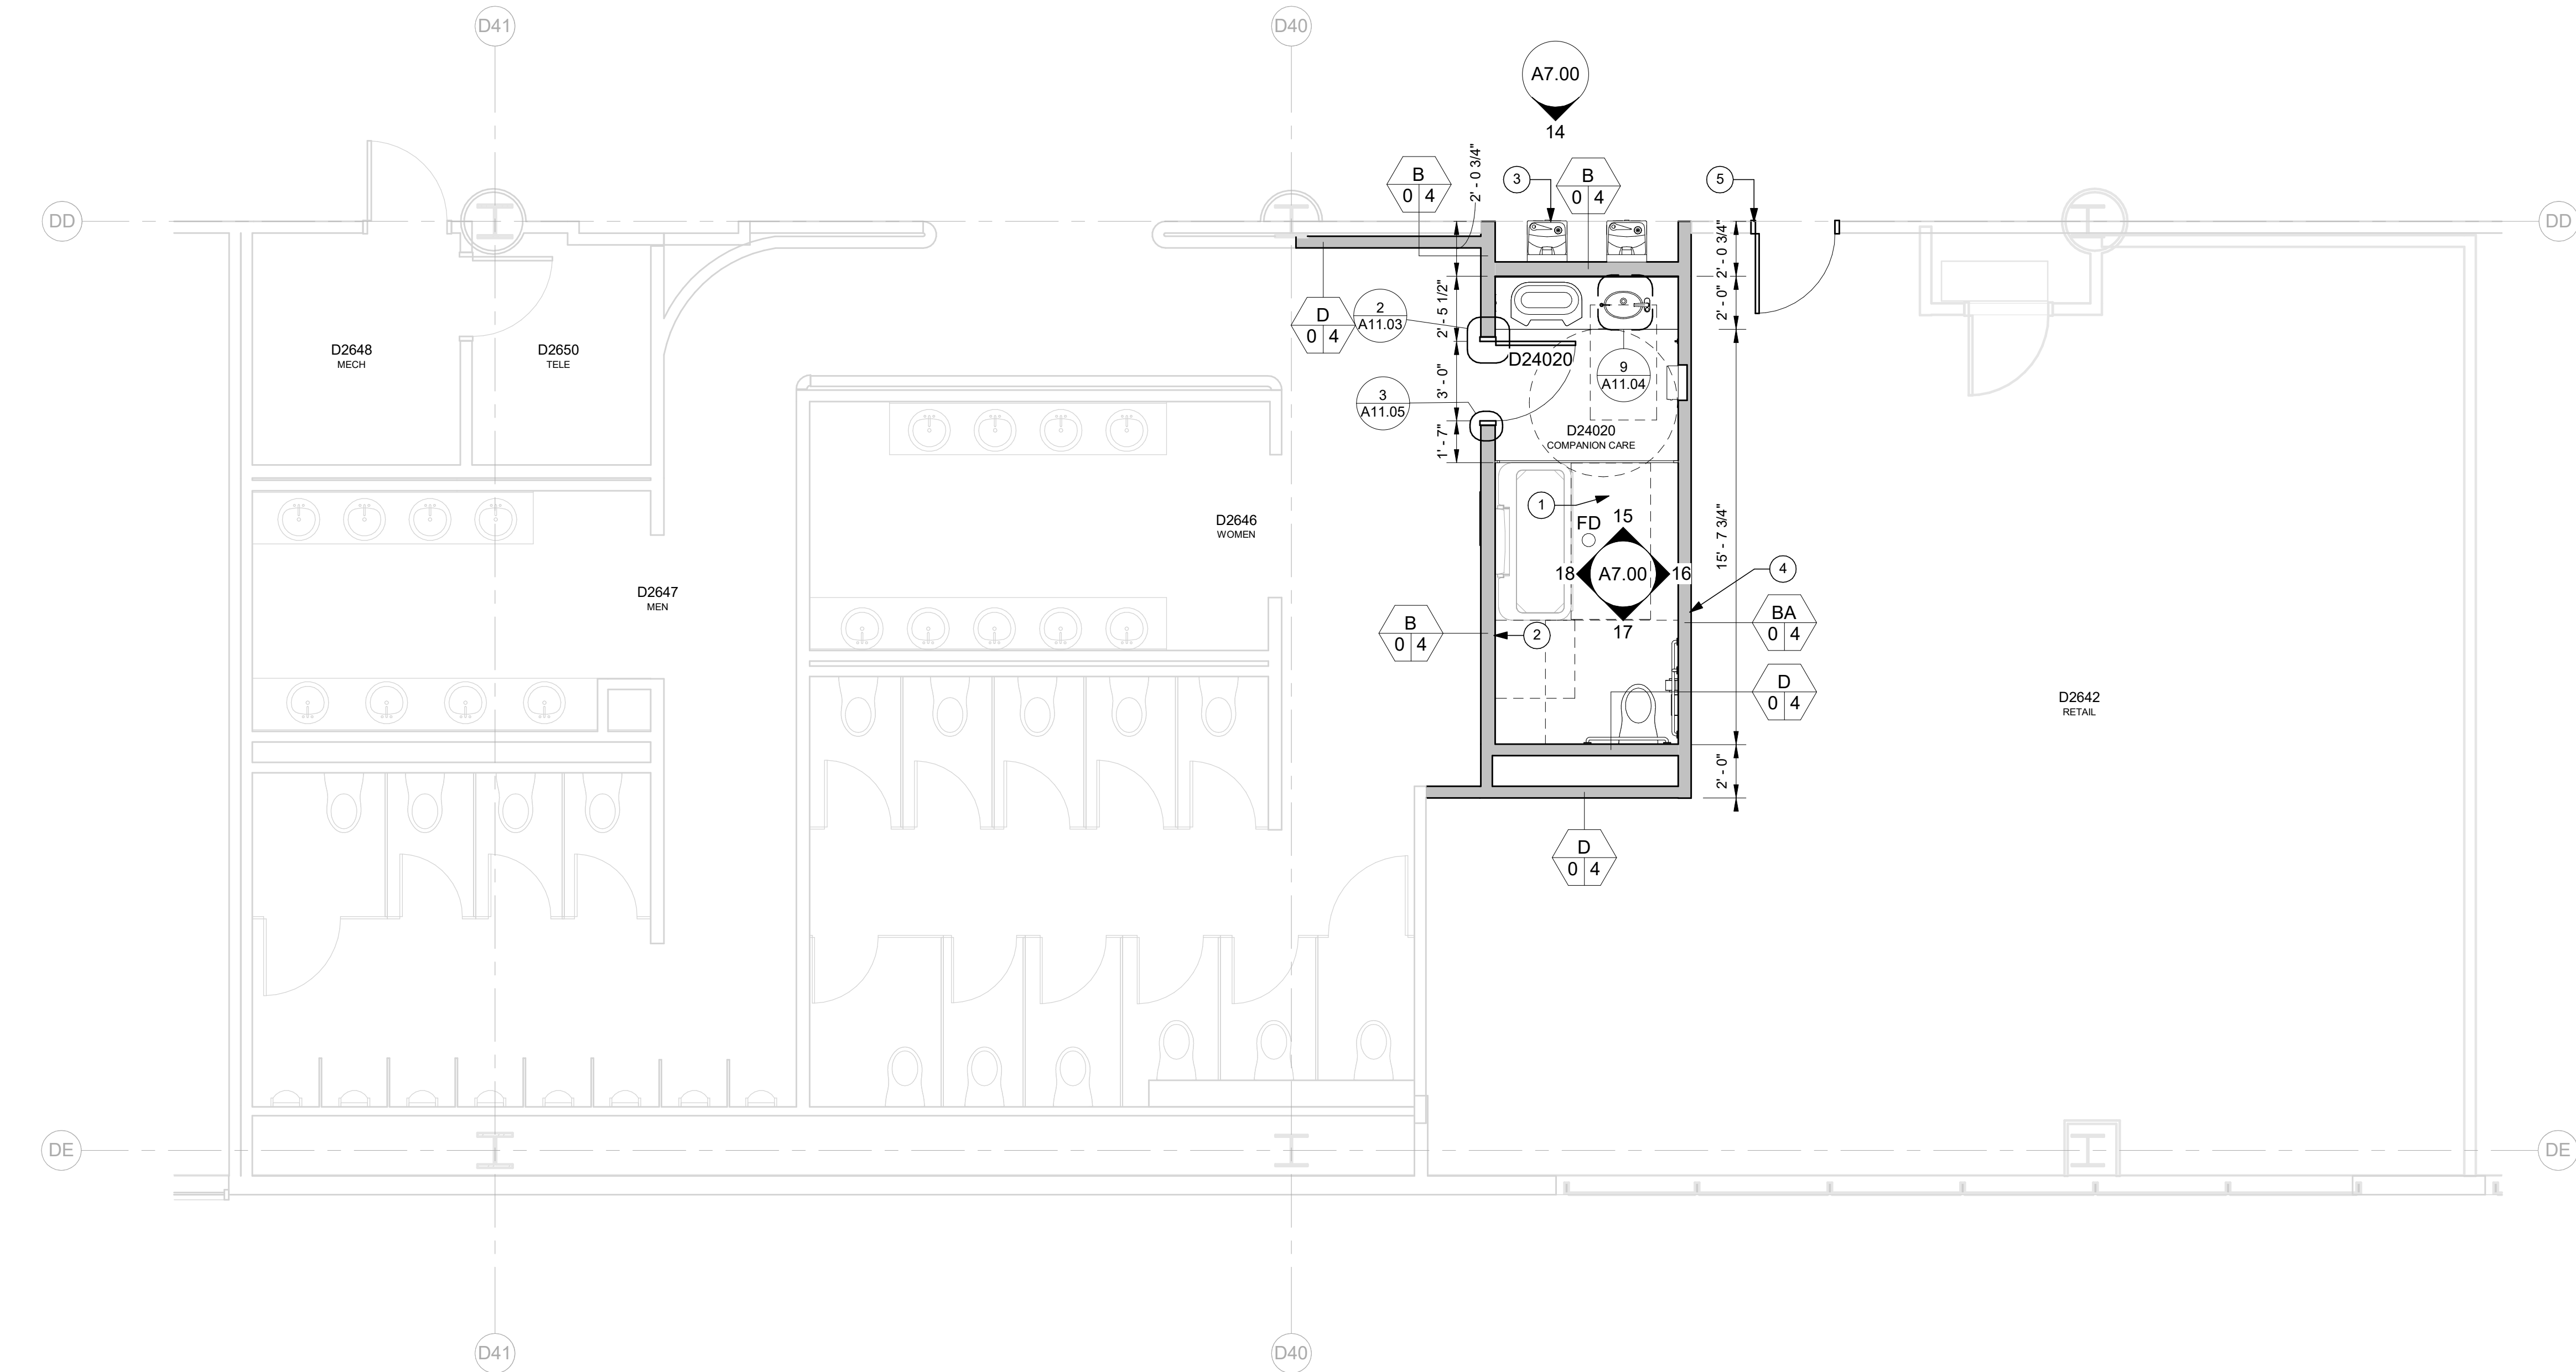


PLUMBING FIXTURE COUNT TOTAL		
FIXTURE TYPE	EXISTING	NEW TOTAL PROVIDED
WC	8 URINALS MEN, 4 WC MEN, 11 WC WOMEN	8 URINALS MEN, 4 WC MEN, 11 WC WOMEN, 1 UNISEX
LAV	8 MEN, 9 WOMEN	8 MEN, 9 WOMEN, 1 UNISEX
DF	2	2

1. DIMENSIONS ARE TO FACE OF FINISH AND CENTERLINE OF GRID LINES. THEY ARE FOR REFERENCE ONLY AND SHOULD BE FIELD VERIFIED BY CONTRACTOR FOR ACCURACY.
2. CONTRACTOR SHALL MAINTAIN FIRE RATED ASSEMBLIES AS REQUIRED.
3. CONTRACTOR SHALL PROTECT ALL (E) ADJACENT SURFACES AND FINISHES NOT RECEIVING WORK . ADJACENT FINISHES SHALL BE RESTORED TO PRE-CONSTRUCTION CONDITION.
4. CONTRACTOR TO COORDINATE ALL BACKING FOR WALL MOUNTED ACCESSORIES AS NEEDED. REFERENCE SHEET A11.01 FOR TYPICAL BACKING PLATE SCHEDULES.
5. COORDINATE STORAGE OF FURNISHINGS, EQUIPMENT AND OTHER FIXTURES W/ PORT.
6. COORDINATE W/ PORT WASTE MINIMIZATION TEAM FOR RECYCLING, RE-PURPOSING, OR DISPOSAL OF DEMOLISHED ITEMS AND CONSTRUCTION WASTE.
7. LIGHTING, FIRE ALARM, AND SECURITY TO REMAIN OPERATIONAL DURING CONSTRUCTION. CONTRACTOR TO COORDINATE W/ PORT.
8. AREAS BEYOND LINE OF WORK MAY BE INCLUDED TO FACILITATE CONSTRUCTION AND PROJECT COMPLETION.
9. REFERENCE SPECIFICATION DIVISIONS 1 AND 2 FOR ADDITIONAL REQUIREMENTS.
10. REFERENCE SHEET A11.00 FOR TYPICAL PARTITION TYPES AND METAL STUD FRAMING INFO.
11. REFERENCE SHEET A10.00 FOR FINISH AND DOOR / FRAME SCHEDULE
12. REFERENCE STRUCTURAL FOR SLAB INFILL DETAILS AT (N) FLOOR DRAINS.
13. REPAIR AND REPLACE EXISTING FLOOR, ROOF AND WALL FIREPROOFING AT ALL NEW WALL AND CEILING CONNECTIONS.
14. REFERENCE A8 SHEET SERIES FOR FINISH PLANS SHOWING FLOOR AND WALL FINISHES.

1 (N) FLOOR DRAIN
2 (N) EMERGENCY CALL BUTTON
3 (E) RELOCATED WATER FOUNTAINS
4 NO FINISH REQUIRED THIS SIDE OF WALL, OPEN TO STUDS AND INSULATION
5 (E) RELOCATED TEMPORARY BARRICADE DOOR

	(E) 2-HOUR RATED WALL
	(E) 1-HOUR RATED WALL
	(N) FULL HEIGHT WALL WITH FINISH PER SCHEDULE, SEE PARTITION TYPES
	(E) WALL WITH FINISH PER SCHEDULE, SEE PARTITION TYPES

1 CONCURSE D - SECTOR 3 - D24020 - ENPLANING - FLOOR PLAN
SCALE: 1/4" = 1'-0"

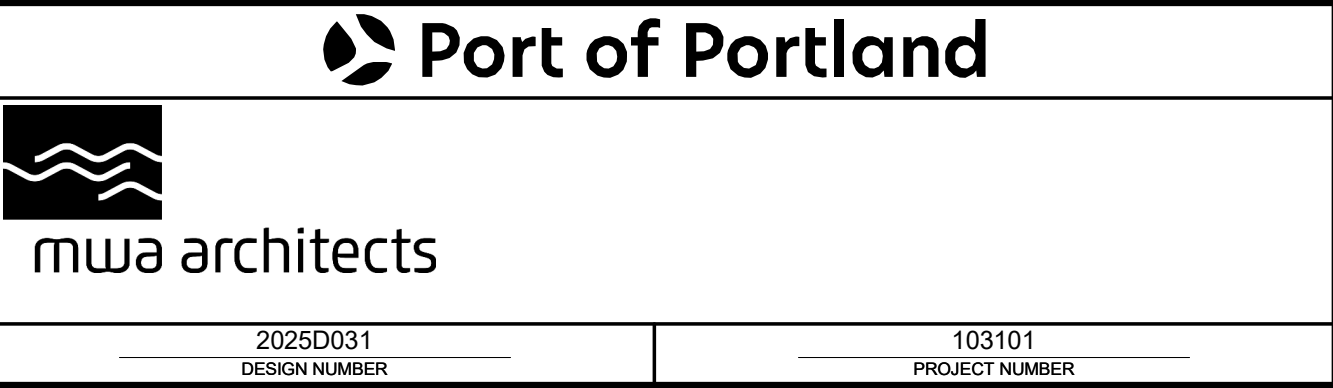[illegible]

PORTLAND INTERNATIONAL AIRPORT TERMINAL RESTROOM REHABILITATION 2026 CONCOURSE D - SECTOR 3 - D24020 - ENPLANING - FLOOR PLAN	SUBMITTED BY		BRIAN FRANCIS		
	DESIGNED BY		A. COOK		
	DRAWN BY		M. PHILLIPS		
	CHECKED BY		J. ROOT		
	DATE		JULY 2026		
	SHEET NO.		17	TYPE CD	
DRAWING NO.		PDX 2026-510		DISC. SHT. NO.	A3.02