

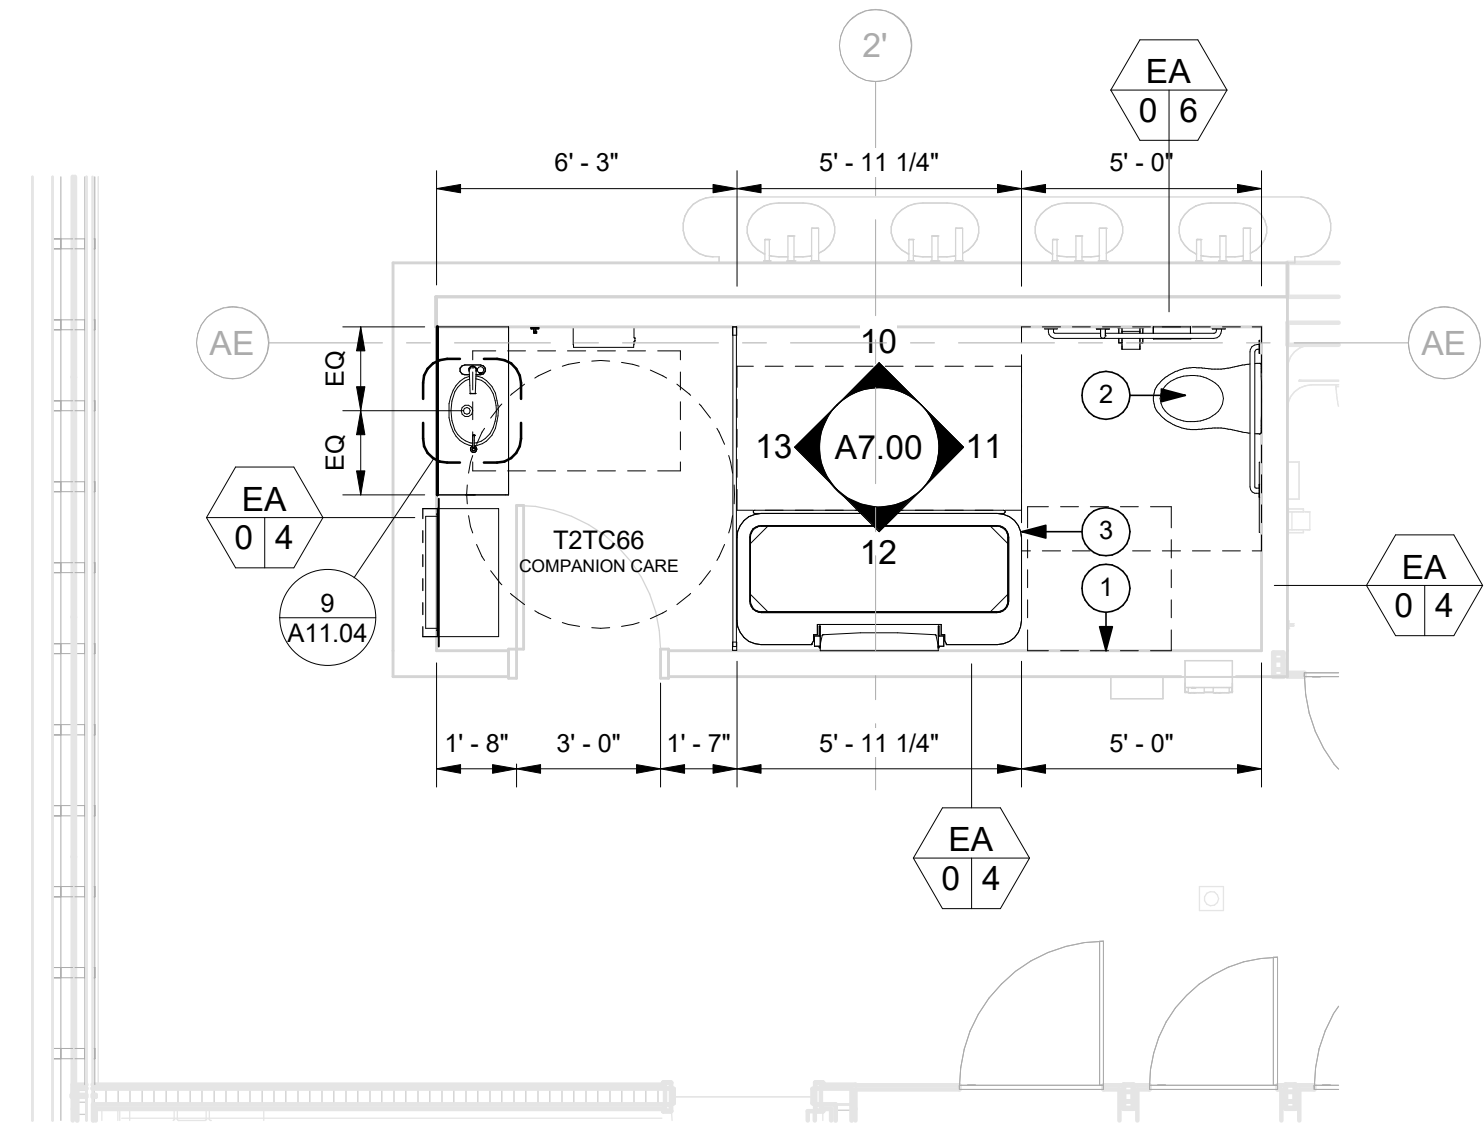



CAN YOU SEE THE AIRPLANES? THE ADJACENT SAMPLES SHOW THREE DIFFERENT LEVELS OF SHADING. SETTINGS FOR VIEWING AND PRINTING DRAWING CONTENT ARE OPTIMIZED WHEN ALL THREE PLANES ARE VISIBLE. THIS GUIDANCE IS PROVIDED FOR REFERENCE ONLY.

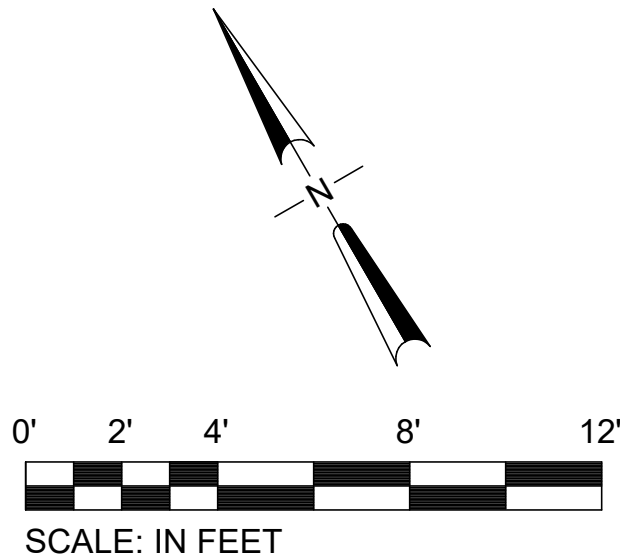


1 TERMINAL - SECTOR W5 - T2TC66 - ENPLANING - FLOOR PLAN
SCALE: 1/4" = 1'-0"

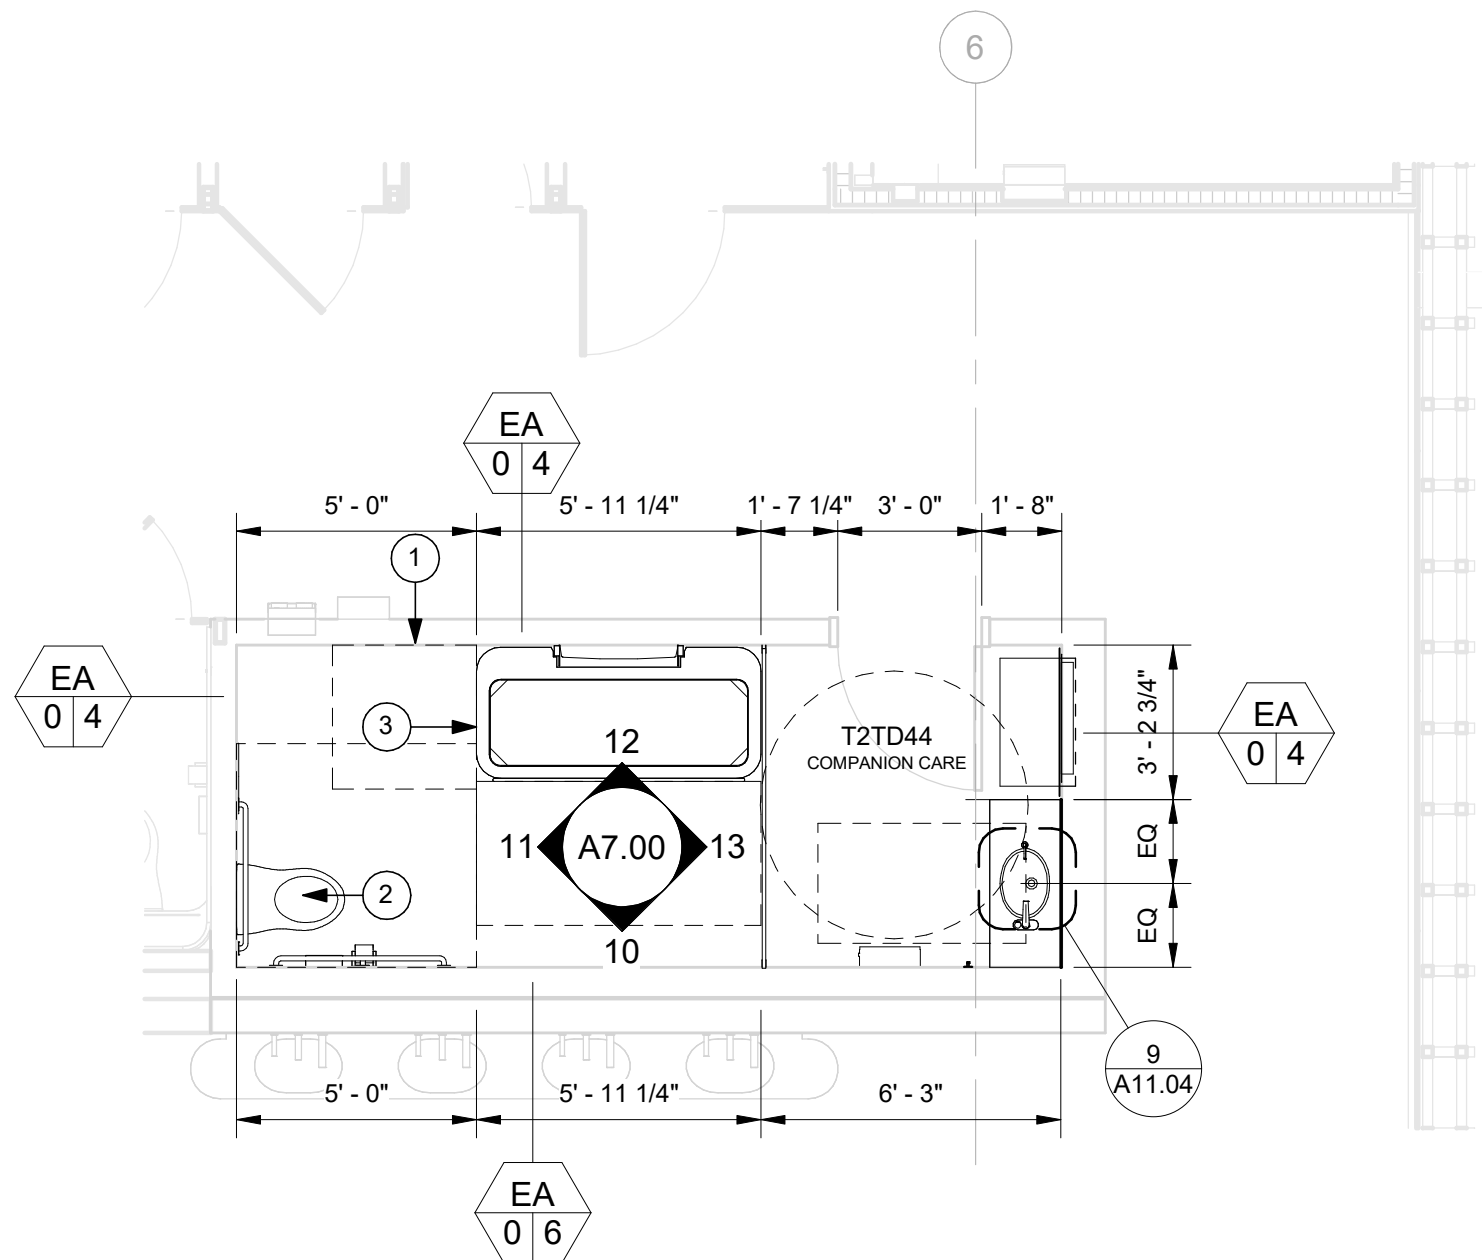

2 TERMINAL - SECTOR E5 - T2TD44 - ENPLANING - FLOOR PLAN
SCALE: 1/4" = 1'-0"

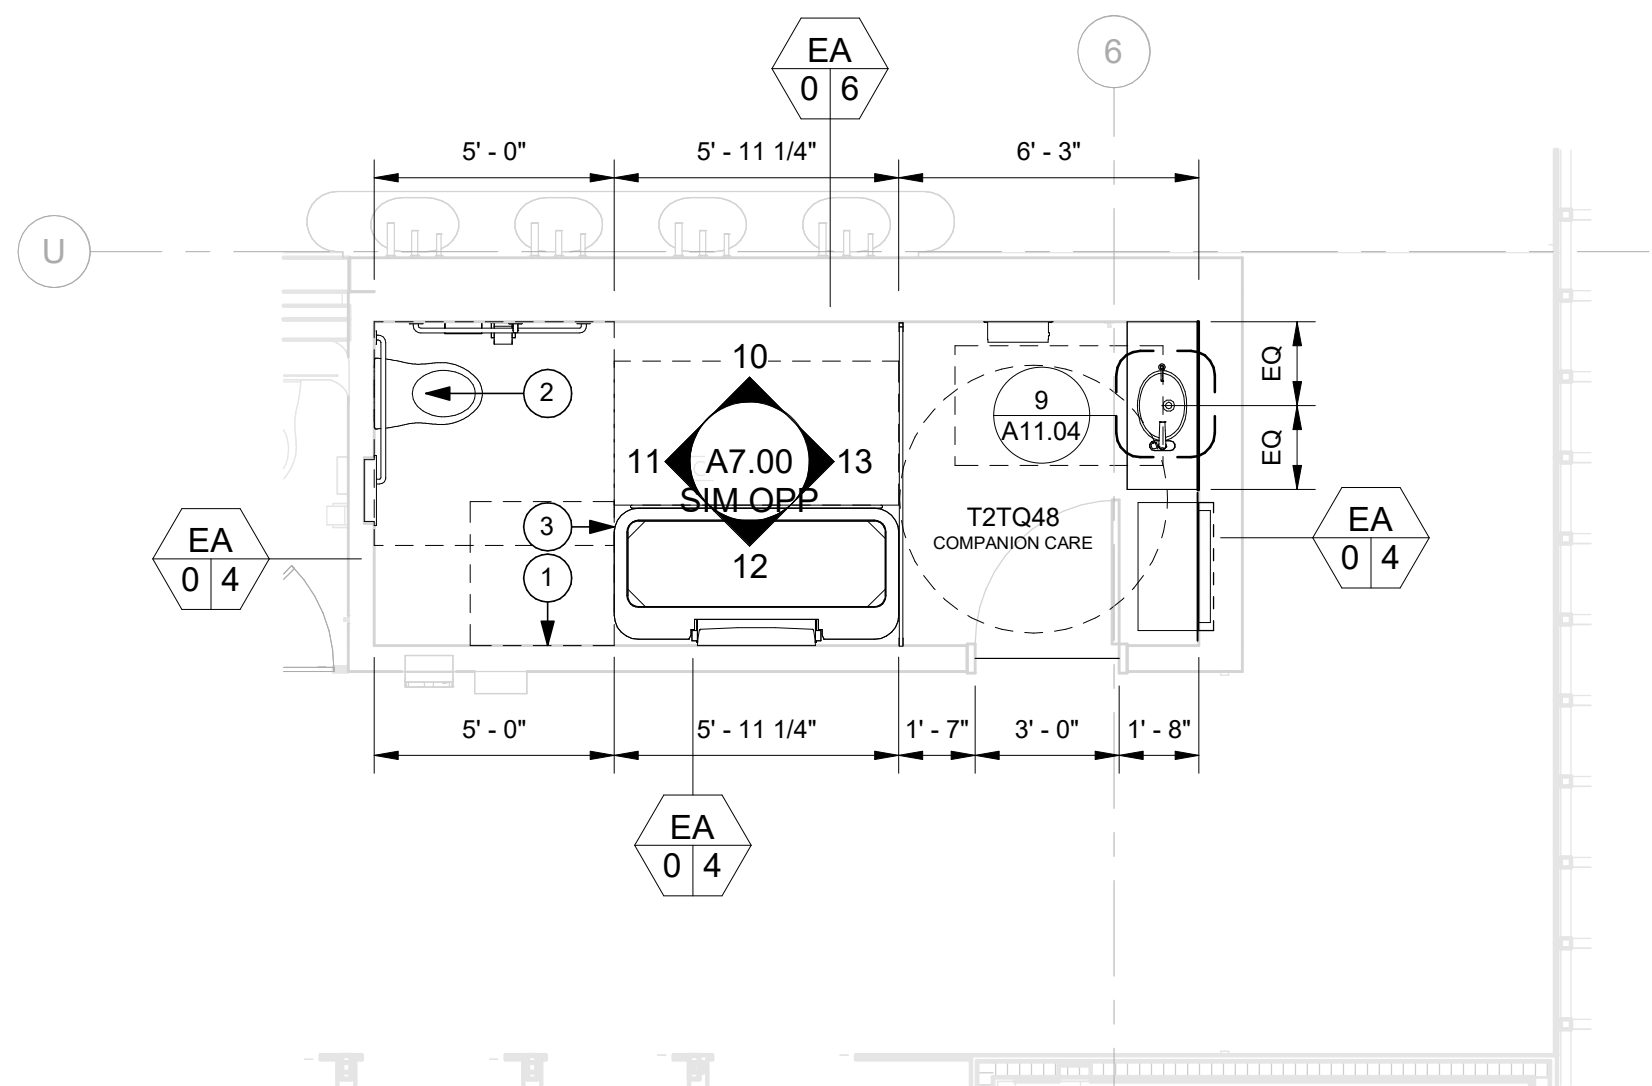

3 TERMINAL - SECTOR E2 - T2TQ48 - ENPLANING - FLOOR PLAN
SCALE: 1/4" = 1'-0"

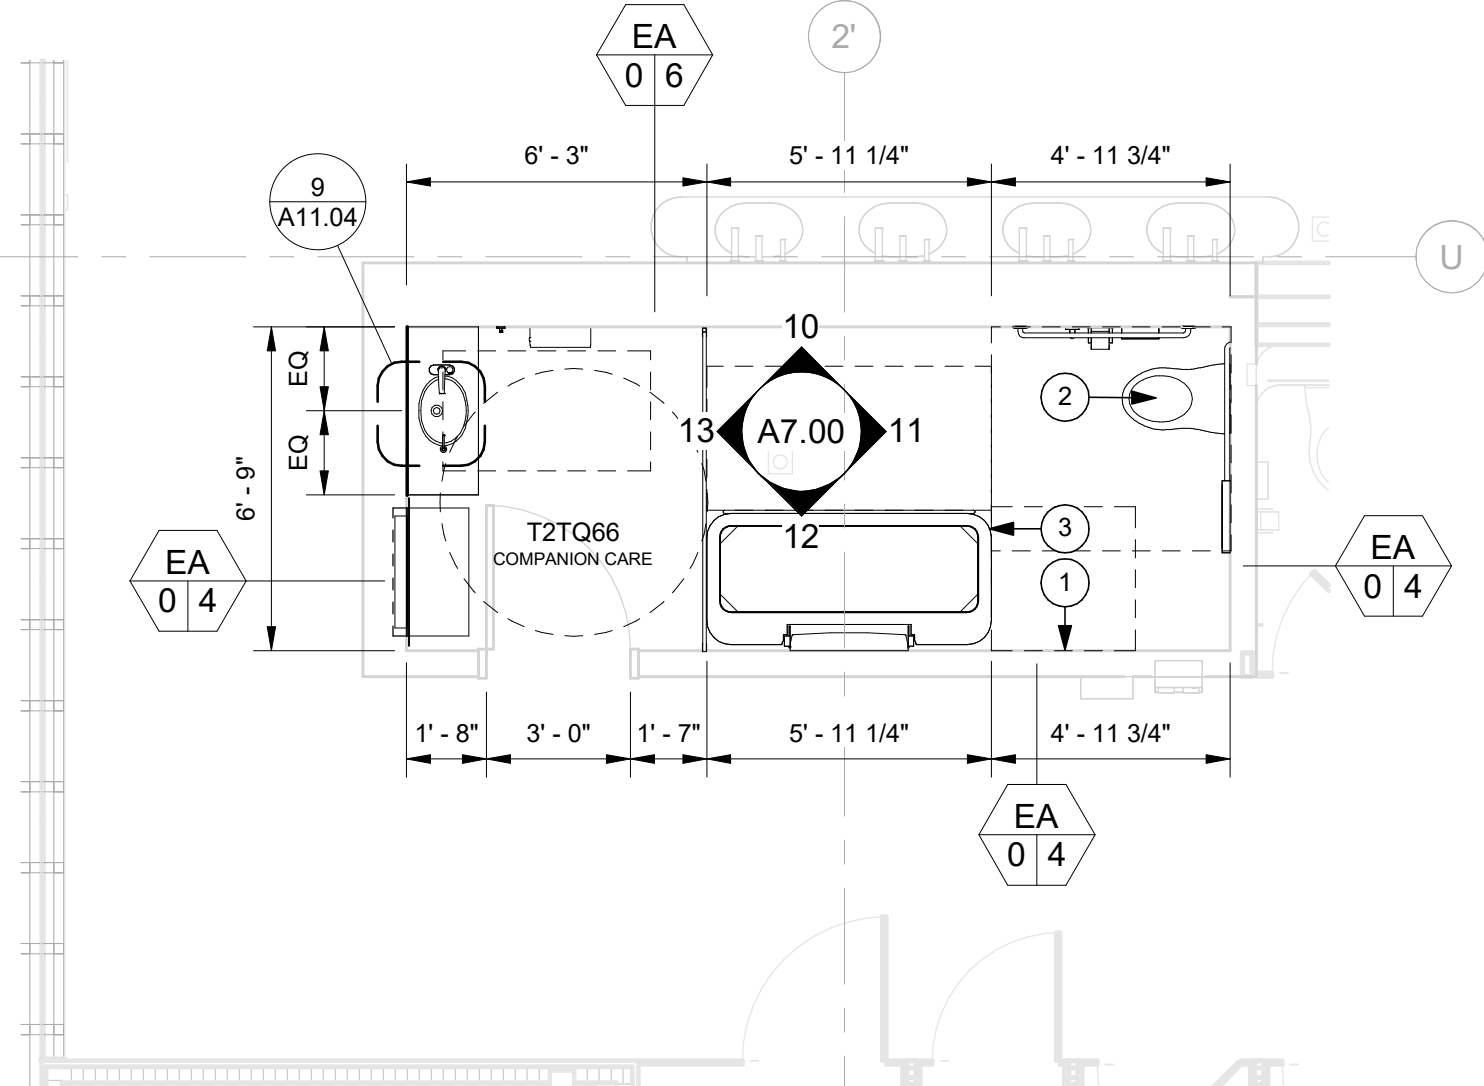

4 TERMINAL - SECTOR 2 - T2TQ66 - ENPLANING - FLOOR PLAN
SCALE: 1/4" = 1'-0"

NOTES

- DIMENSIONS ARE TO FACE OF FINISH AND CENTERLINE OF GRID LINES. THEY ARE FOR REFERENCE ONLY AND SHOULD BE FIELD VERIFIED BY CONTRACTOR FOR ACCURACY.
- CONTRACTOR SHALL MAINTAIN FIRE RATED ASSEMBLIES AS REQUIRED.
- CONTRACTOR SHALL PROTECT ALL (E) ADJACENT SURFACES AND FINISHES NOT RECEIVING WORK. ADJACENT FINISHES SHALL BE RESTORED TO PRE-CONSTRUCTION CONDITION.
- CONTRACTOR TO COORDINATE ALL BACKING FOR WALL MOUNTED ACCESSORIES AS NEEDED. REFERENCE SHEET A11.01 FOR TYPICAL BACKING PLATE SCHEDULES.
- COORDINATE STORAGE OF FURNISHINGS, EQUIPMENT AND OTHER FIXTURES W/ PORT.
- COORDINATE W/ PORT WASTE MINIMIZATION TEAM FOR RECYCLING, RE-PURPOSING, OR DISPOSAL OF DEMOLISHED ITEMS AND CONSTRUCTION WASTE.
- LIGHTING, FIRE ALARM, AND SECURITY TO REMAIN OPERATIONAL DURING CONSTRUCTION. CONTRACTOR TO COORDINATE W/ PORT.
- AREAS BEYOND LINE OF WORK MAY BE INCLUDED TO FACILITATE CONSTRUCTION AND PROJECT COMPLETION.
- REFERENCE SPECIFICATION DIVISIONS 1 AND 2 FOR ADDITIONAL REQUIREMENTS.
- REFERENCE SHEET A11.00 FOR TYPICAL PARTITION TYPES AND METAL STUD FRAMING INFO.
- REFERENCE SHEET A10.00 FOR FINISH AND DOOR / FRAME SCHEDULE
- REFERENCE STRUCTURAL FOR SLAB INFILL DETAILS AT (N) FLOOR DRAINS.
- REPAIR AND REPLACE EXISTING FLOOR, ROOF AND WALL FIREPROOFING AT ALL NEW WALL AND CEILING CONNECTIONS.
- REFERENCE A8 SHEET SERIES FOR FINISH PLANS SHOWING FLOOR AND WALL FINISHES.


KEYNOTES

- (N) EMERGENCY CALL BUTTON
- (N) PLUMBING FIXTURES, TYP
- ADULT CHANGING STATION, PROVIDE WALL BLOCKING PER STRUCTURAL

LEGEND

- (E) 2-HOUR RATED WALL
- (E) 1-HOUR RATED WALL
- (N) FULL HEIGHT WALL WITH FINISH PER SCHEDULE, SEE PARTITION TYPES
- (E) WALL WITH FINISH PER SCHEDULE, SEE PARTITION TYPES

KEY PLAN

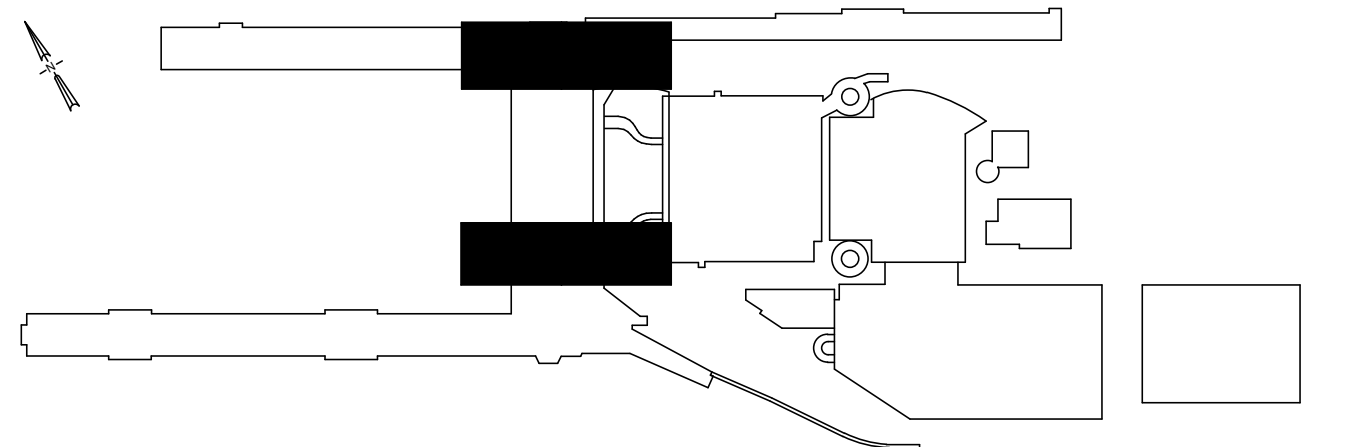

Port of Portland



mwa architects

2025D031
DESIGN NUMBER

103101
PROJECT NUMBER

PORTLAND INTERNATIONAL AIRPORT

TERMINAL RESTROOM REHABILITATION 2026

TERMINAL - SECTOR W5, SECTOR E5, SECTOR E2, SECTOR W - T2TC66, T2TD44, T2TQ48, T2TQ66 - ENPLANING - FLOOR PLAN

SUBMITTED BY	BRIAN FRANCIS
DESIGNED BY	A. COOK
DRAWN BY	M. PHILLIPS
CHECKED BY	J. ROOT
DATE	JULY 2026
SHEET NO.	19
DRAWING NO.	PDX 2026-510
TYPE	CD
DISC. SHT. NO.	A3.04