



CAN YOU SEE THE AIRPLANES? THE ADJACENT SAMPLES SHOW THREE DIFFERENT LEVELS OF SHADING. SETTINGS FOR VIEWING AND PRINTING DRAWING CONTENT ARE OPTIMIZED WHEN ALL THREE PLANES ARE VISIBLE. THIS GUIDANCE IS PROVIDED FOR REFERENCE ONLY.

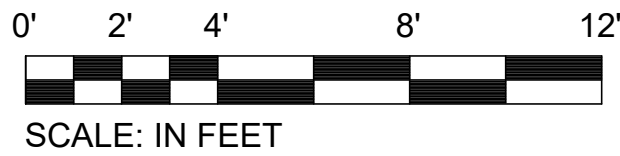

PLUMBING FIXTURE COUNT TOTAL	
FIXTURE TYPE	EXISTING
WC	5 URINALS MEN, 5 WC MEN, 9 WC WOMEN
LAV	7 MEN, 8 WOMEN
DF	2

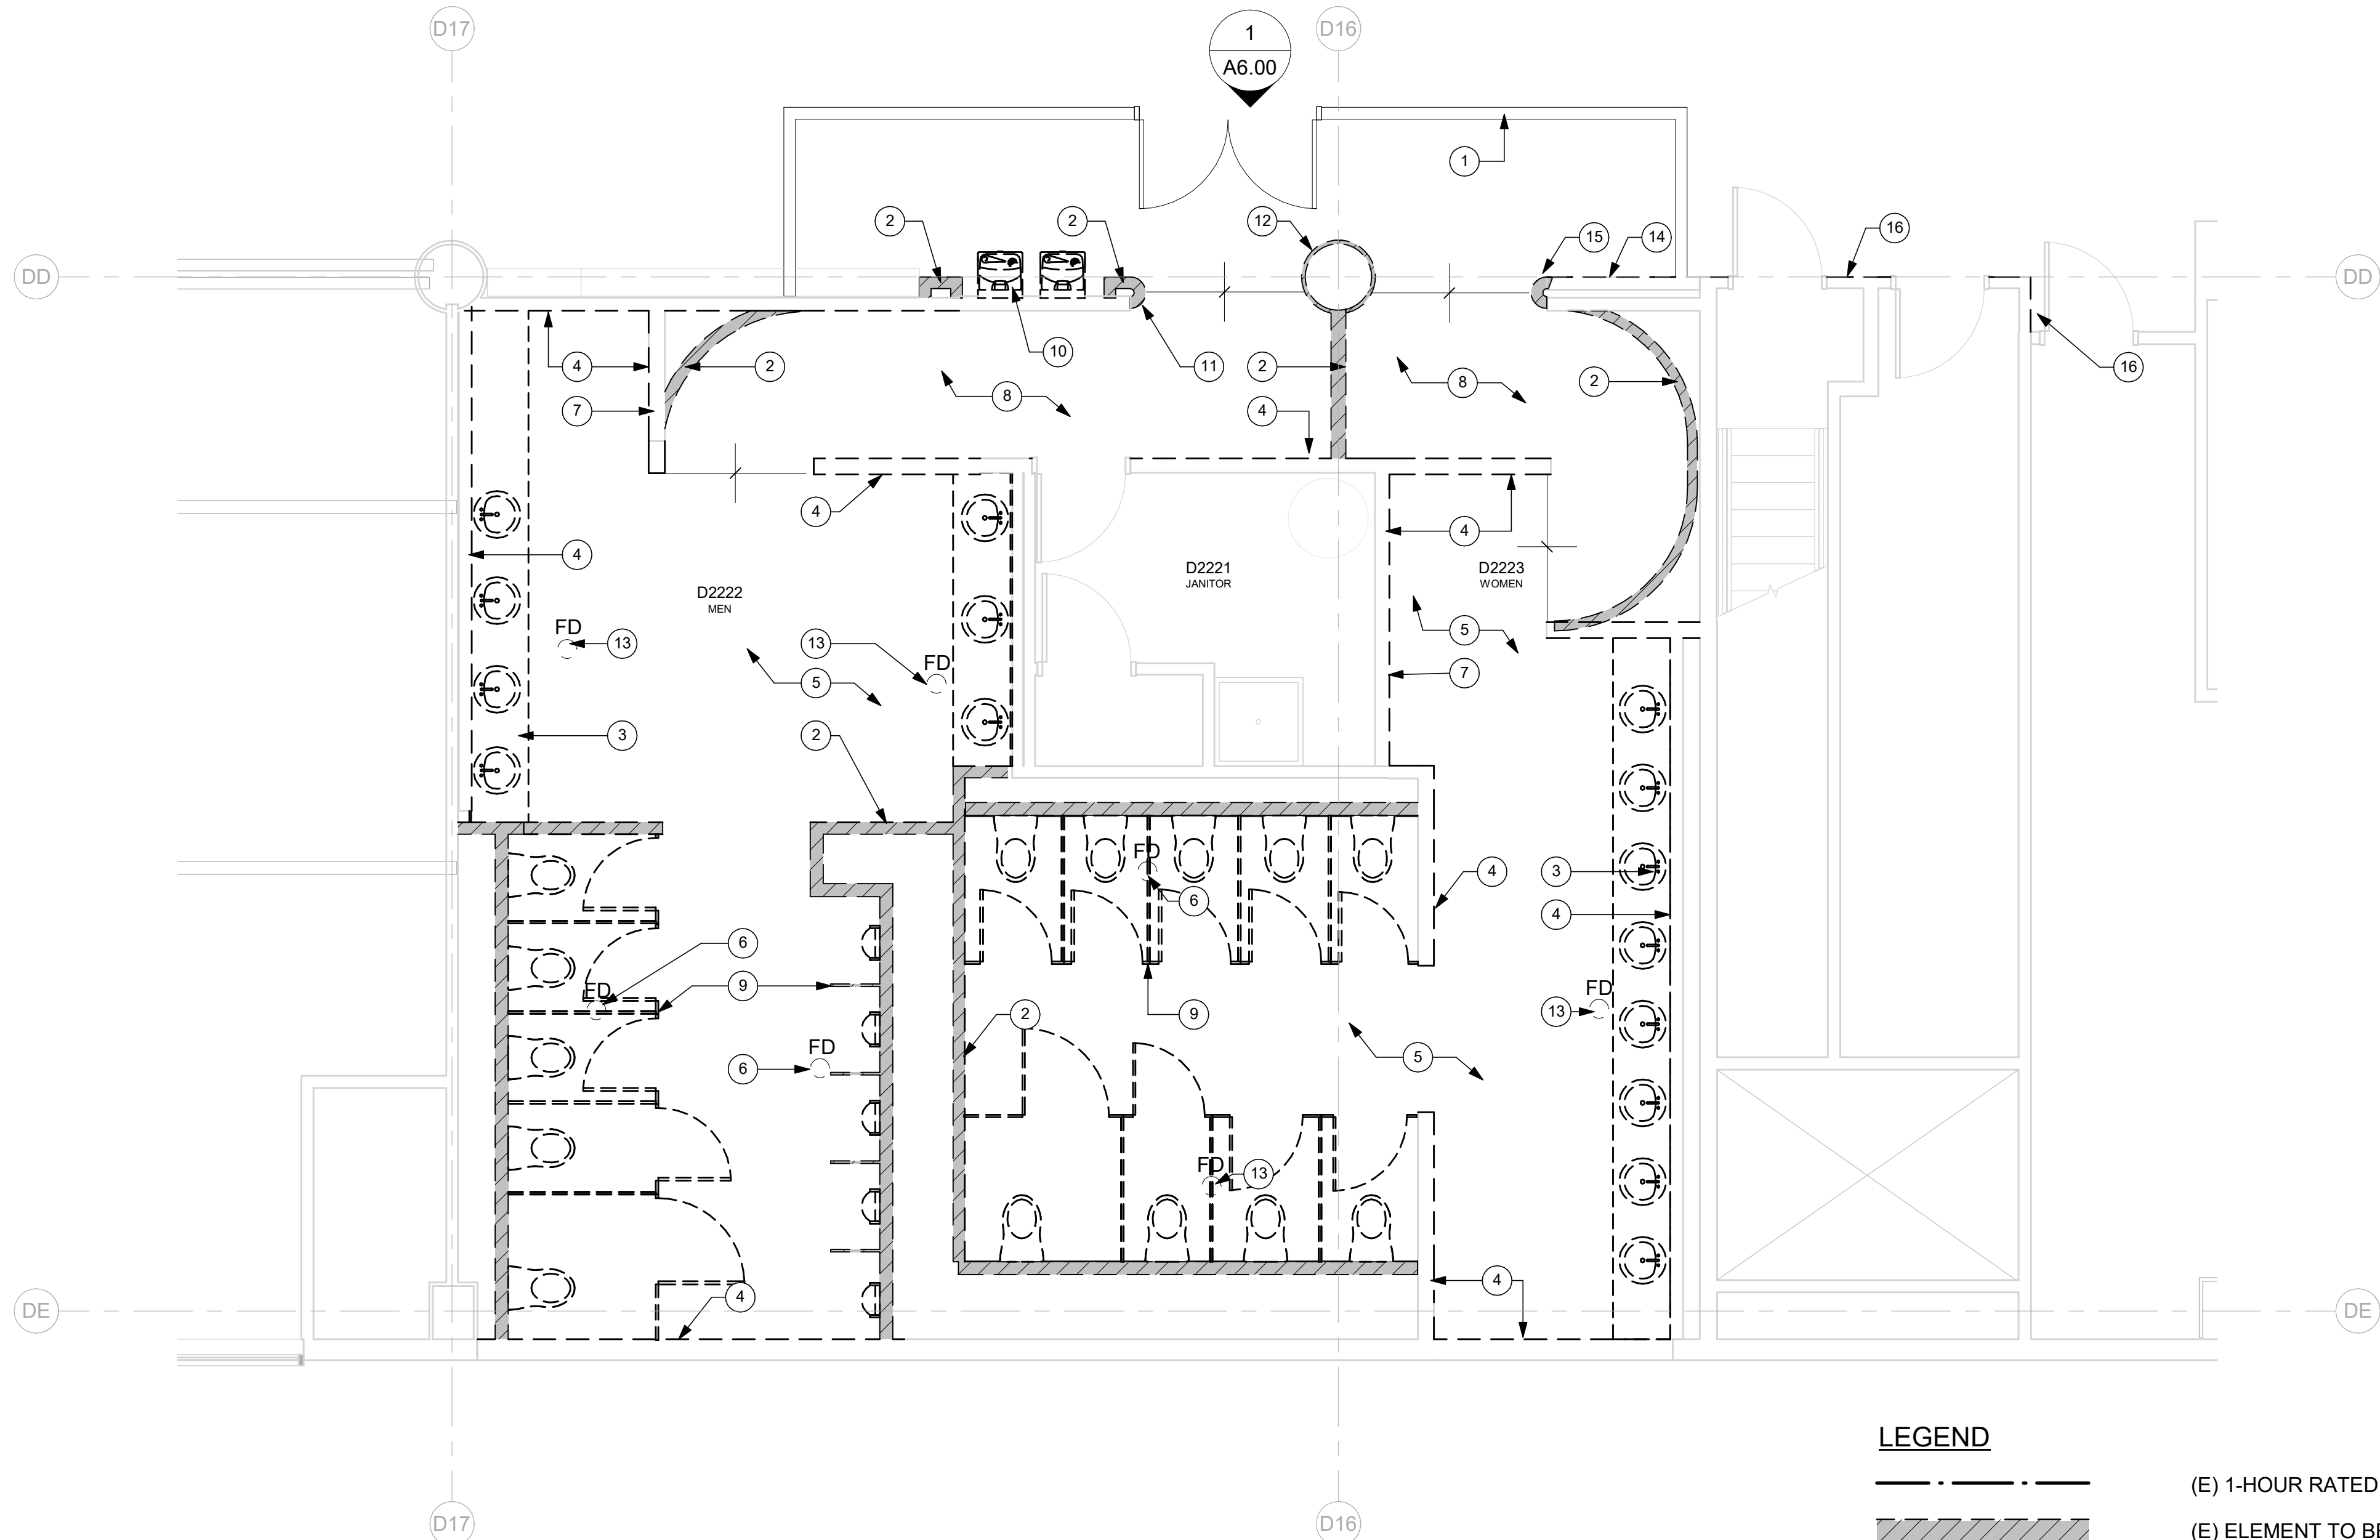


1 CONCOURSE D - SECTOR 2 - D2221, D2222, D2223 - ENPLANING - DEMO PLAN
SCALE: 1/4" = 1'-0"

LEGEND

- (E) 1-HOUR RATED WALL
- (E) ELEMENT TO BE DEMOLISHED
- (E) ELEMENT TO BE DEMOLISHED
- (E) TO REMAIN
- FLOOR FINISH TRANSITION

KEY PLAN

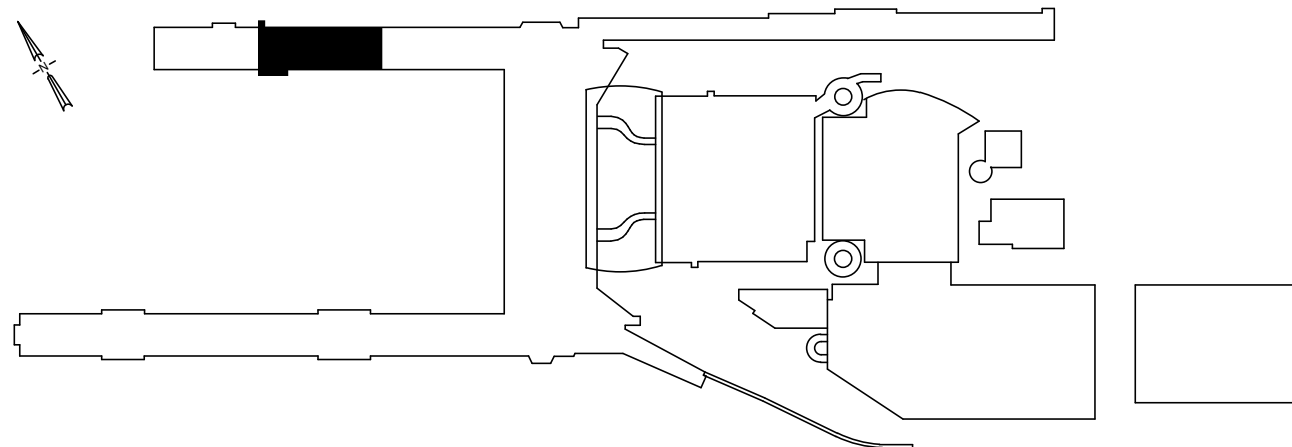

NOTES

- DIMENSIONS ARE TO FACE OF FINISH AND CENTERLINE OF GRID LINES. THEY ARE FOR REFERENCE ONLY AND SHOULD BE FIELD VERIFIED BY CONTRACTOR FOR ACCURACY.
- CONTRACTOR SHALL MAINTAIN FIRE RATED ASSEMBLIES AS REQUIRED.
- CONTRACTOR SHALL PROTECT ALL (E) ADJACENT SURFACES AND FINISHES NOT RECEIVING WORK. ADJACENT FINISHES SHALL BE RESTORED TO PRE-CONSTRUCTION CONDITION.
- CONTRACTOR TO COORDINATE ALL BACKING FOR WALL MOUNTED ACCESSORIES AS NEEDED. REFERENCE SHEET A11.01 FOR TYPICAL BACKING PLATE SCHEDULES.
- COORDINATE STORAGE OF FURNISHINGS, EQUIPMENT AND OTHER FIXTURES W/ PORT.
- COORDINATE W/ PORT WASTE MINIMIZATION TEAM FOR RECYCLING, RE-PURPOSING, OR DISPOSAL OF DEMOLISHED ITEMS AND CONSTRUCTION WASTE.
- LIGHTING, FIRE ALARM, AND SECURITY TO REMAIN OPERATIONAL DURING CONSTRUCTION. CONTRACTOR TO COORDINATE W/ PORT.
- AREAS BEYOND LINE OF WORK MAY BE INCLUDED TO FACILITATE CONSTRUCTION AND PROJECT COMPLETION.
- REFERENCE SPECIFICATION DIVISIONS 1 AND 2 FOR ADDITIONAL REQUIREMENTS.
- REFERENCE SHEET A11.00 FOR TYPICAL PARTITION TYPES AND METAL STUD FRAMING INFO.
- REFERENCE SHEET A10.00 FOR FINISH AND DOOR / FRAME SCHEDULE.
- REFERENCE STRUCTURAL FOR SLAB INFILL DETAILS AT (N) FLOOR DRAINS.
- REPAIR AND REPLACE EXISTING FLOOR, ROOF AND WALL FIREPROOFING AT ALL NEW WALL AND CEILING CONNECTIONS.
- REFERENCE A8 SHEET SERIES FOR FINISH PLANS SHOWING FLOOR AND WALL FINISHES.

KEYNOTES

- TEMPORARY BARRICADE WALL. COORDINATE WALL TYPE, CONNECTIONS, EXTENTS, AND KEYING W/ THE PORT
- DEMO (E) WALL
- DEMO (E) LAVATORY COUNTER TOP AND MIRRORS
- DEMO (E) WALL FINISH, TILE BACKER, AND GWB TYP. PREPARE FOR NEW SUBSTRATES ACCORDING TO FINISH SCHEDULE
- DEMO (E) FLOOR TILE AND WALL BASE, PREPARE SUBSTRATE TO RECEIVE NEW FLOORING AND BASE PER SCHEDULE, TYP
- DEMO (E) FLOOR DRAIN COVER - REMOVE GRATE AND PREPARE FOR NEW, COORDINATE WITH PLUMBING
- DEMO ALL (E) RESTROOM ACCESSORIES
- DEMO (E) CARPET IN AREA OF WORK AND COORDINATE WITH PORT ON EXTENTS OF REMOVAL
- DEMO ALL (E) TOLIET AND URINAL PARTITIONS, TYP
- REMOVE AND REINSTALL (E) WATER FOUNTAINS
- DEMO (E) WALL AND SS BULLNOSE
- DEMO (E) COLUMN COVER
- DEMO (E) FLOOR DRAIN AND INFILL SLAB
- (E) AED AND TRASH/RECYCLING, COORDINATE TEMPORARY LOCATION WITH PORT INSPECTOR PRIOR TO CONSTRUCTION
- DEMO (E) SS BULLNOSE
- DEMO (E) WOOD PANEL FINISH

Port of Portland



mwa architects

2025D031
DESIGN NUMBER

103101
PROJECT NUMBER

PORTLAND INTERNATIONAL AIRPORT

TERMINAL RESTROOM REHABILITATION 2026

CONCOURSE D - SECTOR 2 - D2221, D2222, D2223 - ENPLANING - DEMO PLAN

SUBMITTED BY	BRIAN FRANCIS
DESIGNED BY	A. COOK
DRAWN BY	M. PHILLIPS
CHECKED BY	J. ROOT
DATE	JULY 2026
SHEET NO.	7
TYPE	CD
DISC. SHT. NO.	A1.01