


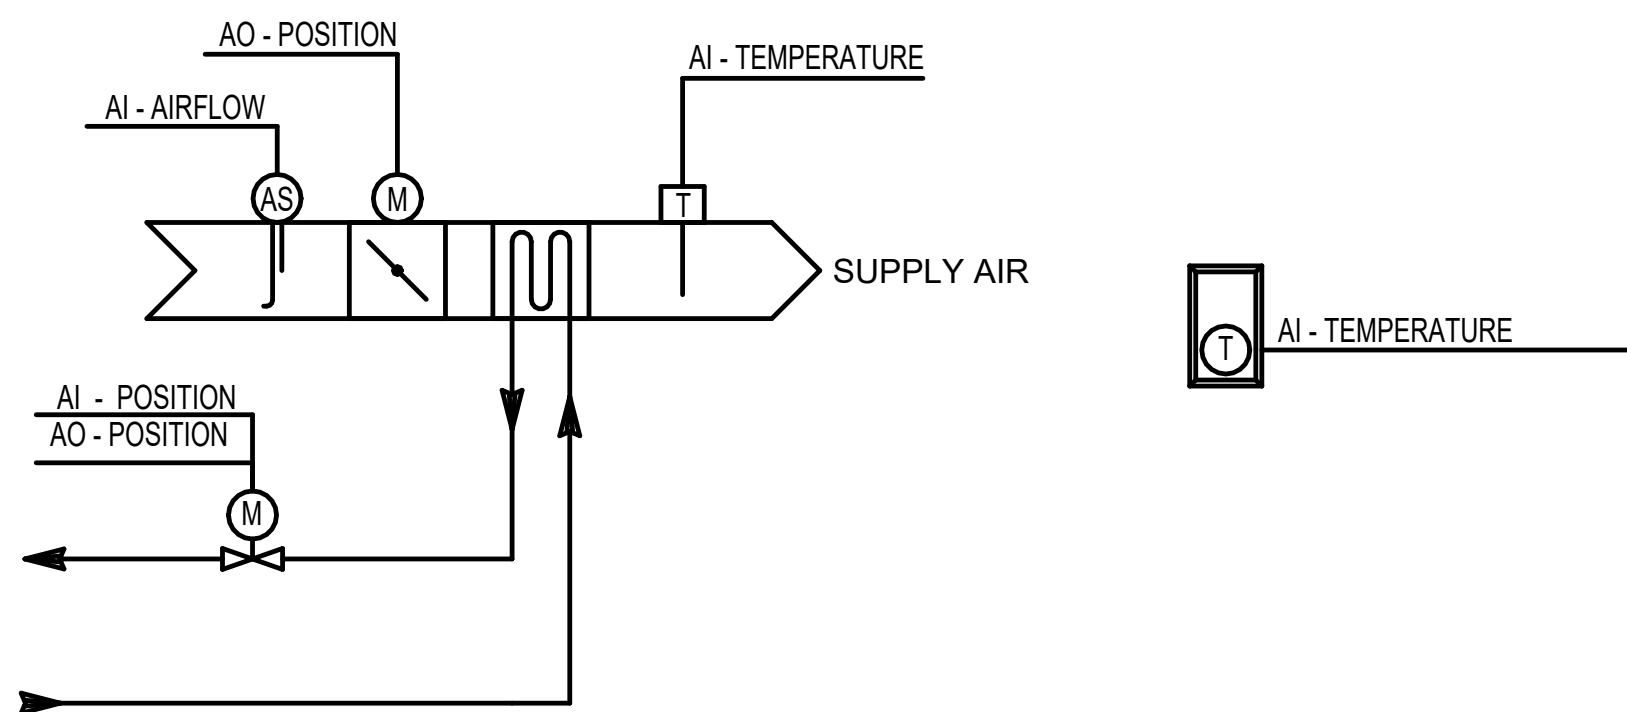


SEQUENCE OF OPERATIONS

-
- DI - POSITION
DO - POSITION
- M
- NC
- EXHAUST AIR
- M
- EC
- DO - START / STOP
- DI - ALARM

2 EXHAUST FAN - GENERAL EXHAUST - TYPICAL
SCALE: N.T.S

[illegible]

 Port of Portland	
 mwa architects	 PAE pae-engineers.com 551 SW 1st Avenue #300 Portland, OR 97204 503.226.2921 pae-engineers.com
2025D031 DESIGN NUMBER	103101 PROJECT NUMBER

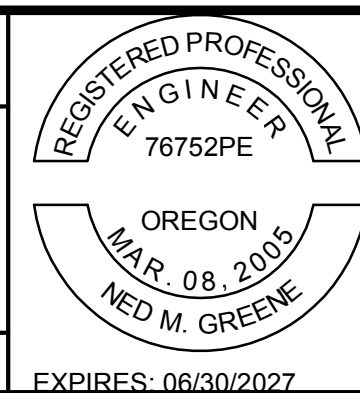

PORTLAND INTERNATIONAL AIRPORT TERMINAL RESTROOM REHABILITATION 2026 CONTROL DIAGRAMS - MECHANICAL	SUBMITTED BY		BRIAN FRANCIS		
	DESIGNED BY		M. GIOVAGNOLI		
	DRAWN BY		S. CARTER		
	CHECKED BY		M. BRUNE		
	DATE		JULY 2026		
	SHEET NO.		79	TYPE	CD
	DRAWING NO.			DISC. SHT. NO.	
PDX 2026-510			M7.01		