


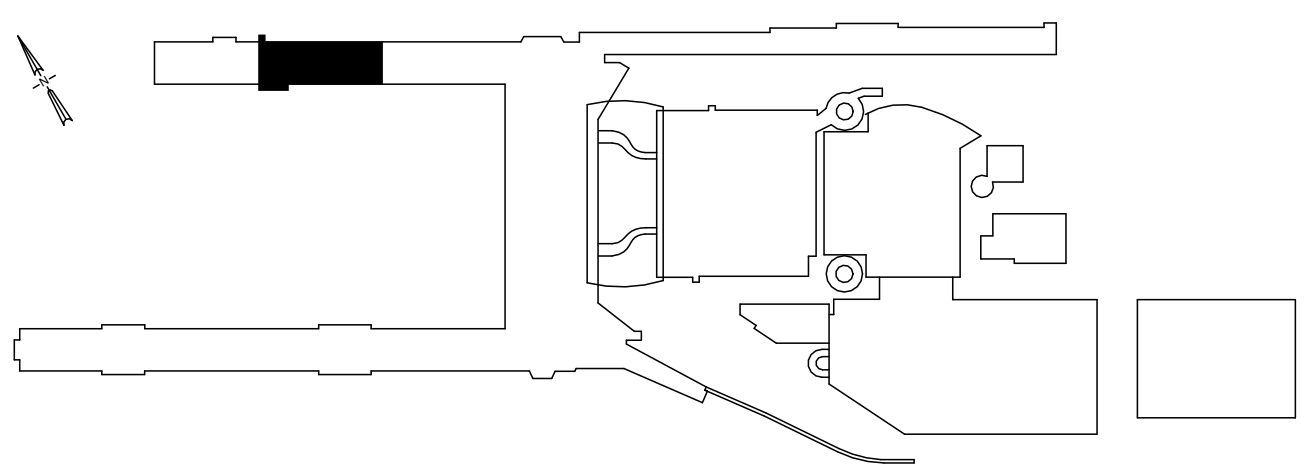

- ## **GENERAL NOTES**
- A. COORDINATE WORK WITH ALL OTHER TRADES.
 - B. VERIFY ALL EQUIPMENT CONNECTIONS WITH THE MANUFACTURERS CERTIFIED DRAWINGS. VERIFY AND PROVIDE TRANSITIONS TO FURNISHED EQUIPMENT. FIELD VERIFY AND COORDINATE ALL DIMENSIONS BEFORE FABRICATION.
 - C. DRAWINGS ARE DIAGRAMMATIC. NOT ALL OFFSETS AND TRANSITIONS IN PIPING ARE SHOWN IN THE DRAWINGS. PROVIDE OFFSETS AND TRANSITIONS REQUIRED FOR INSTALLATION.
 - D. ALL VALVES, WATER HAMMER ARRESTORS, ECT. NEED TO BE INSTALLED IN READILY ACCESSIBLE LOCATIONS.
 - E. EXISTING WORK SHOWN IS EXISTING TO REMAIN UNLESS NOTED OTHERWISE.
 - F. VERIFY EXACT SIZES, LOCATIONS, INVERTS AND ELEVATIONS PRIOR TO RUNNING ANY PIPING. REFER TO ARCHITECTURAL DRAWINGS FOR EXACT LOCATIONS OF ALL FIXTURES AND EQUIPMENT.
 - G. PROVIDE WATER HAMMER ARRESTORS BEHIND ACCESS PANEL FOR URINAL BANKS AND BEHIND TOILET SEAT COVER DISPENSER FOR WATER CLOSETS. SIZE AND LOCATE WATER HAMMER ARRESTORS PER PDI STANDARDS.
 - H. TRAP PRIMING SHALL BE PROVIDED FOR ALL FLOOR DRAINS AND FLOOR SINKS FROM ELECTRONIC TRAP PRIMERS.
 - I. PIPING SHOWN ON ENPLANING LEVEL SHEETS DENOTED WITH KEY NOTE B IS LOCATED IN THE CEILING SPACE OF THE DEPLANING LEVEL.

- ## **KEY NOTES** #
1. ROUTE WASTE PIPE WITHIN CHASE/WALL TO PLUMBING FIXTURES.
 2. ROUTE CW PIPING WITHIN CHASE/WALL TO PLUMBING FIXTURES. PROVIDE FULL SIZE WATER HEADER TO LAST FIXTURE.
 3. WATER COOLER SALVAGED FOR REUSE. INSTALL AT ADA REQUIRED ELEVATIONS. SEE DEMO SHEET P1.01 FOR ADDITIONAL INFORMATION. SEE ARCHITECTURAL PLANS FOR EXACT FIXTURE LOCATION.

1 CONOURSE D - SECTOR 2 - D2221, D2222, D2223 - ENPLANING - FLOOR PLAN - PLUMBING
SCALE: 1/4" = 1'-0"

[illegible]

  Port of Portland		 PAE pae-engineers.com 151 SW 1st Avenue #300 Portland, OR 97204			
2025D031 DESIGN NUMBER		103101 PROJECT NUMBER		07/14/2026 EXPIRES: 12/31/2026	

PORTLAND INTERNATIONAL AIRPORT TERMINAL RESTROOM REHABILITATION 2026 CONCOURSE D - ENPLANING - SECTOR 2 - D2221, D2222, D2223 - FLOOR PLAN - PLUMBING	SUBMITTED BY		BRIAN FRANCIS			
	DESIGNED BY		E. WALCZYK			
	DRAWN BY		C. RICHARDS			
	CHECKED BY		T. LEWIS			
	DATE		JULY 2026			
	SHEET NO.		89	TYPE	CD	
	DRAWING NO.			PDX 2026-510	DISC. SHT. NO.	P2.01