




0' 2' 4' 8' 12'

SCALE: IN FEET

CAN YOU SEE THE AIRPLANES? THE ADJACENT SAMPLES SHOW THREE DIFFERENT LEVELS OF SHADING. SETTINGS FOR VIEWING AND PRINTING DRAWING CONTENT ARE OPTIMIZED WHEN ALL THREE PLANES ARE VISIBLE. THIS GUIDANCE IS PROVIDED FOR REFERENCE ONLY.

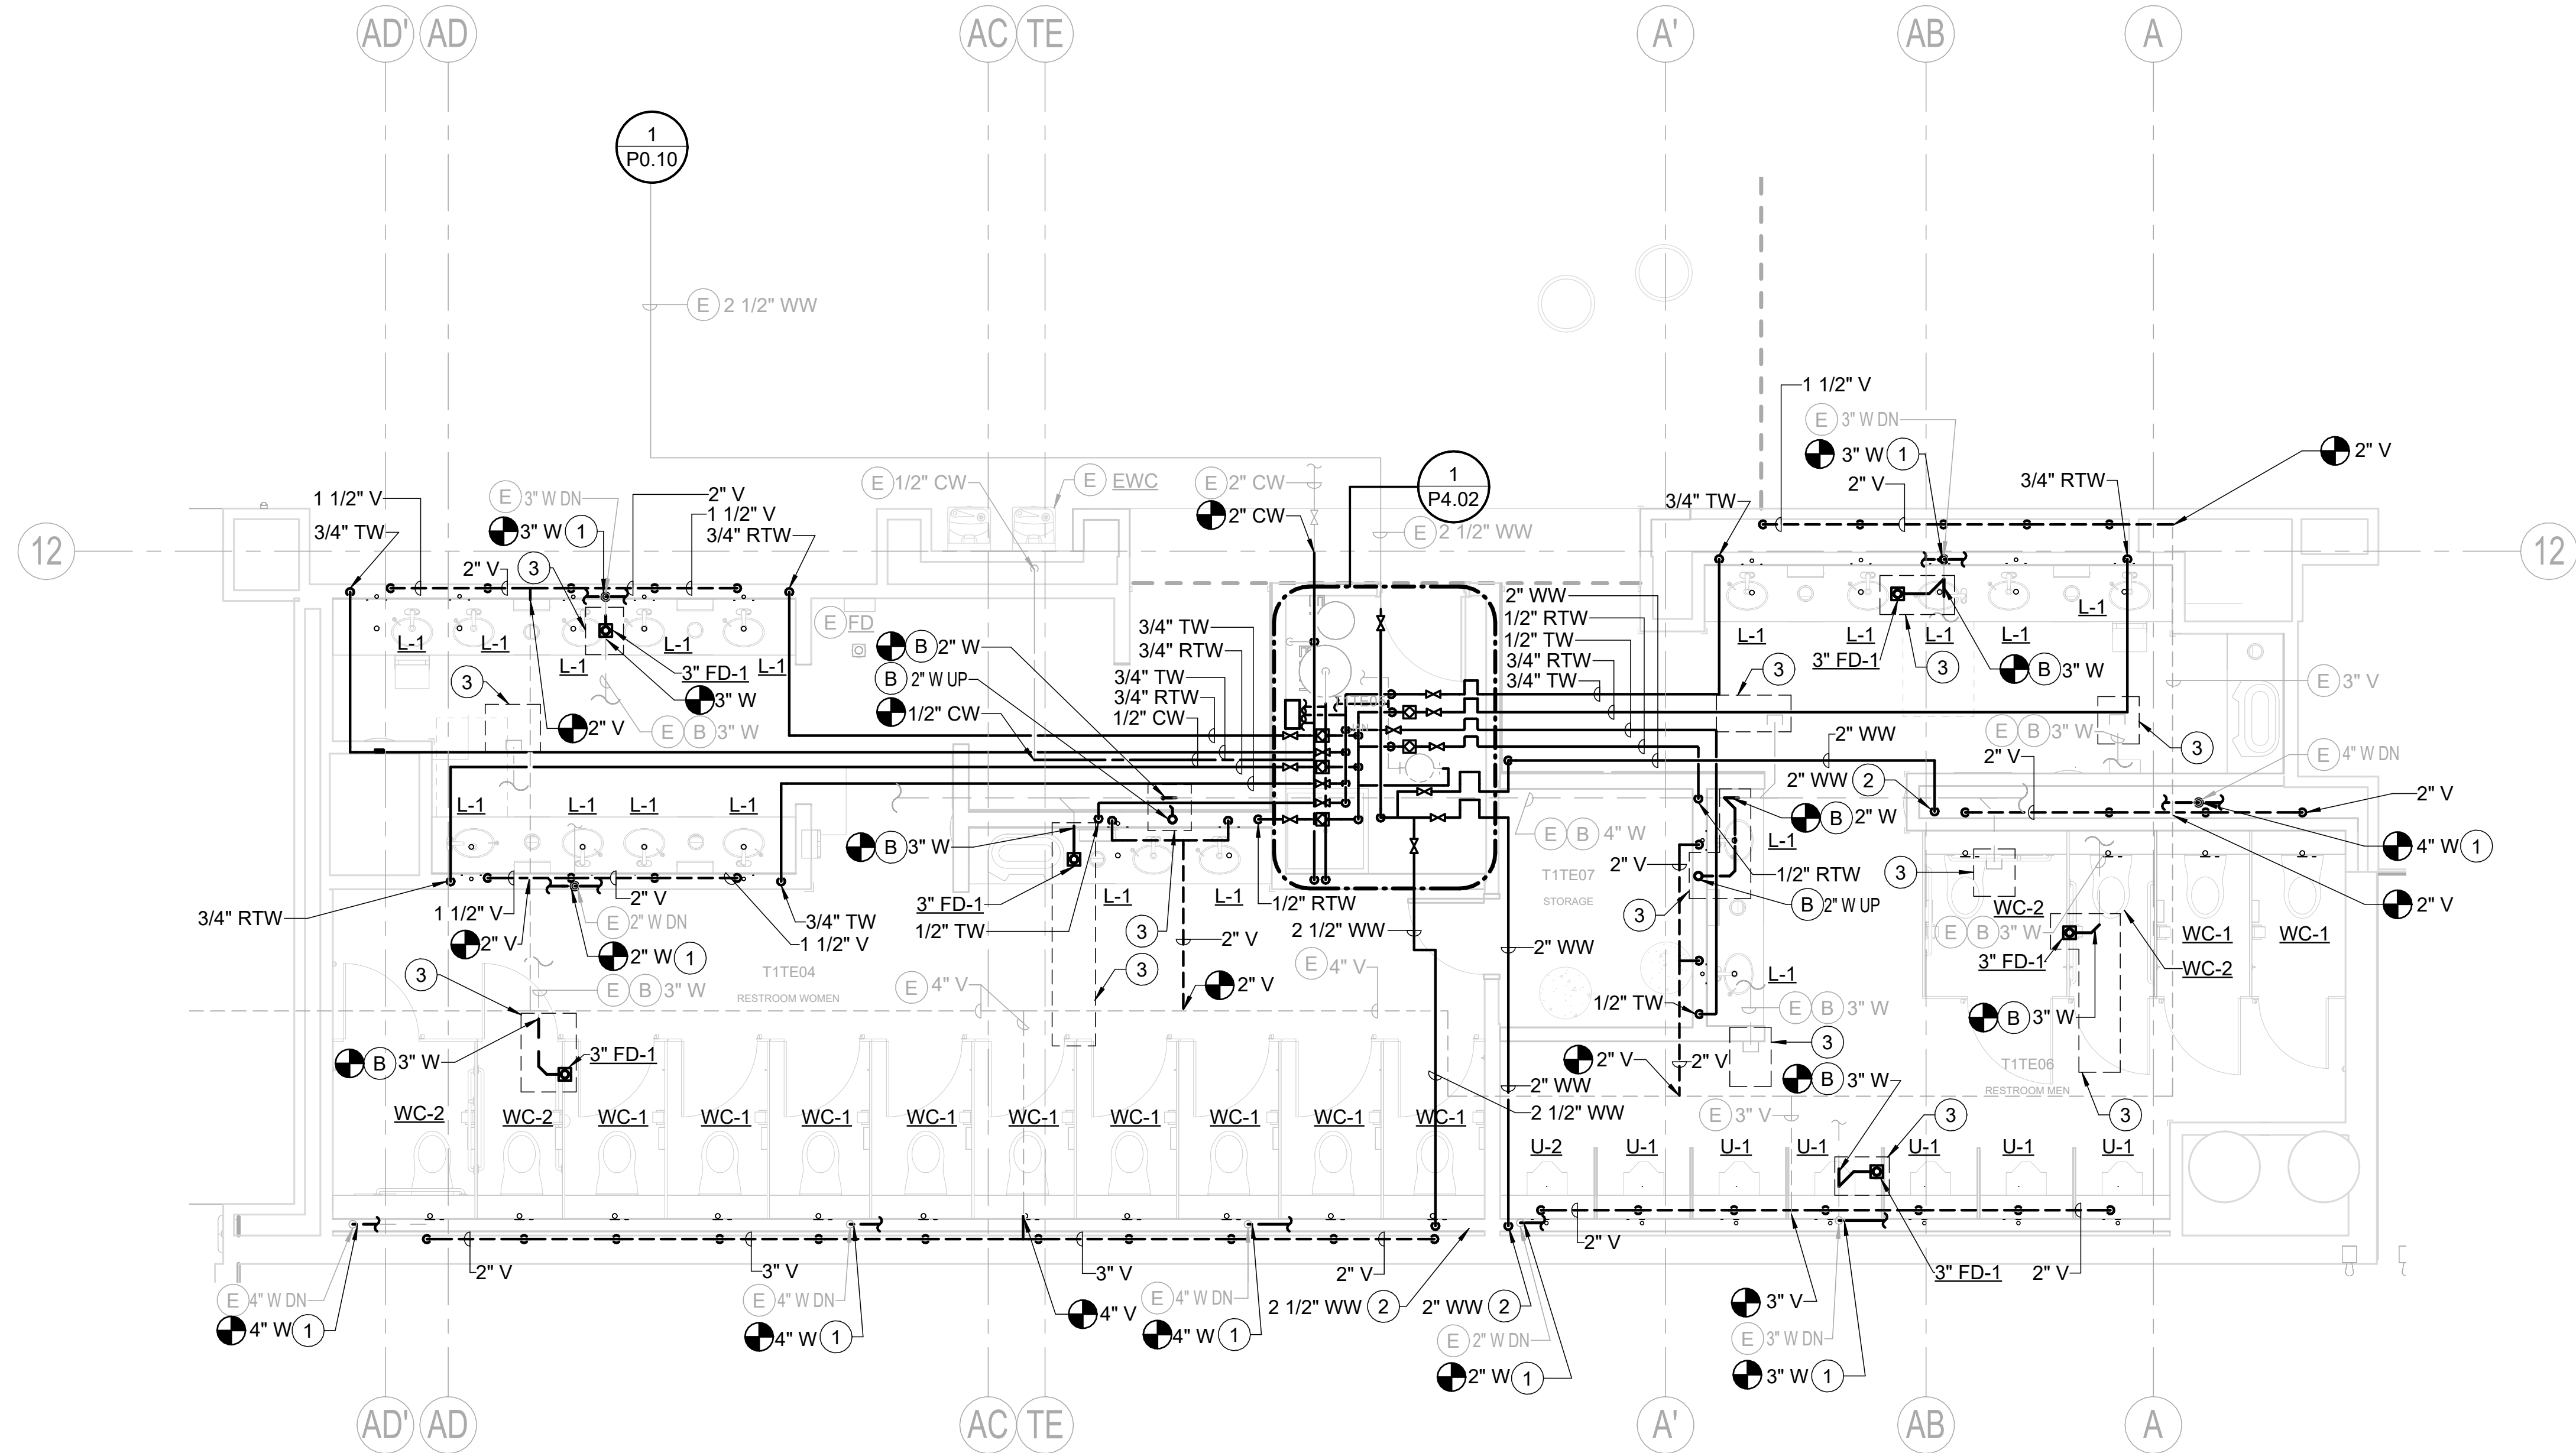


1 TERMINAL - SECTOR E5 - T1TE04, T1TE05, T1TE06, T1TE07 - DEPLANING - FLOOR PLAN - PLUMBING
SCALE: 1/4" = 1'-0"

GENERAL NOTES

- COORDINATE WORK WITH ALL OTHER TRADES.
- VERIFY ALL EQUIPMENT CONNECTIONS WITH THE MANUFACTURERS CERTIFIED DRAWINGS. VERIFY AND PROVIDE TRANSITIONS TO FURNISHED EQUIPMENT. FIELD VERIFY AND COORDINATE ALL DIMENSIONS BEFORE FABRICATION.
- DRAWINGS ARE DIAGRAMMATIC. NOT ALL OFFSETS AND TRANSITIONS IN PIPING ARE SHOWN IN THE DRAWINGS. PROVIDE OFFSETS AND TRANSITIONS REQUIRED FOR INSTALLATION.
- ALL VALVES, WATER HAMMER ARRESTORS, ECT. NEED TO BE INSTALLED IN READILY ACCESSIBLE LOCATIONS.
- EXISTING WORK SHOWN IS EXISTING TO REMAIN UNLESS NOTED OTHERWISE.
- VERIFY EXACT SIZES, LOCATIONS, INVERTS AND ELEVATIONS PRIOR TO RUNNING ANY PIPING. REFER TO ARCHITECTURAL DRAWINGS FOR EXACT LOCATIONS OF ALL FIXTURES AND EQUIPMENT.
- PROVIDE WATER HAMMER ARRESTORS BEHIND ACCESS PANEL FOR URINAL BANKS AND BEHIND TOILET SEAT COVER DISPENSER FOR WATER CLOSETS. SIZE AND LOCATE WATER HAMMER ARRESTORS PER PDI STANDARDS.
- TRAP PRIMING SHALL BE PROVIDED FOR ALL FLOOR DRAINS AND FLOOR SINKS FROM ELECTRONIC TRAP PRIMERS.
- PIPING SHOWN ON DEPLANING LEVEL SHEETS DENOTED WITH KEY NOTE B IS LOCATED BELOW GRADE.

KEY NOTES

- ROUTE WASTE PIPE WITHIN CHASE/WALL TO PLUMBING FIXTURES.
- ROUTE WW PIPING WITHIN CHASE/WALL TO PLUMBING FIXTURES. PROVIDE FULL SIZE WATER HEADER TO LAST FIXTURE.
- EXTENT OF SAW CUTTING REQUIRED TO INSTALL UNDERGROUND PLUMBING OR CAP EXISTING UNDERGROUND PLUMBING. FIELD VERIFY. SEE ARCHITECTURAL AND STRUCTURAL DRAWINGS FOR CONCRETE REPAIR AND FINISH REQUIREMENTS.

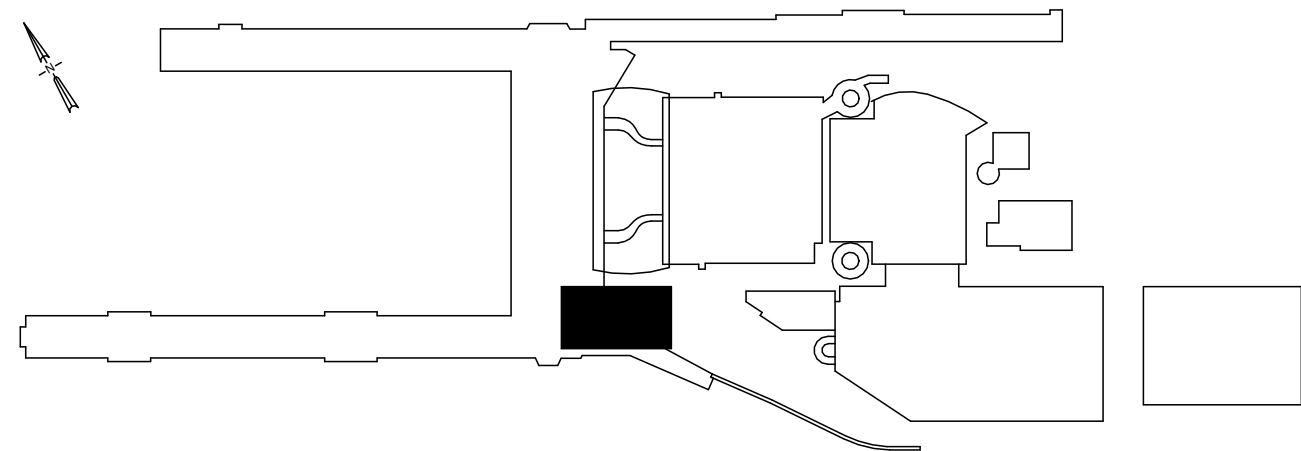

Port of Portland



mwa architects

PAE pae-engineers.com

151 SW 1st Avenue #300
Portland, OR 97204 503.226.2921
pae-engineers.com



PORTLAND INTERNATIONAL AIRPORT

TERMINAL RESTROOM REHABILITATION 2026

TERMINAL - DEPLANING - SECTOR E5 - T1TE04, T1TE05, T1TE06, T1TE07 - FLOOR
PLAN - PLUMBING

SUBMITTED BY	BRIAN FRANCIS
DESIGNED BY	E. WALCZYK
DRAWN BY	C. RICHARDS
CHECKED BY	T. LEWIS
DATE	JULY 2026
SHEET NO.	91
TYPE	CD
DRAWING NO.	PDX 2026-510
DISC. SHT. NO.	P2.03