




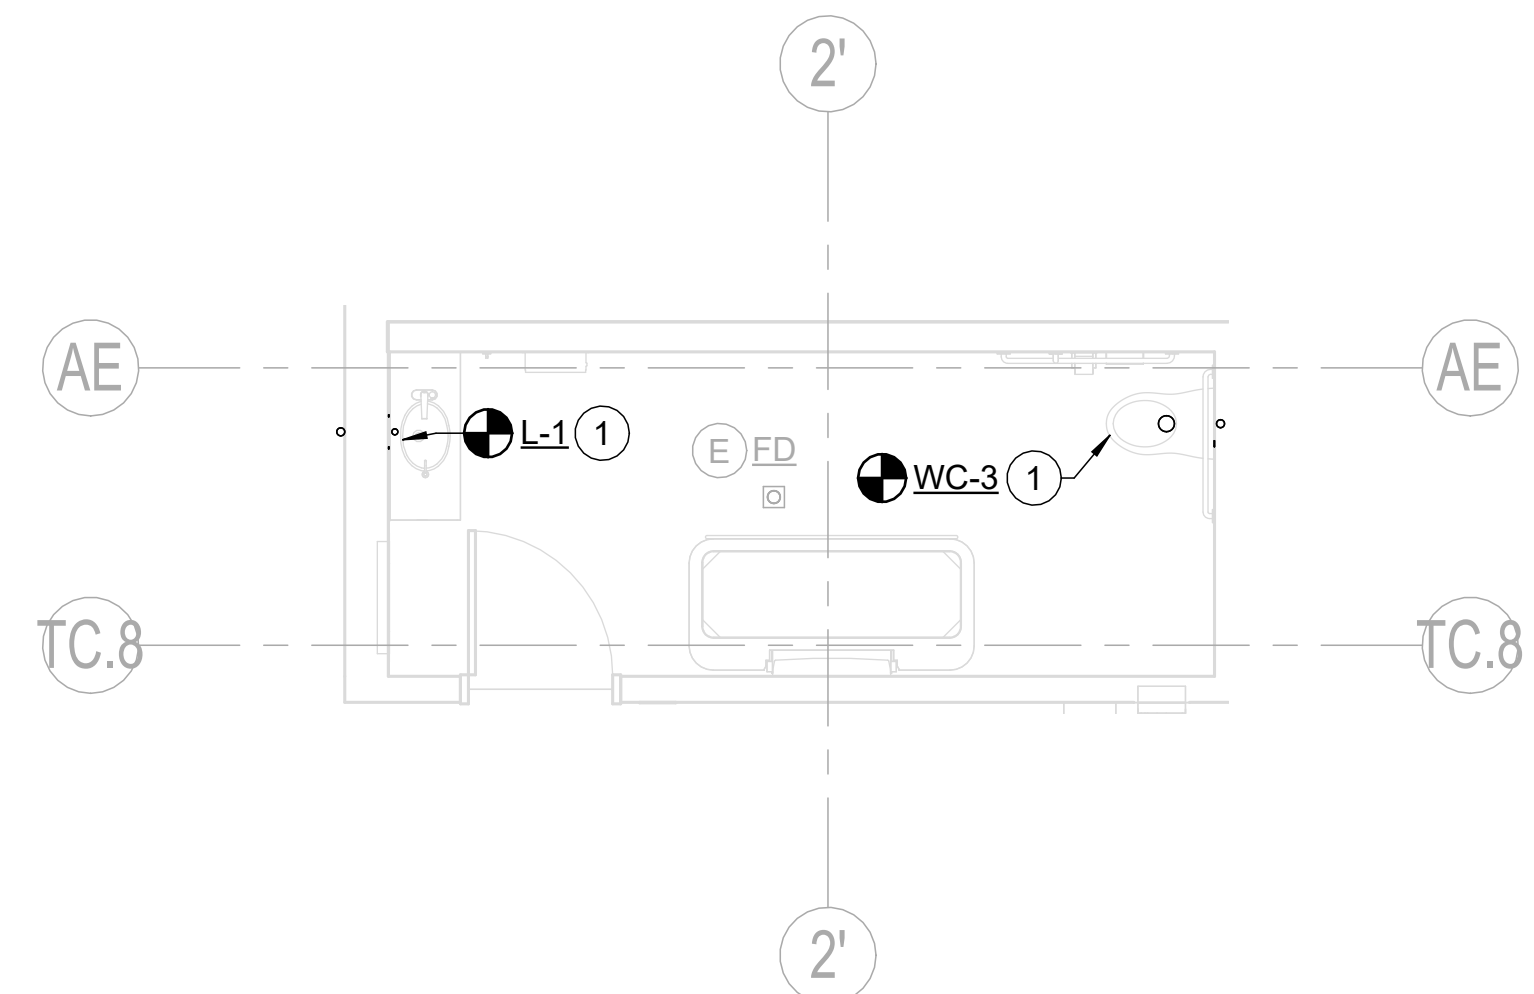


CAN YOU SEE THE AIRPLANES? THE ADJACENT SAMPLES SHOW THREE DIFFERENT LEVELS OF SHADING. SETTINGS FOR VIEWING AND PRINTING DRAWING CONTENT ARE OPTIMIZED WHEN ALL THREE PLANES ARE VISIBLE. THIS GUIDANCE IS PROVIDED FOR REFERENCE ONLY.

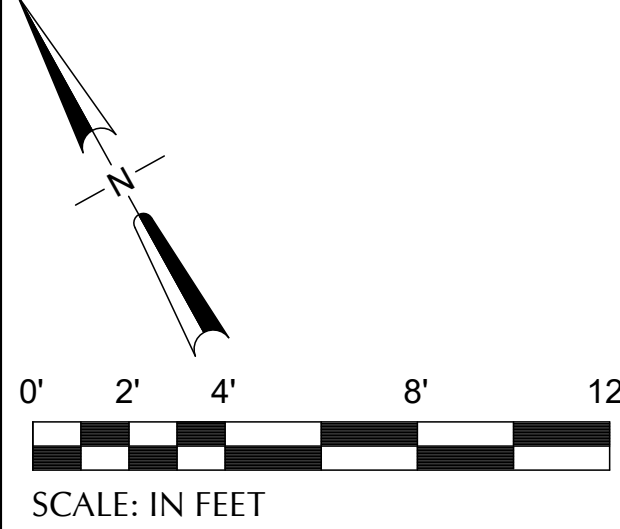


1 TERMINAL - SECTOR W5 - T2TC66 - ENPLANING - FLOOR PLAN - PLUMBING
SCALE: 1/4" = 1'-0"

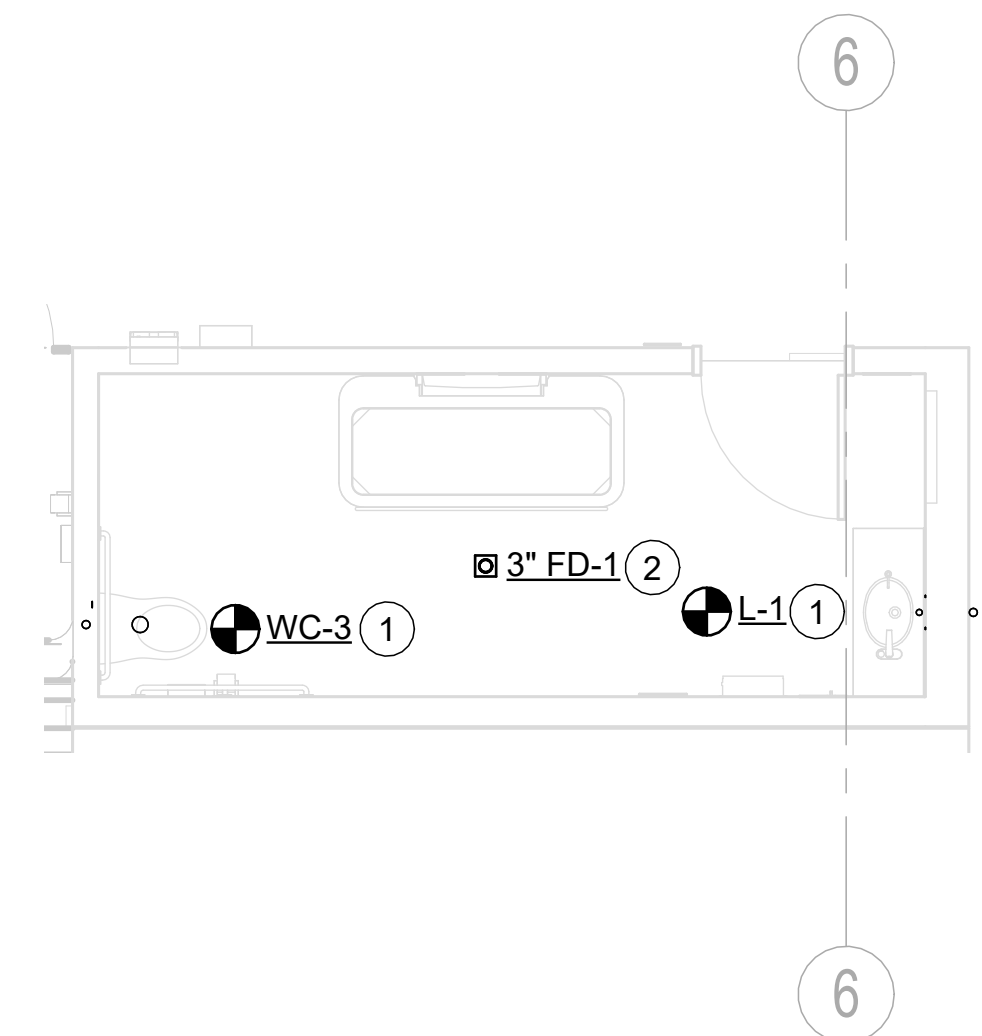

2 TERMINAL - SECTOR E5 - T2TD44 - ENPLANING - FLOOR PLAN - PLUMBING
SCALE: 1/4" = 1'-0"

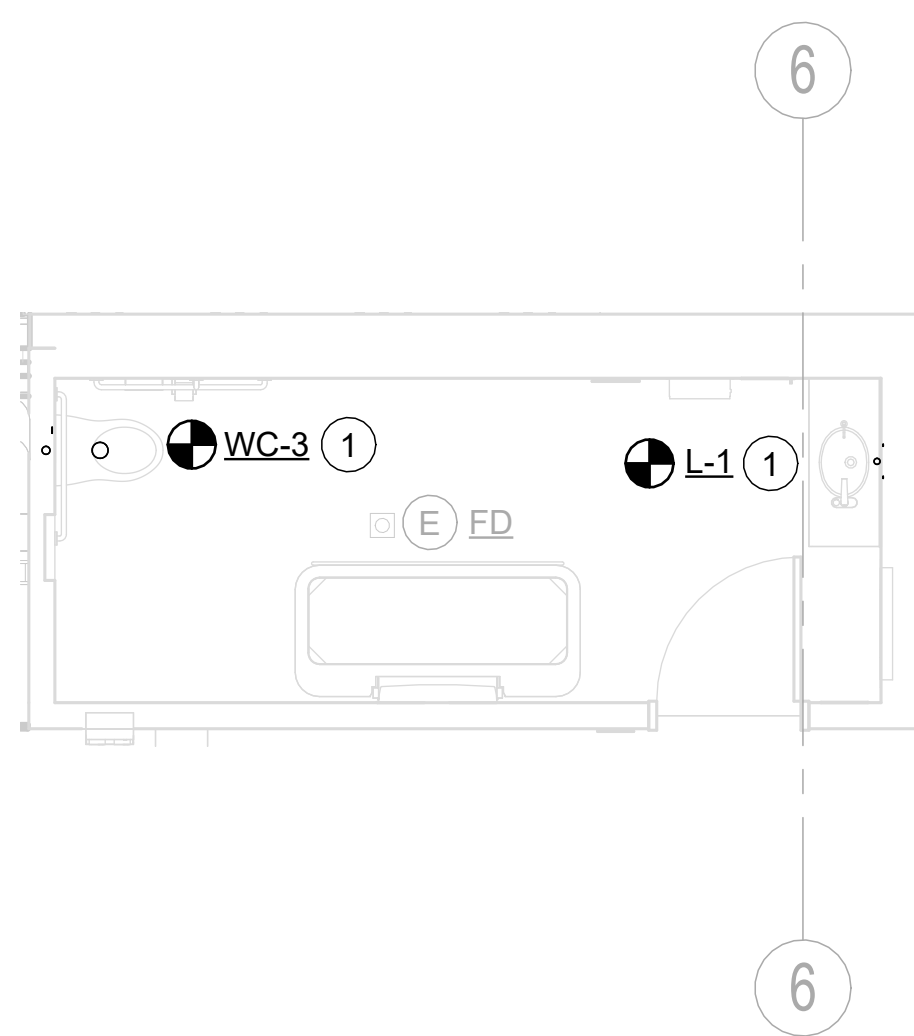

3 TERMINAL - SECTOR E2 - T2TQ48 - ENPLANING - FLOOR PLAN - PLUMBING
SCALE: 1/4" = 1'-0"

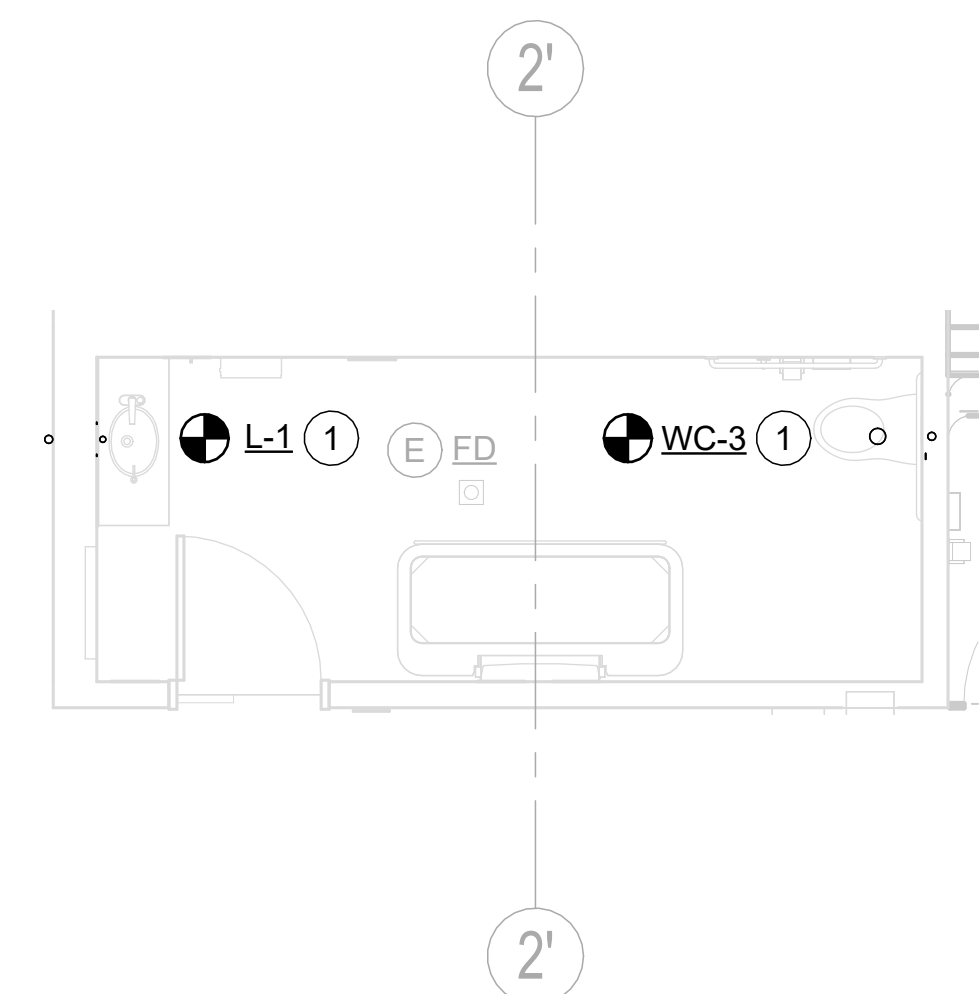


4 TERMINAL - SECTOR W - T2TQ66 - ENPLANING - FLOOR PLAN - PLUMBING
SCALE: 1/4" = 1'-0"

GENERAL NOTES

- A. COORDINATE WORK WITH ALL OTHER TRADES.
- B. VERIFY ALL EQUIPMENT CONNECTIONS WITH THE MANUFACTURERS CERTIFIED DRAWINGS. VERIFY AND PROVIDE TRANSITIONS TO FURNISHED EQUIPMENT. FIELD VERIFY AND COORDINATE ALL DIMENSIONS BEFORE FABRICATION.
- C. DRAWINGS ARE DIAGRAMMATIC. NOT ALL OFFSETS AND TRANSITIONS IN PIPING ARE SHOWN IN THE DRAWINGS. PROVIDE OFFSETS AND TRANSITIONS REQUIRED FOR INSTALLATION.
- D. ALL VALVES, WATER HAMMER ARRESTORS, ECT. NEED TO BE INSTALLED IN READILY ACCESSIBLE LOCATIONS.
- E. EXISTING WORK SHOWN IS EXISTING TO REMAIN UNLESS NOTED OTHERWISE.
- F. VERIFY EXACT SIZES, LOCATIONS, INVERTS AND ELEVATIONS PRIOR TO RUNNING ANY PIPING. REFER TO ARCHITECTURAL DRAWINGS FOR EXACT LOCATIONS OF ALL FIXTURES AND EQUIPMENT.
- G. PROVIDE WATER HAMMER ARRESTORS BEHIND ACCESS PANEL FOR URINAL BANKS AND BEHIND TOILET SEAT COVER DISPENSER FOR WATER CLOSETS. SIZE AND LOCATE WATER HAMMER ARRESTORS PER PDI STANDARDS.
- H. TRAP PRIMING SHALL BE PROVIDED FOR ALL FLOOR DRAINS AND FLOOR SINKS FROM ELECTRONIC TRAP PRIMERS.

KEY NOTES #

- 1. ROUGH-INS FOR FIXTURES ARE EXISTING FROM TCORE PROJECT. ATTACH NEW FIXTURES TO EXISTING ROUGH-INS. PROVIDE CLEAN-OUT COVERS FOR EXISTING CLEAN-OUTS.
- 2. TIE INTO EXISTING BELOW GRADE WASTE. CONNECT TRAP PRIMER LINE TO EXISTING TRAP PRIMER INSTALLED DURING TCORE RENOVATIONS. TRAP PRIMER LOCATED IN JAN T2TC43.

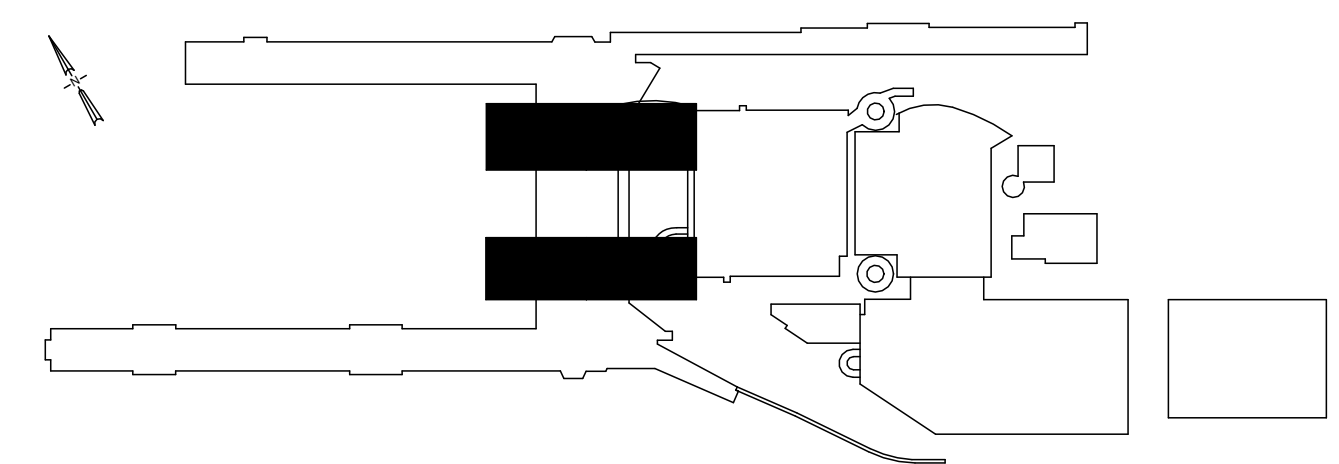

DRAWING SCALE IS REDUCED 50% WHEN SHEET SIZE IS 11" x 17".
0 1/4" = 1'-0"
GRAPHIC SCALE FOR REFERENCE ONLY

NO.	DATE	BY	REVISIONS	APP.





pae-engineers.com
151 SW 1st Avenue #300
Portland, OR 97204
503.226.2921
pae-engineers.com

2025D031
DESIGN NUMBER

103101
PROJECT NUMBER



PORTLAND INTERNATIONAL AIRPORT	
TERMINAL RESTROOM REHABILITATION 2026	
TERMINAL - ENPLANING - SECTOR W5, E2 & E5 - FLOOR PLAN - PLUMBING	

SUBMITTED BY	BRIAN FRANCIS	
DESIGNED BY	E. WALCZYK	
DRAWN BY	C. RICHARDS	
CHECKED BY	T. LEWIS	
DATE	JULY 2026	
SHEET NO.	92	TYPE CD
DRAWING NO.	PDX 2026-510	
DISC. SHT. NO.	P2.04	