
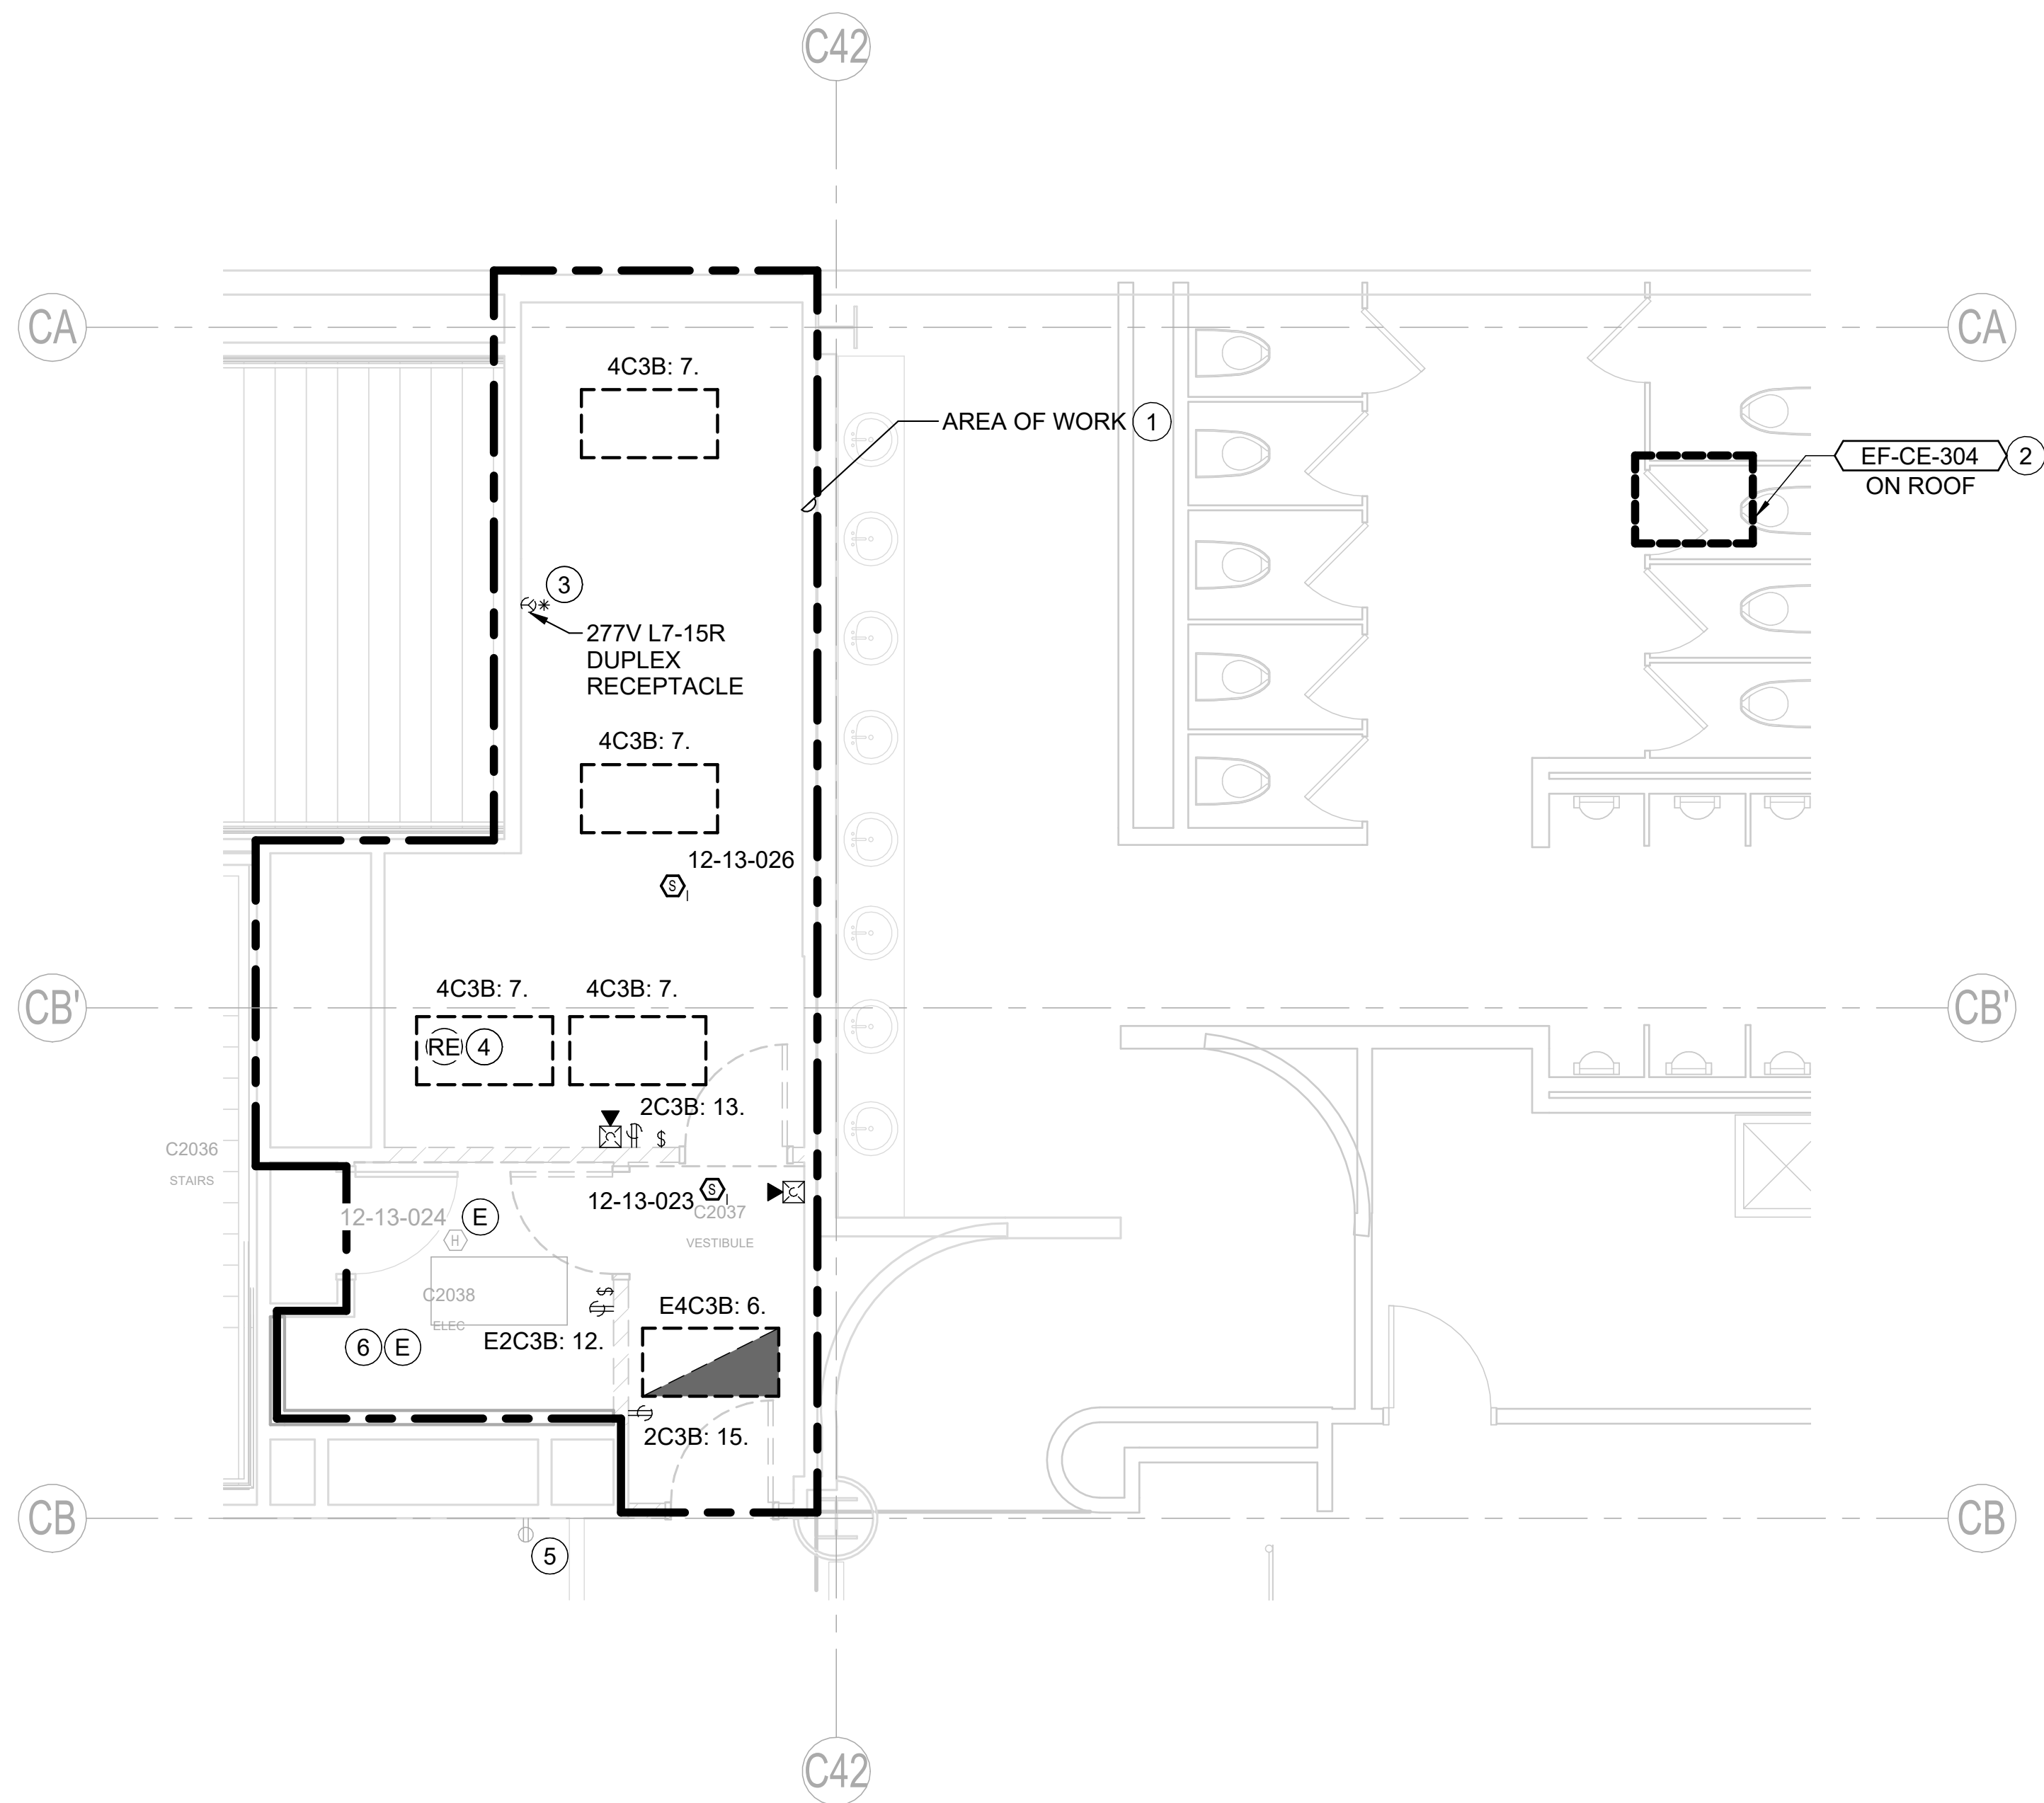


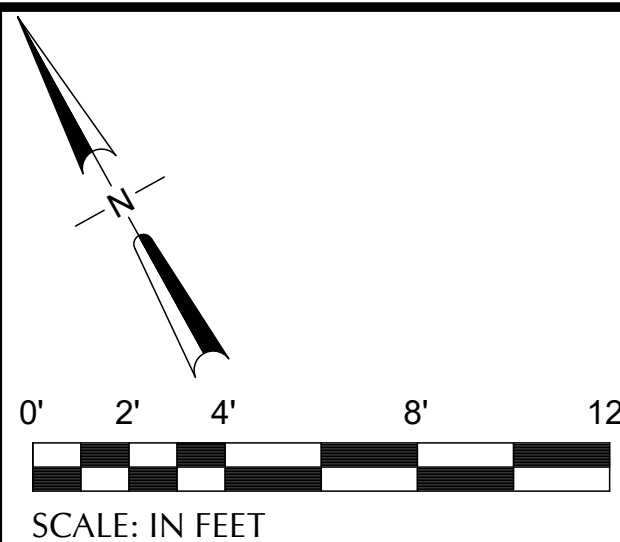


NOTES

1. LOCATIONS SHOWN FOR DEVICES, EQUIPMENT, LUMINARIES AND ENCLOSURE ARE DIAGRAMMATIC AND INFORMATION HAS BEEN DETERMINED FROM AS-BUILT DOCUMENTS AND SITE OBSERVATIONS. CONTRACTOR TO FIELD VERIFY DURING PRE-BID WALK AND IDENTIFY COMPLETE SOW FOR DEMOLITION.
2. ALL RECEPTACLES, EQUIPMENT, LUMINARIES AND DEVICES ARE TO BE REMOVED IN AREA OF WORK UNLESS OTHERWISE NOTED.
3. WHERE DEMOLITION IS SPECIFICALLY NOTED: THAT EQUIPMENT, DEVICE, LUMINAIRE, ETC AND IT'S BRANCH CIRCUIT SHALL BE REMOVED IN ITS ENTIRETY BACK TO THE PANEL OR LAST ACTIVE UPSTREAM DEVICE UNLESS OTHERWISE NOTED. PROVIDE CONDUIT AND CONDUCTORS TO MAINTAIN CONNECTION TO ALL DOWNSTREAM DEVICES THAT REMAIN.
4. MAINTAIN THE INTEGRITY OF ALL BRANCH CIRCUITS, FEEDERS, ENERGIZED EQUIPMENT, ETC THAT ROUTE THROUGH DEMOLITION AREAS AND SERVE EQUIPMENT TO REMAIN.

KEY NOTES

1. DEMOLISH EXISTING LIGHT FIXTURES AND RECEPTACLES AND ASSOCIATED CIRCUITING. EXISTING BRANCH CIRCUITS FOR LIGHTING ARE TO REMAIN FOR REUSE.
2. DISCONNECT EXHAUST FAN AND SAVE BRANCH CIRCUIT FOR REUSE.
3. DEMOLISH RECEPTACLE. CONTRACTOR TO IDENTIFY SOURCE PANEL AND CIRCUIT AND MARK THE CIRCUIT AS SPARE IF NO ACTIVE CONNECTION REMAIN. UPDATE PANEL SCHEDULE IN AS BUILT DRAWINGS FOR RECORD DOCUMENTS.
4. RELOCATE EXISTING LIGHT TO NEW LOCATION SHOWN ON SHEET E2.00. CONNECT TO EXISTING SWITCH IN ROOM.
5. DISCONNECT EXISTING SMARTER CARTE KIOSK. EXISTING RECEPTACLE TO REMAIN. COORDINATE WITH PORT FOR TEMPORARY LOCATION.
6. DISCONNECT EXISTING SWITCH LEG FOR DEMOLITION OF SWITCH - SEE E2.00 FOR NEW CONTROL

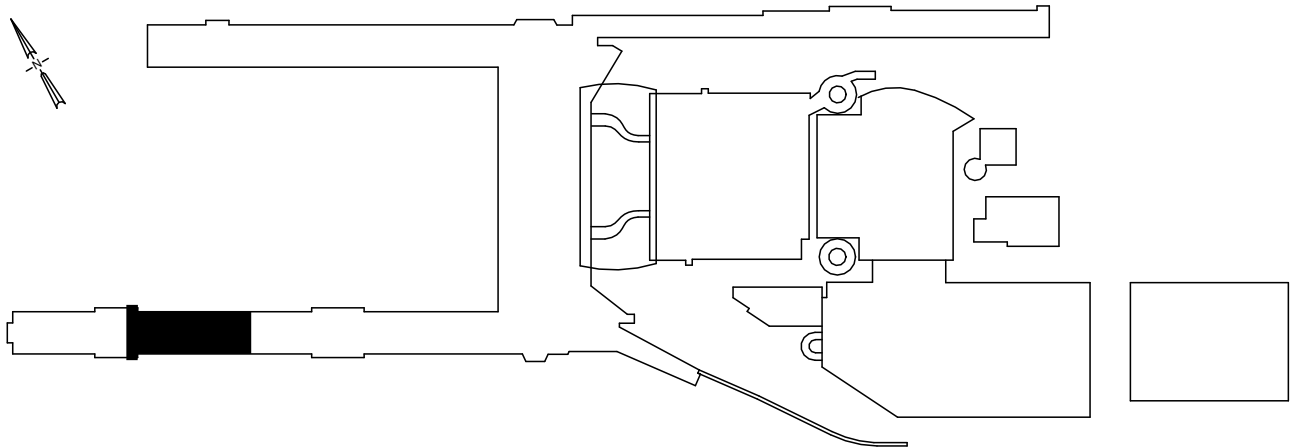

1 CONOURSE C - SECTOR 5 - C2039 - ENPLANING - DEMO PLAN - ELECTRICAL
SCALE: 1/4" = 1'-0"

[illegible]

 Port of Portland	
 mwa architects	 PAE pae-engineers.com 503.226.2921 pae-engineers.com 151 SW 1st Avenue #300 Portland, OR 97204 503.226.2921 pae-engineers.com
2025D031 103101 DESIGN NUMBER PROJECT NUMBER	103101 103101 PROJECT NUMBER PROJECT NUMBER



PORTLAND INTERNATIONAL AIRPORT
 TERMINAL RESTROOM REHABILITATION 2026
 CONCOURSE C - ENPLANING - SECTOR 5 - C2039 - DEMO PLAN - ELECTRICAL

SUBMITTED BY	BRIAN FRANCIS		
DESIGNED BY	A. NGUYEN		
DRAWN BY	A. NGUYEN		
CHECKED BY	J. MUTSCHLER		
DATE	JULY 2026		
SHEET NO.	117	TYPE	CD
DRAWING NO.	PDX 2026-510		DISC. SHT. NO. E1.00