
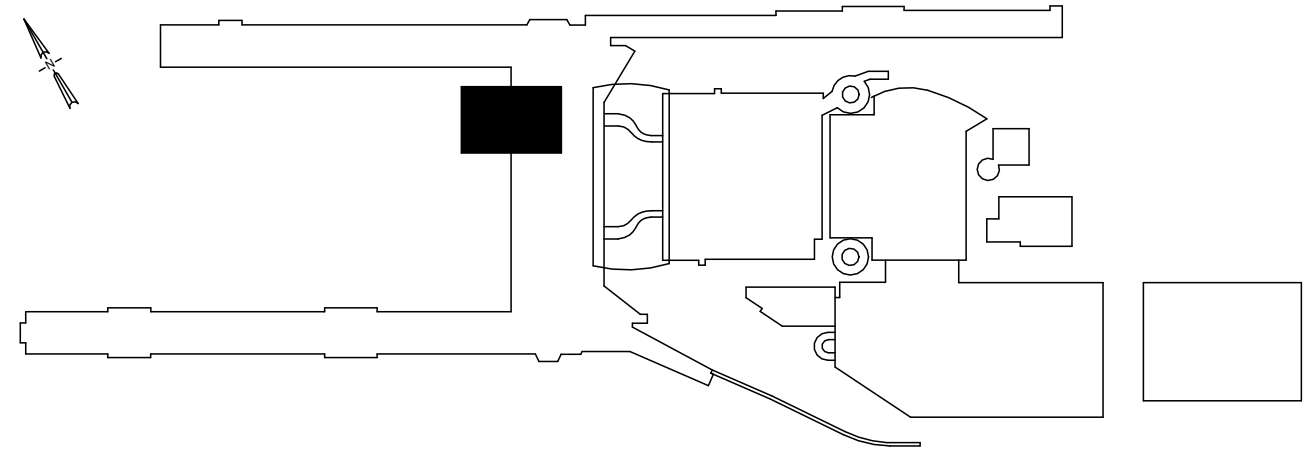


DRAWING SCALE IS REDUCED 50% WHEN SHEET SIZE IS 11" x 17"

0 1/4" 1/2" 1" 2"

GRAPHIC SCALE: FOR REFERENCE ONLY

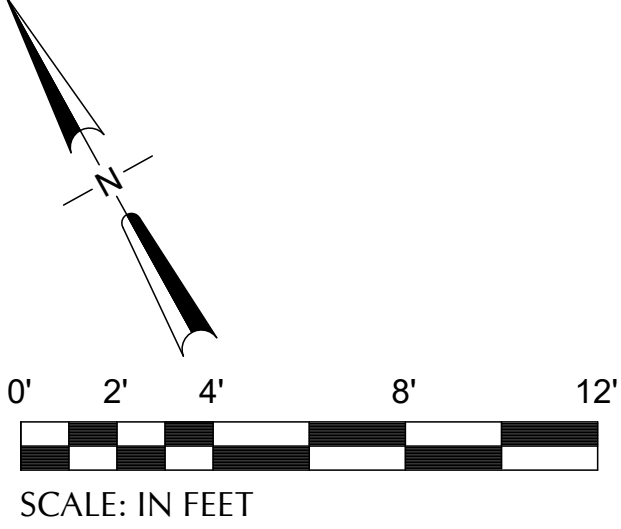

KEY NOTES

1. PROVIDE DUPLEX RECEPTACLE FOR EACH TOWEL DISPENSER. LOCATE RECEPTACLE DIRECTLY ABOVE EACH DISPENSER BEHIND REMOVABLE WALL PANEL ABOVE MIRROR. PROVIDE CONDUIT IN WALL TO ROUTE CONNECTION TO DISPENSER.

1 TERMINAL - SECTOR W - T2TQ66 - ENPLANING - FLOOR PLAN - ELECTRICAL
SCALE: 1/4" = 1'-0"

[illegible]

Port of Portland		
mwa architects	pae-engineers.com 151 SW 1st Avenue #300 Portland, OR 97204 503.226.2921 pae-engineers.com	
2025D031 103101 DESIGN NUMBER PROJECT NUMBER	7/14/26 EXPIRES: 12/31/2026	

PORTLAND INTERNATIONAL AIRPORT

TERMINAL RESTROOM REHABILITATION 2026

TERMINAL - ENPLANING - SECTOR W - T2TQ66 - FLOOR PLAN - ELECTRICAL

SUBMITTED BY	BRIAN FRANCIS		
DESIGNED BY	A. NGUYEN		
DRAWN BY	A. NGUYEN		
CHECKED BY	J. MUTSCHLER		
DATE	JULY 2026		
SHEET NO.	138	TYPE	CD
DRAWING NO.		DISC. SHT. NO.	
PDX 2026-510		E3.07	