


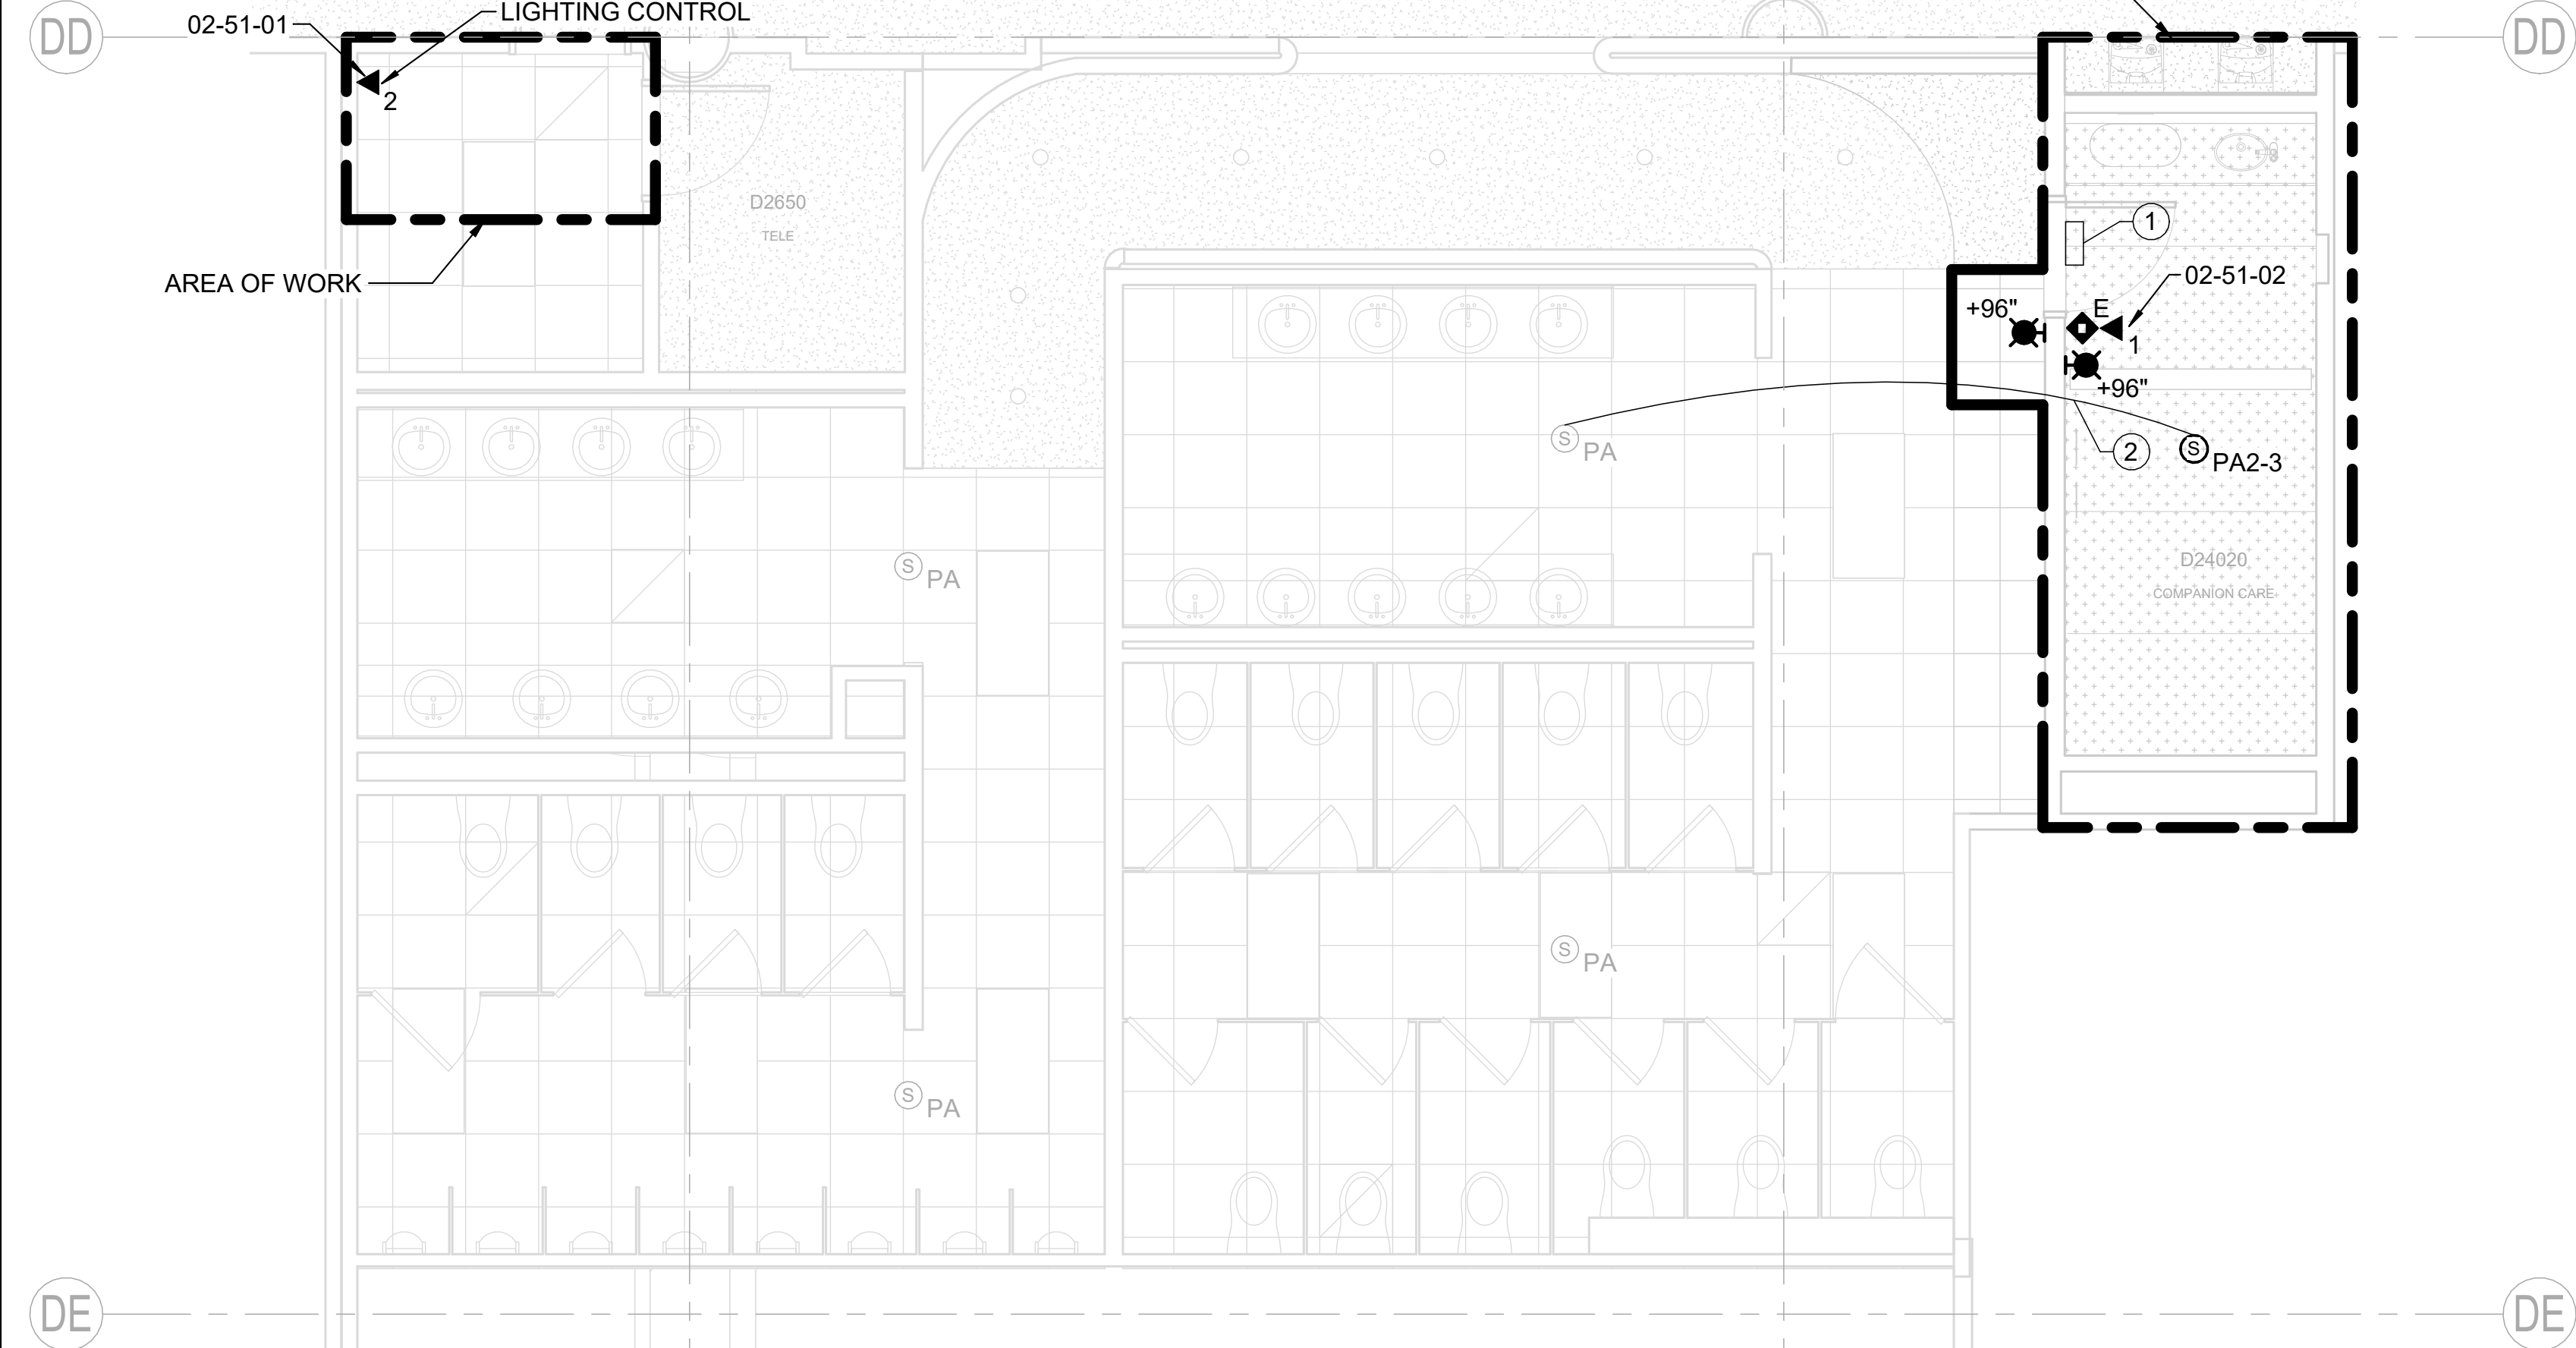

- ## **KEY NOTES** (#)
1. ABOVE CEILING EMERGENCY PHONE
BLUE LIGHT POWER SUPPLY
ENCLOSURE. REFER TO T6.02, DETAIL 1
FOR CIRCUITING REQUIREMENTS.
 2. CONNECT EXISTING PAGING SPEAKER
TO NEW PAGING CIRCUIT. REMOVE
EXISTING CIRCUIT CONNECTIONS AS
REQUIRED AND PROVIDE ALL NEW
CABLING, SPLICES, AND
TERMINATIONS.

1 CONCURSE D - SECTOR 3 - D24020 - ENPLANING - CEILING PLAN - TECHNOLOGY
SCALE: 1/4" = 1'-0"

[illegible]

 Port of Portland	
 mwa architects	 PAE pae-engineers.com 151 SW 1st Avenue #300 Portland, OR 97204 503.226.2921 pae-engineers.com
2025D031 DESIGN NUMBER	103101 PROJECT NUMBER



PORTLAND INTERNATIONAL AIRPORT
TERMINAL RESTROOM REHABILITATION 2026
CONCOURSE D - ENPLANING - SECTOR 3 - D24020 - FLOOR PLAN - TECHNOLOGY

SUBMITTED BY	BRIAN FRANCIS		
DESIGNED BY	A. PULVER		
DRAWN BY	B. PARTHEMER		
CHECKED BY	R. LALUM		
DATE	JULY 2026		
SHEET NO.	179	TYPE	CD
DRAWING NO.		DISC. SHT. NO.	
PDX 2026-510		T2.02	

