
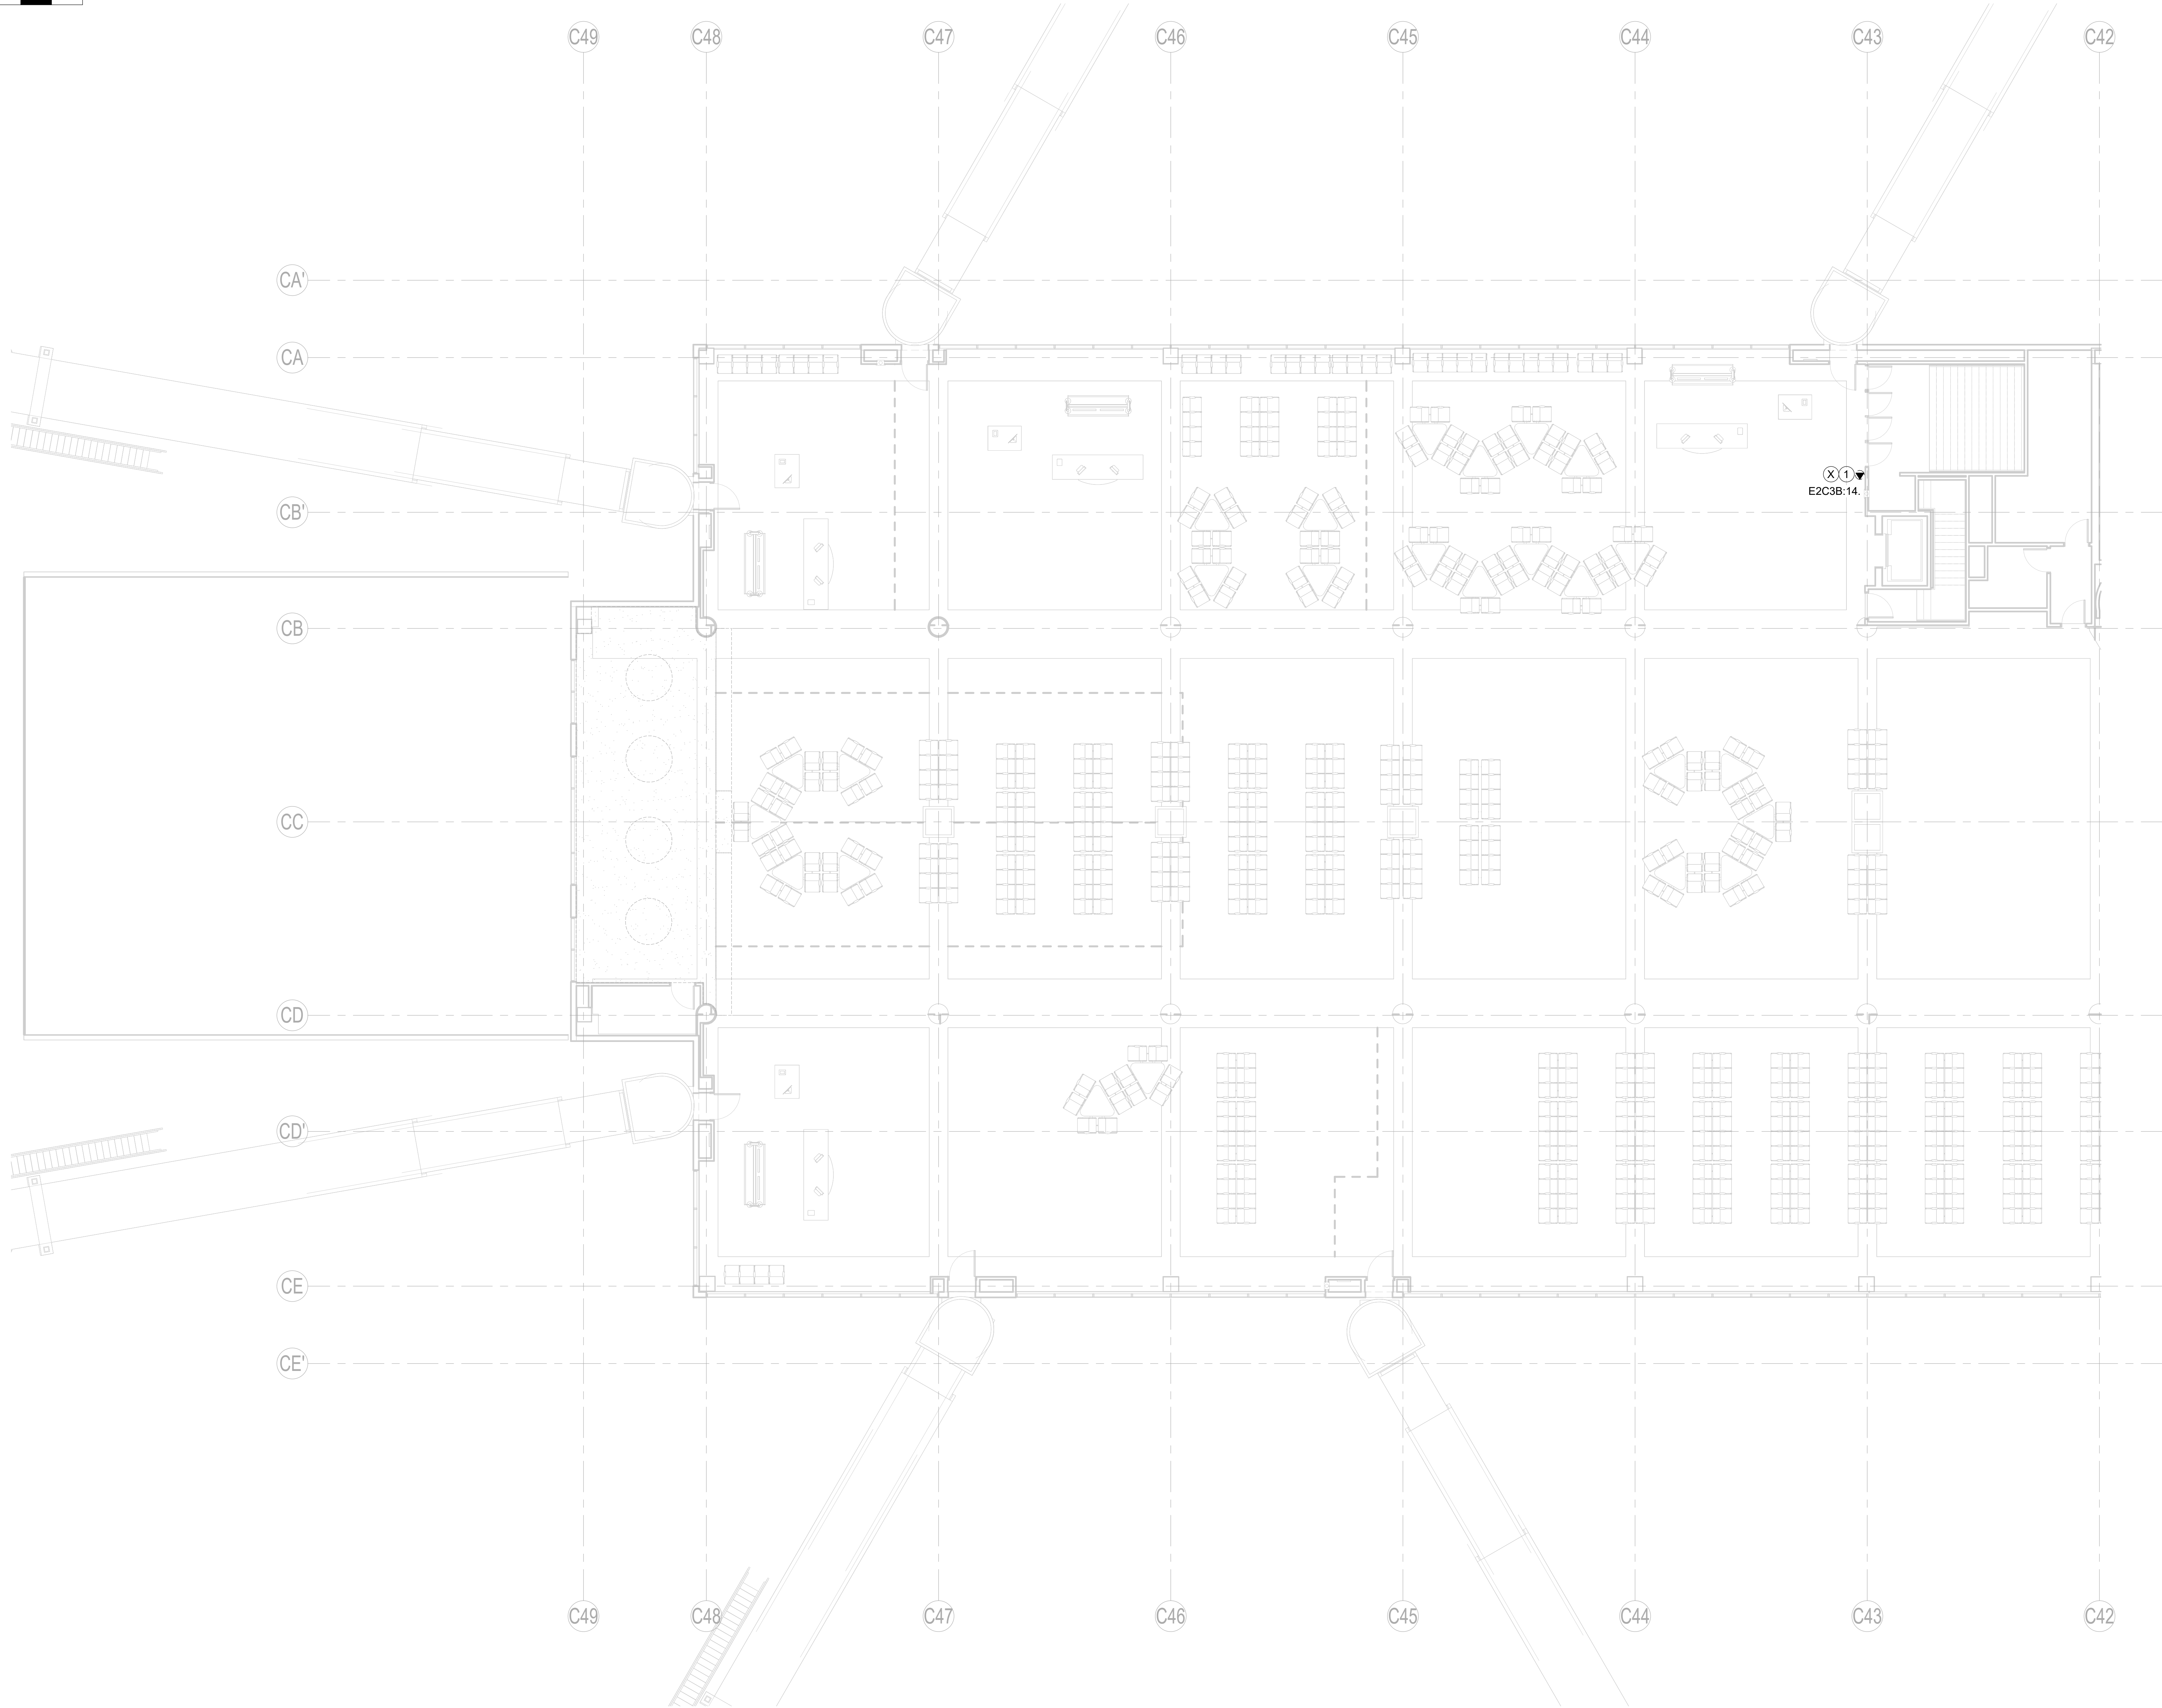



CAN YOU SEE THE AIRPLANES? THE ADJACENT SAMPLES SHOW THREE DIFFERENT LEVELS OF SHADING SETTINGS FOR VIEWING AND PRINTING CONTENT ARE OPTIMIZED WHEN ALL THREE PLANES ARE VISIBLE. THIS GUIDANCE IS PROVIDED FOR REFERENCE ONLY.

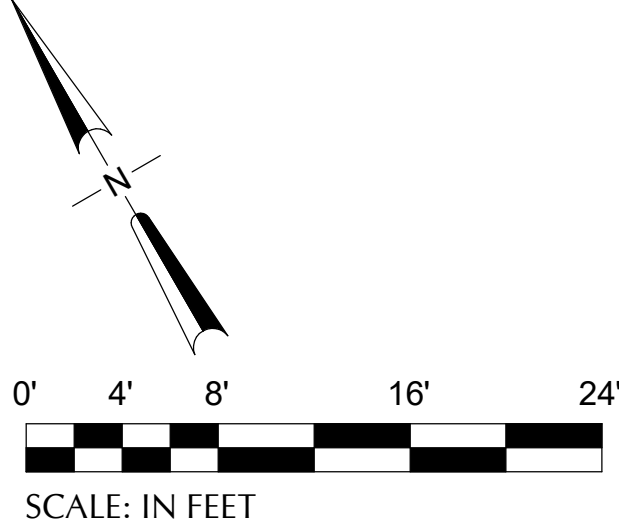

KEYNOTE(S) #:

1. DISCONNECT EXISTING AREA OF RESCUE SIGN. DEMOLISH CIRCUIT BACK TO SOURCE OR LAST UPSTREAM DEVICE. ABANDON CONCEALED CONDUIT AND PROVIDE BLANK COVER PLATE FOR JUNCTION BOX.

1 CONCURSE C - ENPLANING - SECTOR 70 - DEMOLITION FLOOR PLAN - ELECTRICAL
SCALE: 1/8" = 1'-0"

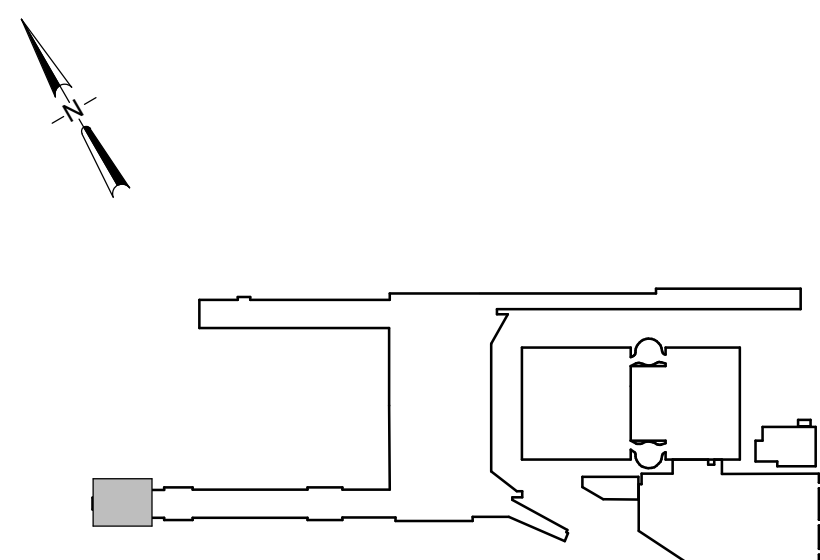

KEY PLAN
SCALE: N.T.S.
