


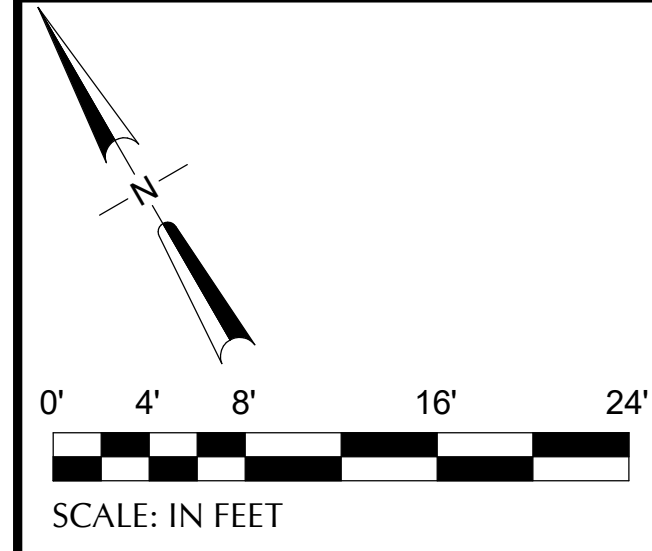


NOTE(S):

1. REFER TO TYPICAL DMX GATEWAY AND DIMMING MODULE DIAGRAM ON E5.001.

KEYNOTE(S) #:

1. DMX GATEWAY WITH (4) DMX CONTROL CIRCUIT CAPACITY AND POWER SUPPLY IN DIN CABINET. PROVIDE TOGGLE SWITCH FOR LOCAL POWER DISCONNECT
2. UTILIZE EXISTING SHAFT TO ROUTE (4) DMX CONTROL CIRCUITS UP TO ENPLANING LEVEL.

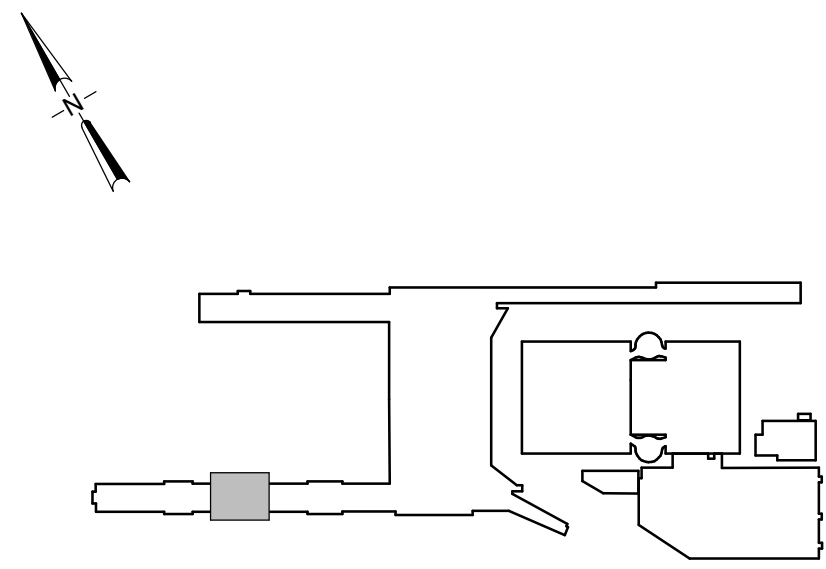

1 CONOURSE C - DEPLANING - SECTOR 72 - FLOOR PLAN - ELECTRICAL
SCALE: 1/8" = 1'-0"

 Port of Portland		
 dbc architecture  PAE pae-engineers.com		
2005 se 11th ave #328 portland, or 97205	503.504.1230 dbcarch@dbc.us	151 50th NW Avenue #300 Portland, OR 97204
20260004	103101	EXPIRES: 12/31/2025

IF ELECTRONIC SIGNATURE IS BROKEN OR MISSING - THIS IS NOT A LEGAL DRAWING

PORTLAND INTERNATIONAL AIRPORT

TERMINAL AND CONCOURSES WAYFINDING SIGNAGE

CONCOURSE C - DEPLANING - SECTOR 72 - FLOOR PLAN - ELECTRICAL

SUBMITTED BY	JAY OSTLUND	
DESIGNED BY	D. PEEK	
DRAWN BY	P. MARKS	
CHECKED BY	G. PARTHEMER	
DATE	AUGUST 2026	
SHEET NO.	59	TYPE CD
DRAWING NO.	PDX 2026-512	DISC. SHT. NO. E2.172

KEY PLAN
SCALE: N.T.S.