
 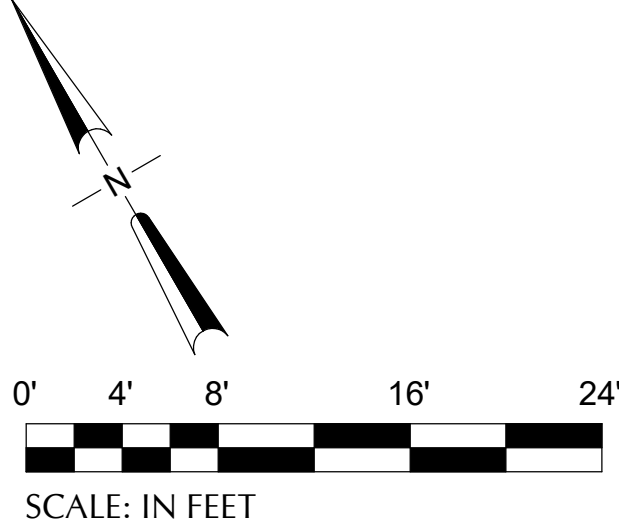


CAN YOU SEE THE AIRPLANES? THE ADJACENT SAMPLES SHOW THREE DIFFERENT LEVELS OF SHADING SETTINGS FOR VIEWING AND PRINTING CONTENT ARE OPTIMIZED WHEN ALL THREE PLANES ARE VISIBLE. THIS GUIDANCE IS PROVIDED FOR REFERENCE ONLY.




SCALE: IN FEET

NOTE(S):

1. REFER TO TYPICAL DMX GATEWAY AND DIMMING MODULE DIAGRAM ON E5.001.

KEYNOTE(S):

1. DMX GATEWAY WITH (4) DMX CONTROL CIRCUIT CAPACITY AND POWER SUPPLY IN DIN CABINET. PROVIDE TOGGLE SWITCH FOR LOCAL POWER DISCONNECT.
2. LOCATE CABINET BELOW JCI CONTROL CABINET.

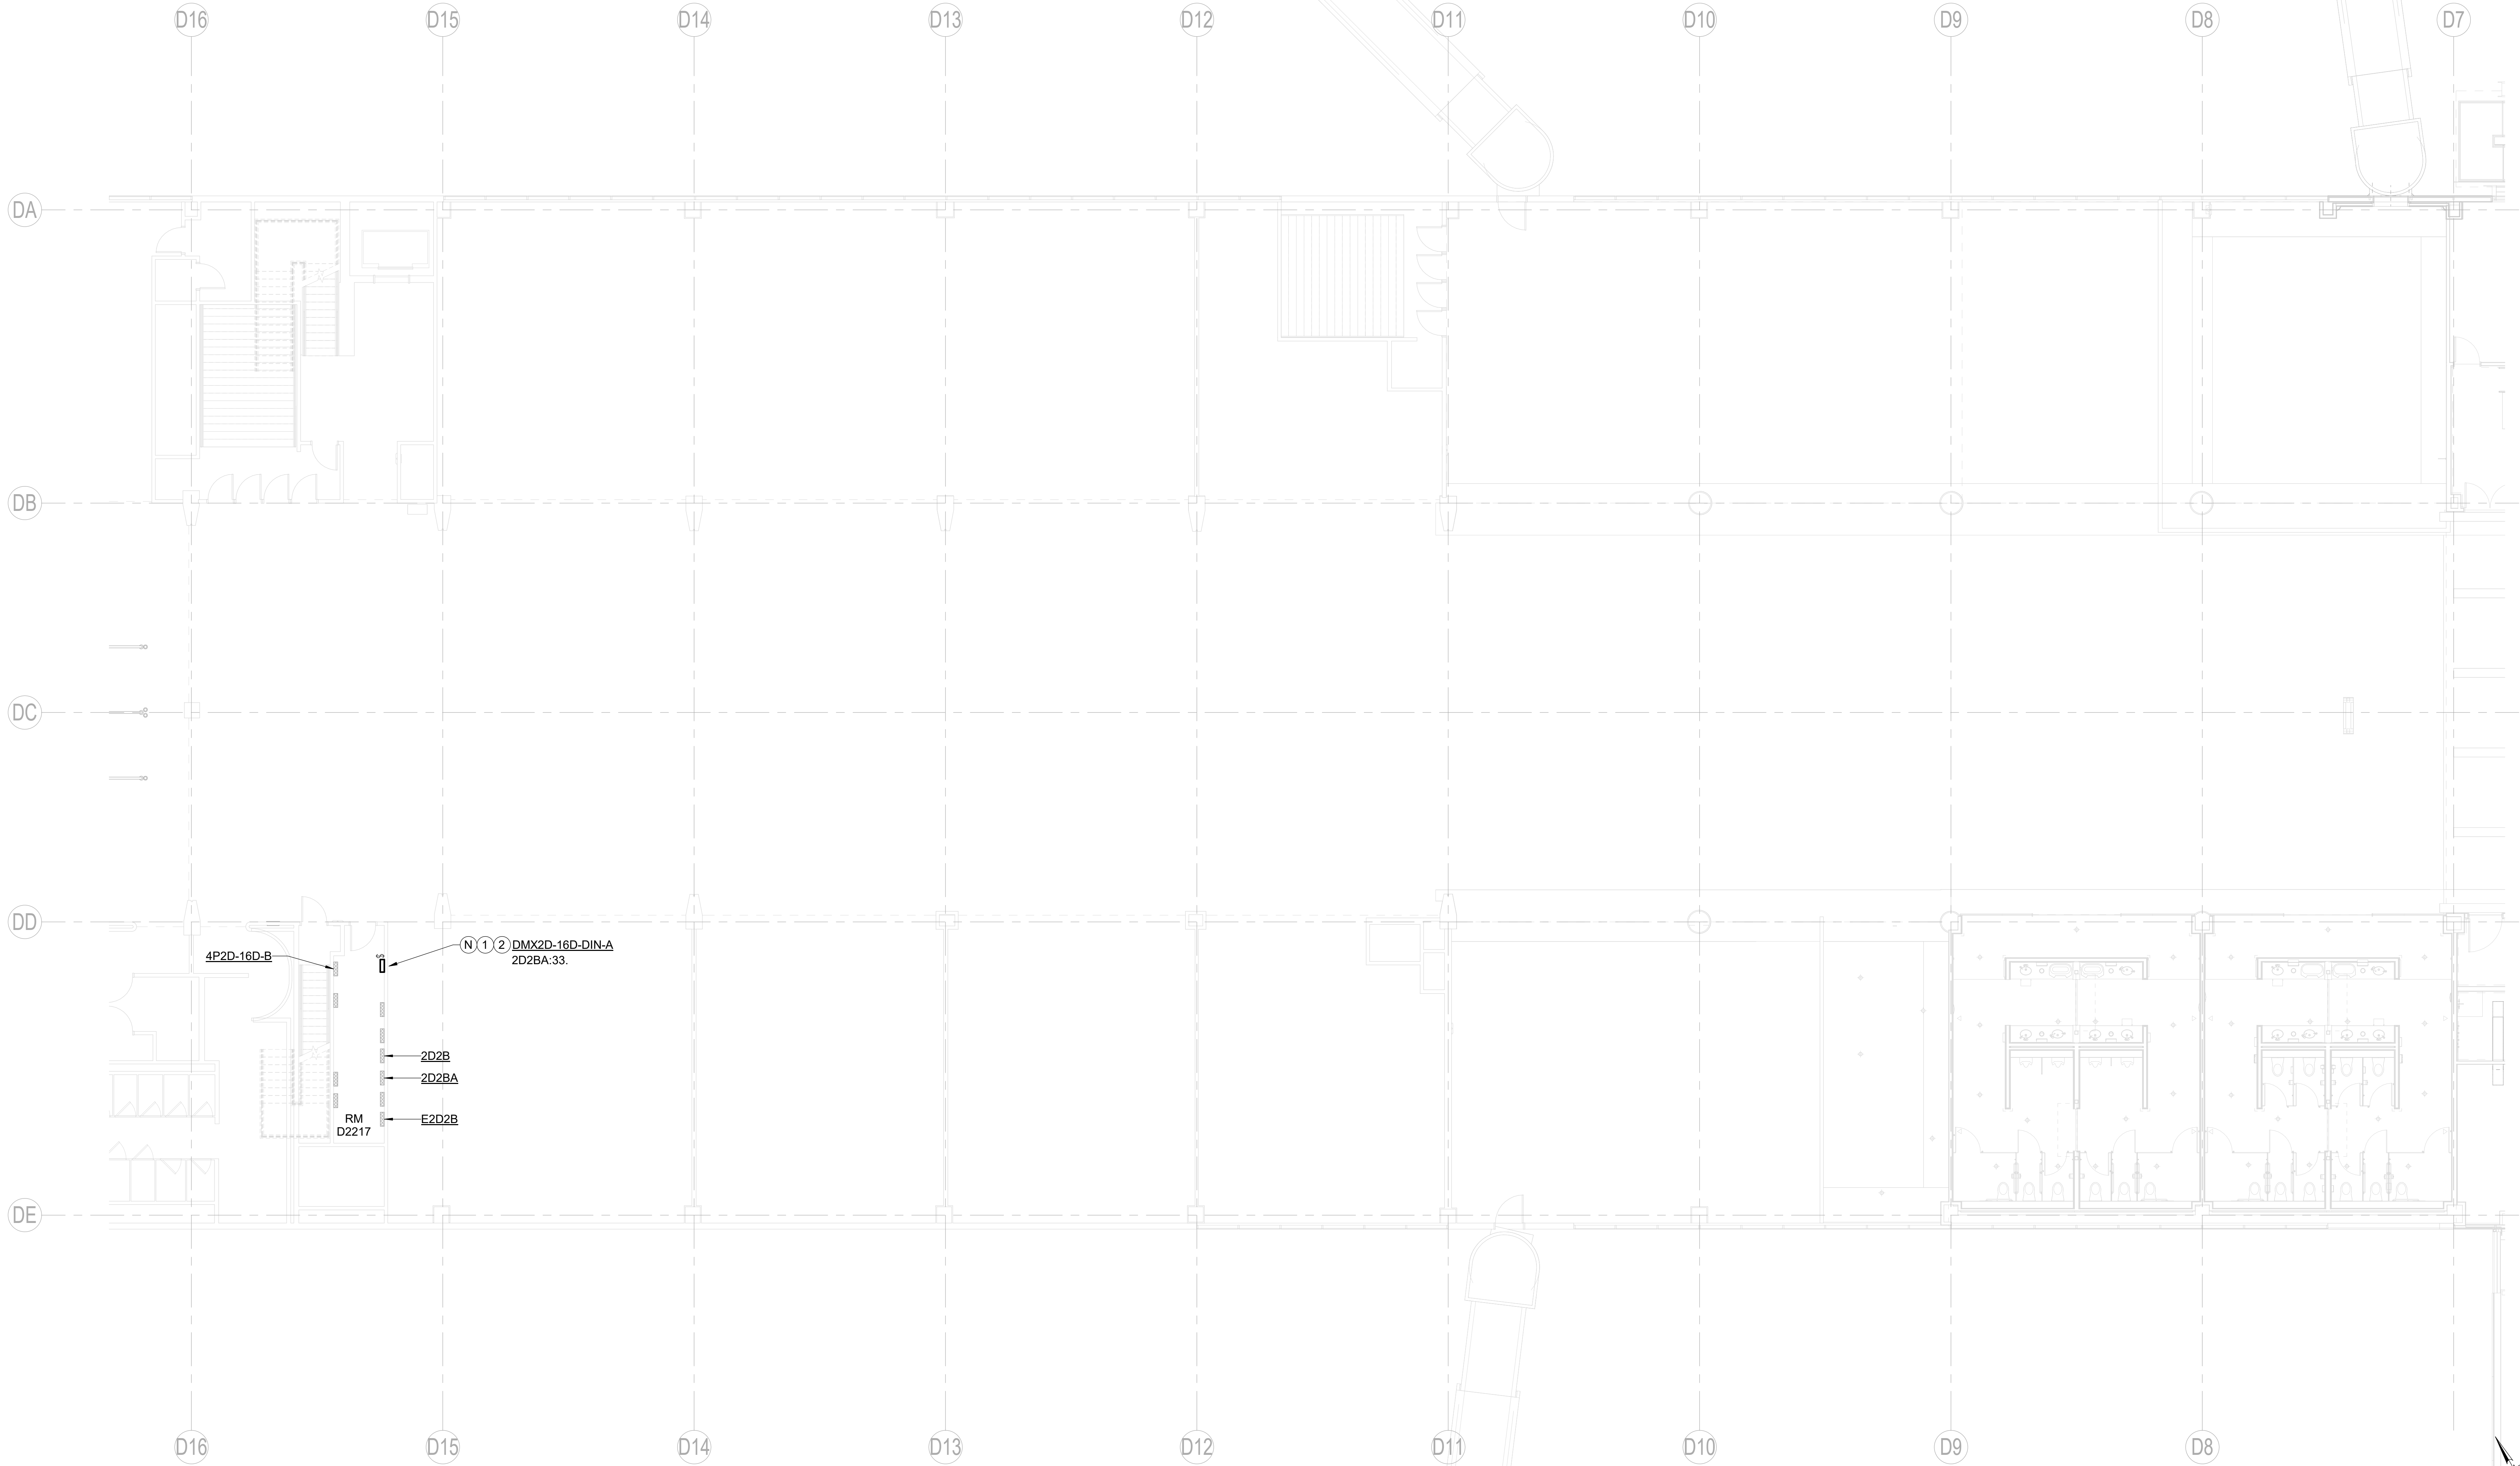

1 CONCURSE D - ENPLANING - SECTOR 00 - FLOOR PLAN - ELECTRICAL
SCALE: 1/8" = 1'-0"

KEY PLAN
SCALE: N.T.S.
