


CAN YOU SEE THE AIRPLANES? THE ADJACENT SAMPLES SHOW THREE DIFFERENT LEVELS OF SHADING. SETTINGS FOR VIEWING AND PRINTING CONTENT ARE OPTIMIZED WHEN ALL THREE PLANES ARE VISIBLE. THIS GUIDANCE IS PROVIDED FOR REFERENCE ONLY.

DRAWING SCALE IS REDUCED 50% WHEN SHEET SIZE IS 11" x 17"  
GRAPHIC SCALE FOR REFERENCE ONLY

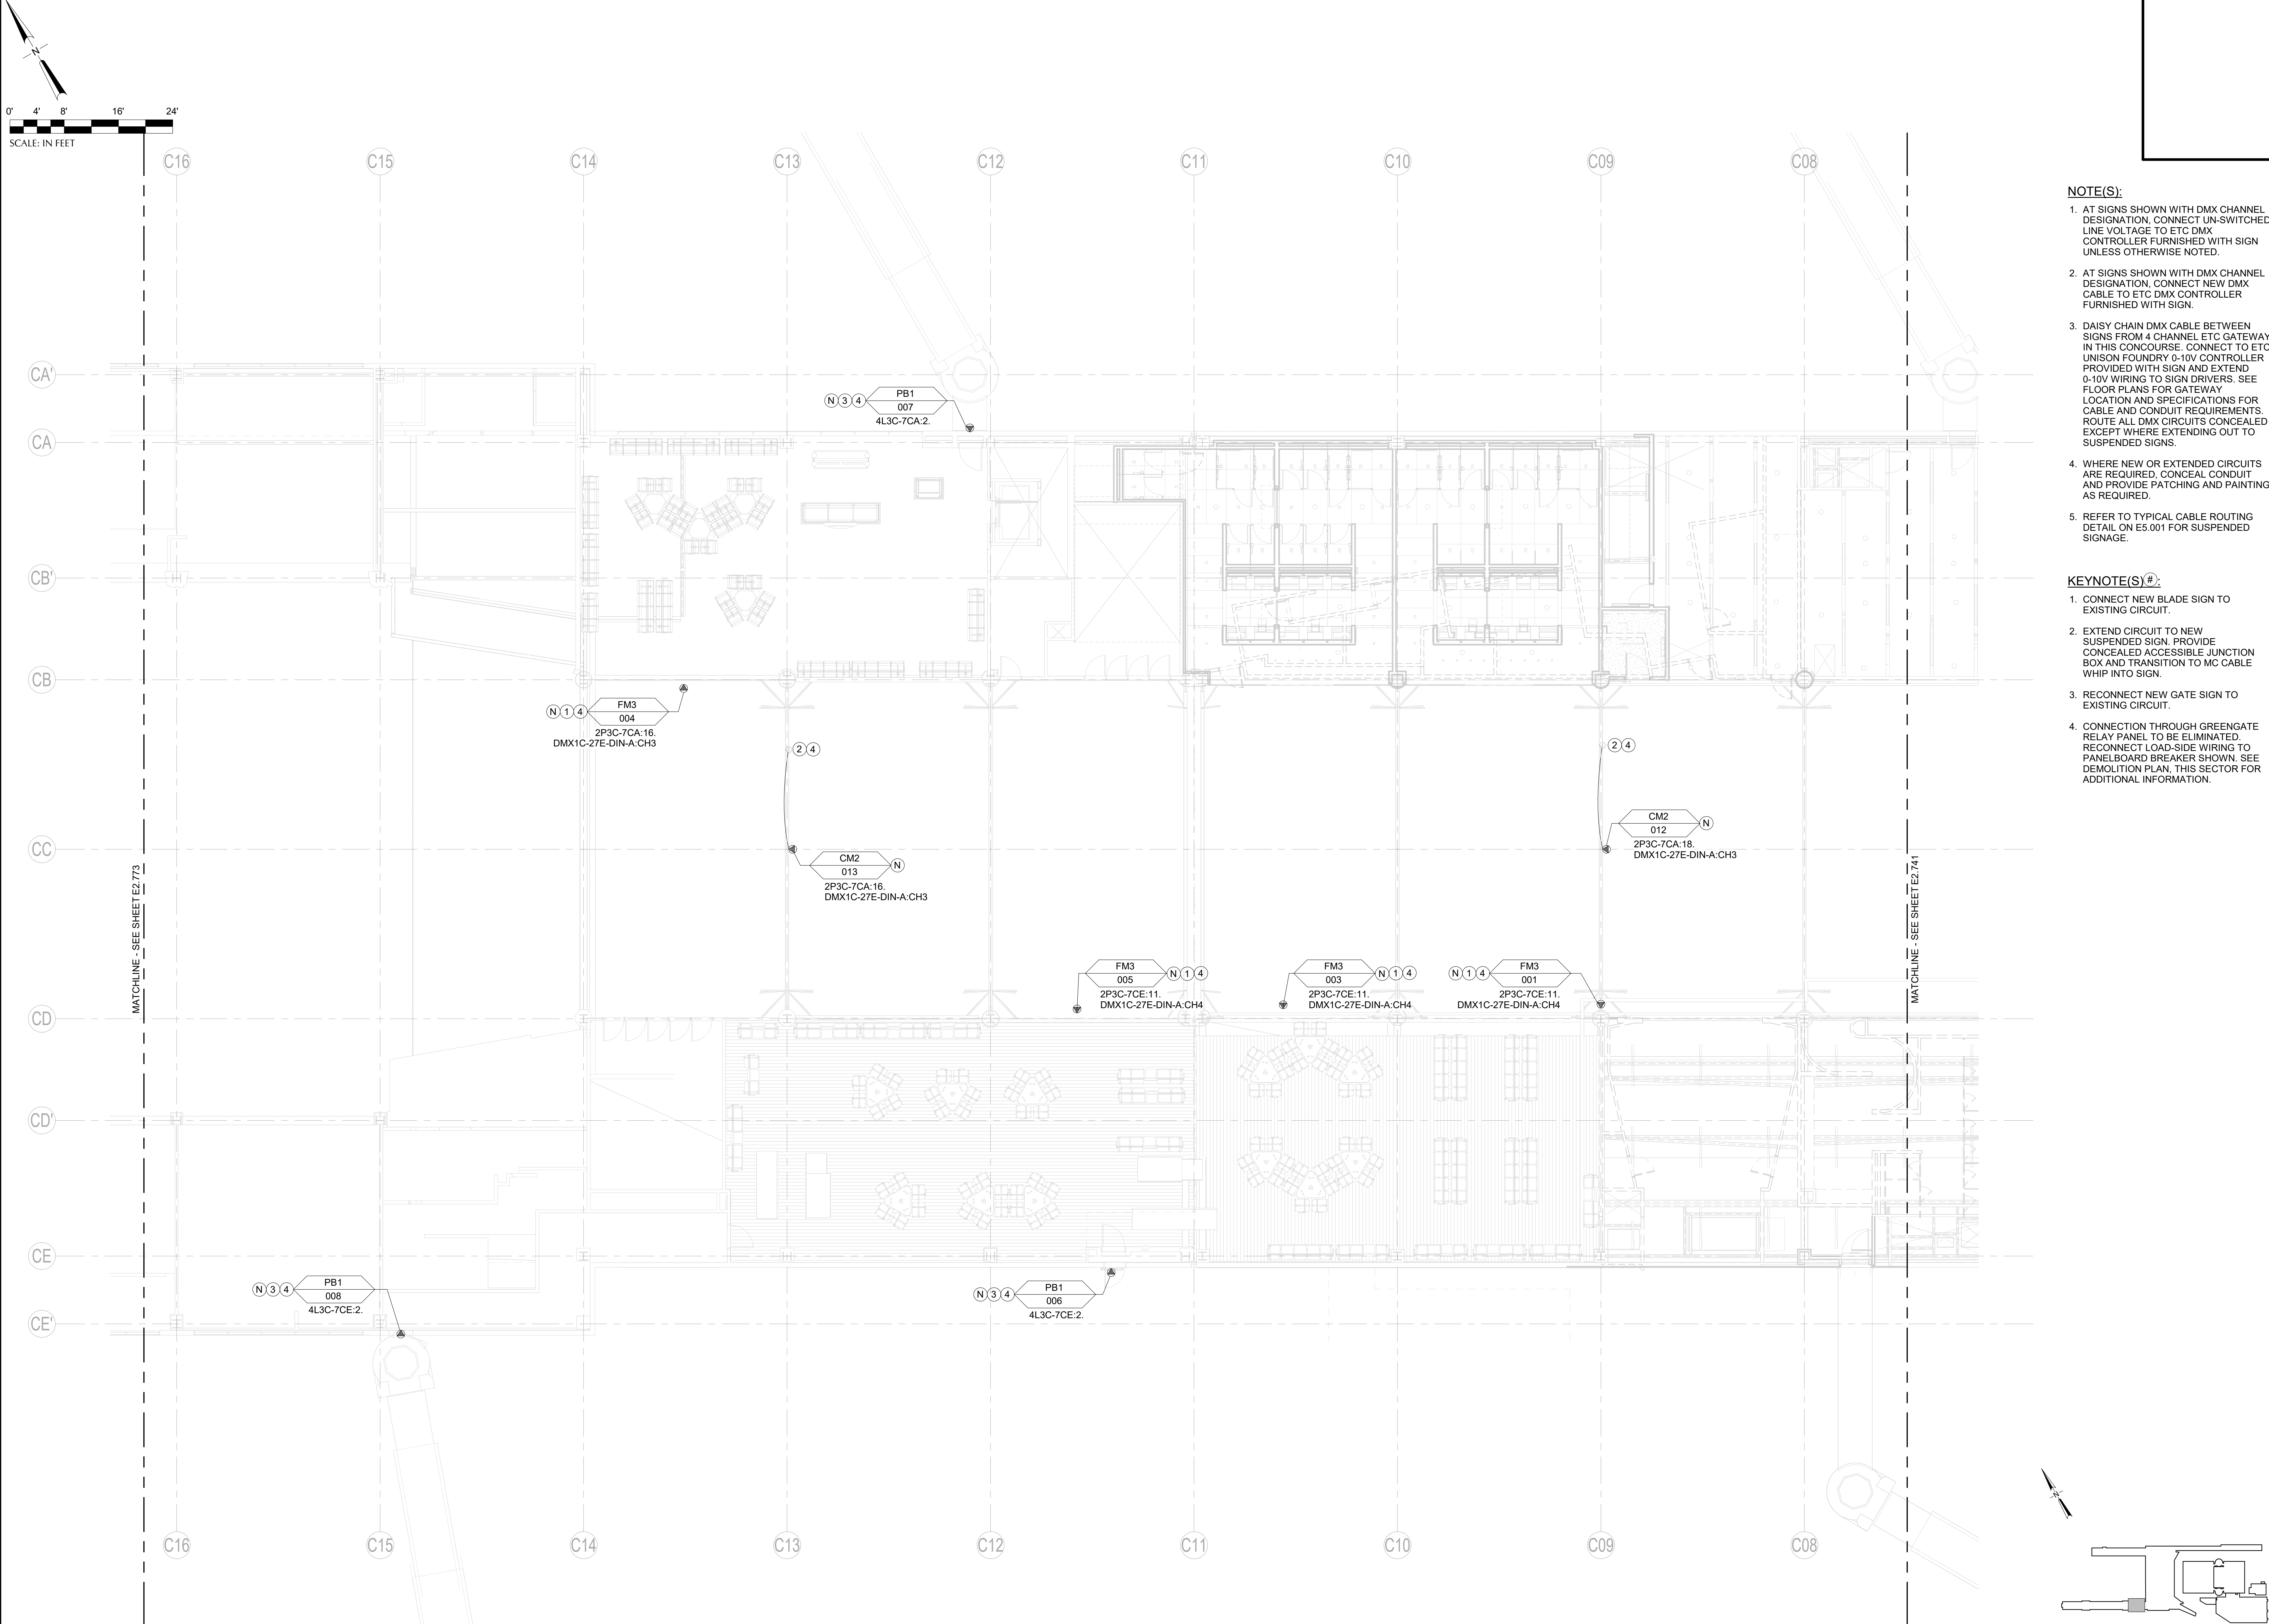

**NOTE(S):**

1. AT SIGNS SHOWN WITH DMX CHANNEL DESIGNATION, CONNECT UN-SWITCHED LINE VOLTAGE TO ETC DMX CONTROLLER FURNISHED WITH SIGN UNLESS OTHERWISE NOTED.
2. AT SIGNS SHOWN WITH DMX CHANNEL DESIGNATION, CONNECT NEW DMX CABLE TO ETC DMX CONTROLLER FURNISHED WITH SIGN.
3. DAISY CHAIN DMX CABLE BETWEEN SIGNS FROM 4 CHANNEL ETC GATEWAY IN THIS CONCOURSE. CONNECT TO ETC UNION FOUNDRY 0-10V CONTROLLER PROVIDED WITH SIGN AND EXTEND 0-10V WIRING TO SIGN DRIVERS. SEE FLOOR PLANS FOR GATEWAY LOCATION AND SPECIFICATIONS FOR CABLE AND CONDUIT REQUIREMENTS. ROUTE ALL DMX CIRCUITS CONCEALED EXCEPT WHERE EXTENDING OUT TO SUSPENDED SIGNS.
4. WHERE NEW OR EXTENDED CIRCUITS ARE REQUIRED, CONCEAL CONDUIT AND PROVIDE PATCHING AND PAINTING AS REQUIRED.
5. REFER TO TYPICAL CABLE ROUTING DETAIL ON E5.001 FOR SUSPENDED SIGNAGE.

**KEYNOTE(S) #:**

1. CONNECT NEW BLADE SIGN TO EXISTING CIRCUIT.
2. EXTEND CIRCUIT TO NEW SUSPENDED SIGN. PROVIDE CONCEALED ACCESSIBLE JUNCTION BOX AND TRANSITION TO MC CABLE WHIP INTO SIGN.
3. RECONNECT NEW GATE SIGN TO EXISTING CIRCUIT.
4. CONNECTION THROUGH GREENGATE RELAY PANEL TO BE ELIMINATED. RECONNECT LOAD-SIDE WIRING TO PANELBOARD BREAKER SHOWN. SEE DEMOLITION PLAN. THIS SECTOR FOR ADDITIONAL INFORMATION.


1 CONCOURSE C - ENPLANING - SECTOR 40 - REFLECTED CEILING PLAN - ELECTRICAL  
SCALE: 1/8" = 1'-0"

| NO. | DATE       | BY | REVISIONS         |
|-----|------------|----|-------------------|
| 1   | 07/24/2026 | B  | ISSUED FOR PERMIT |

| NO. | DATE       | BY | REVISIONS         |
|-----|------------|----|-------------------|
| 1   | 07/24/2026 | A  | ISSUED FOR PERMIT |

**Port of Portland**  
dbc architecture  
2505 se 11th ave #326  
portland, or 97202  
503.504.1200  
dbcarchitecture.com

**PAE** pae-engineers.com  
151 SW 1st Avenue #300  
Portland, OR 97204  
503.226.2921  
pae-engineers.com

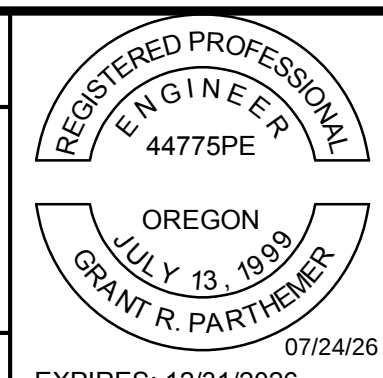

|                                                                           |  |
|---------------------------------------------------------------------------|--|
| PORTLAND INTERNATIONAL AIRPORT                                            |  |
| TERMINAL AND CONCOURSES WAYFINDING SIGNAGE                                |  |
| CONCOURSE C - ENPLANING - SECTOR 40 - REFLECTED CEILING PLAN - ELECTRICAL |  |

|                |              |
|----------------|--------------|
| SUBMITTED BY   | JAY OSTLUND  |
| DESIGNED BY    | D. PEEK      |
| DRAWN BY       | P. MARKS     |
| CHECKED BY     | G. PARTHEMER |
| DATE           | AUGUST 2026  |
| SHEET NO.      | 67           |
| DRAWING NO.    | PDX 2026-512 |
| TYPE           | CD           |
| DISC. BYT. NO. | E2.740       |

**KEY PLAN**  
SCALE: N.T.S.

