 



CAN YOU SEE THE AIRPLANES? THE ADJACENT SAMPLES SHOW THREE DIFFERENT LEVELS OF CHANGING SETTINGS FOR VIEWING AND PRINTING CONTENT ARE OPTIMIZED. WHEN ALL THREE PLANES ARE VISIBLE, THIS GUIDANCE IS PROVIDED FOR REFERENCE ONLY.



0' 4' 8' 16' 24'
SCALE: IN FEET

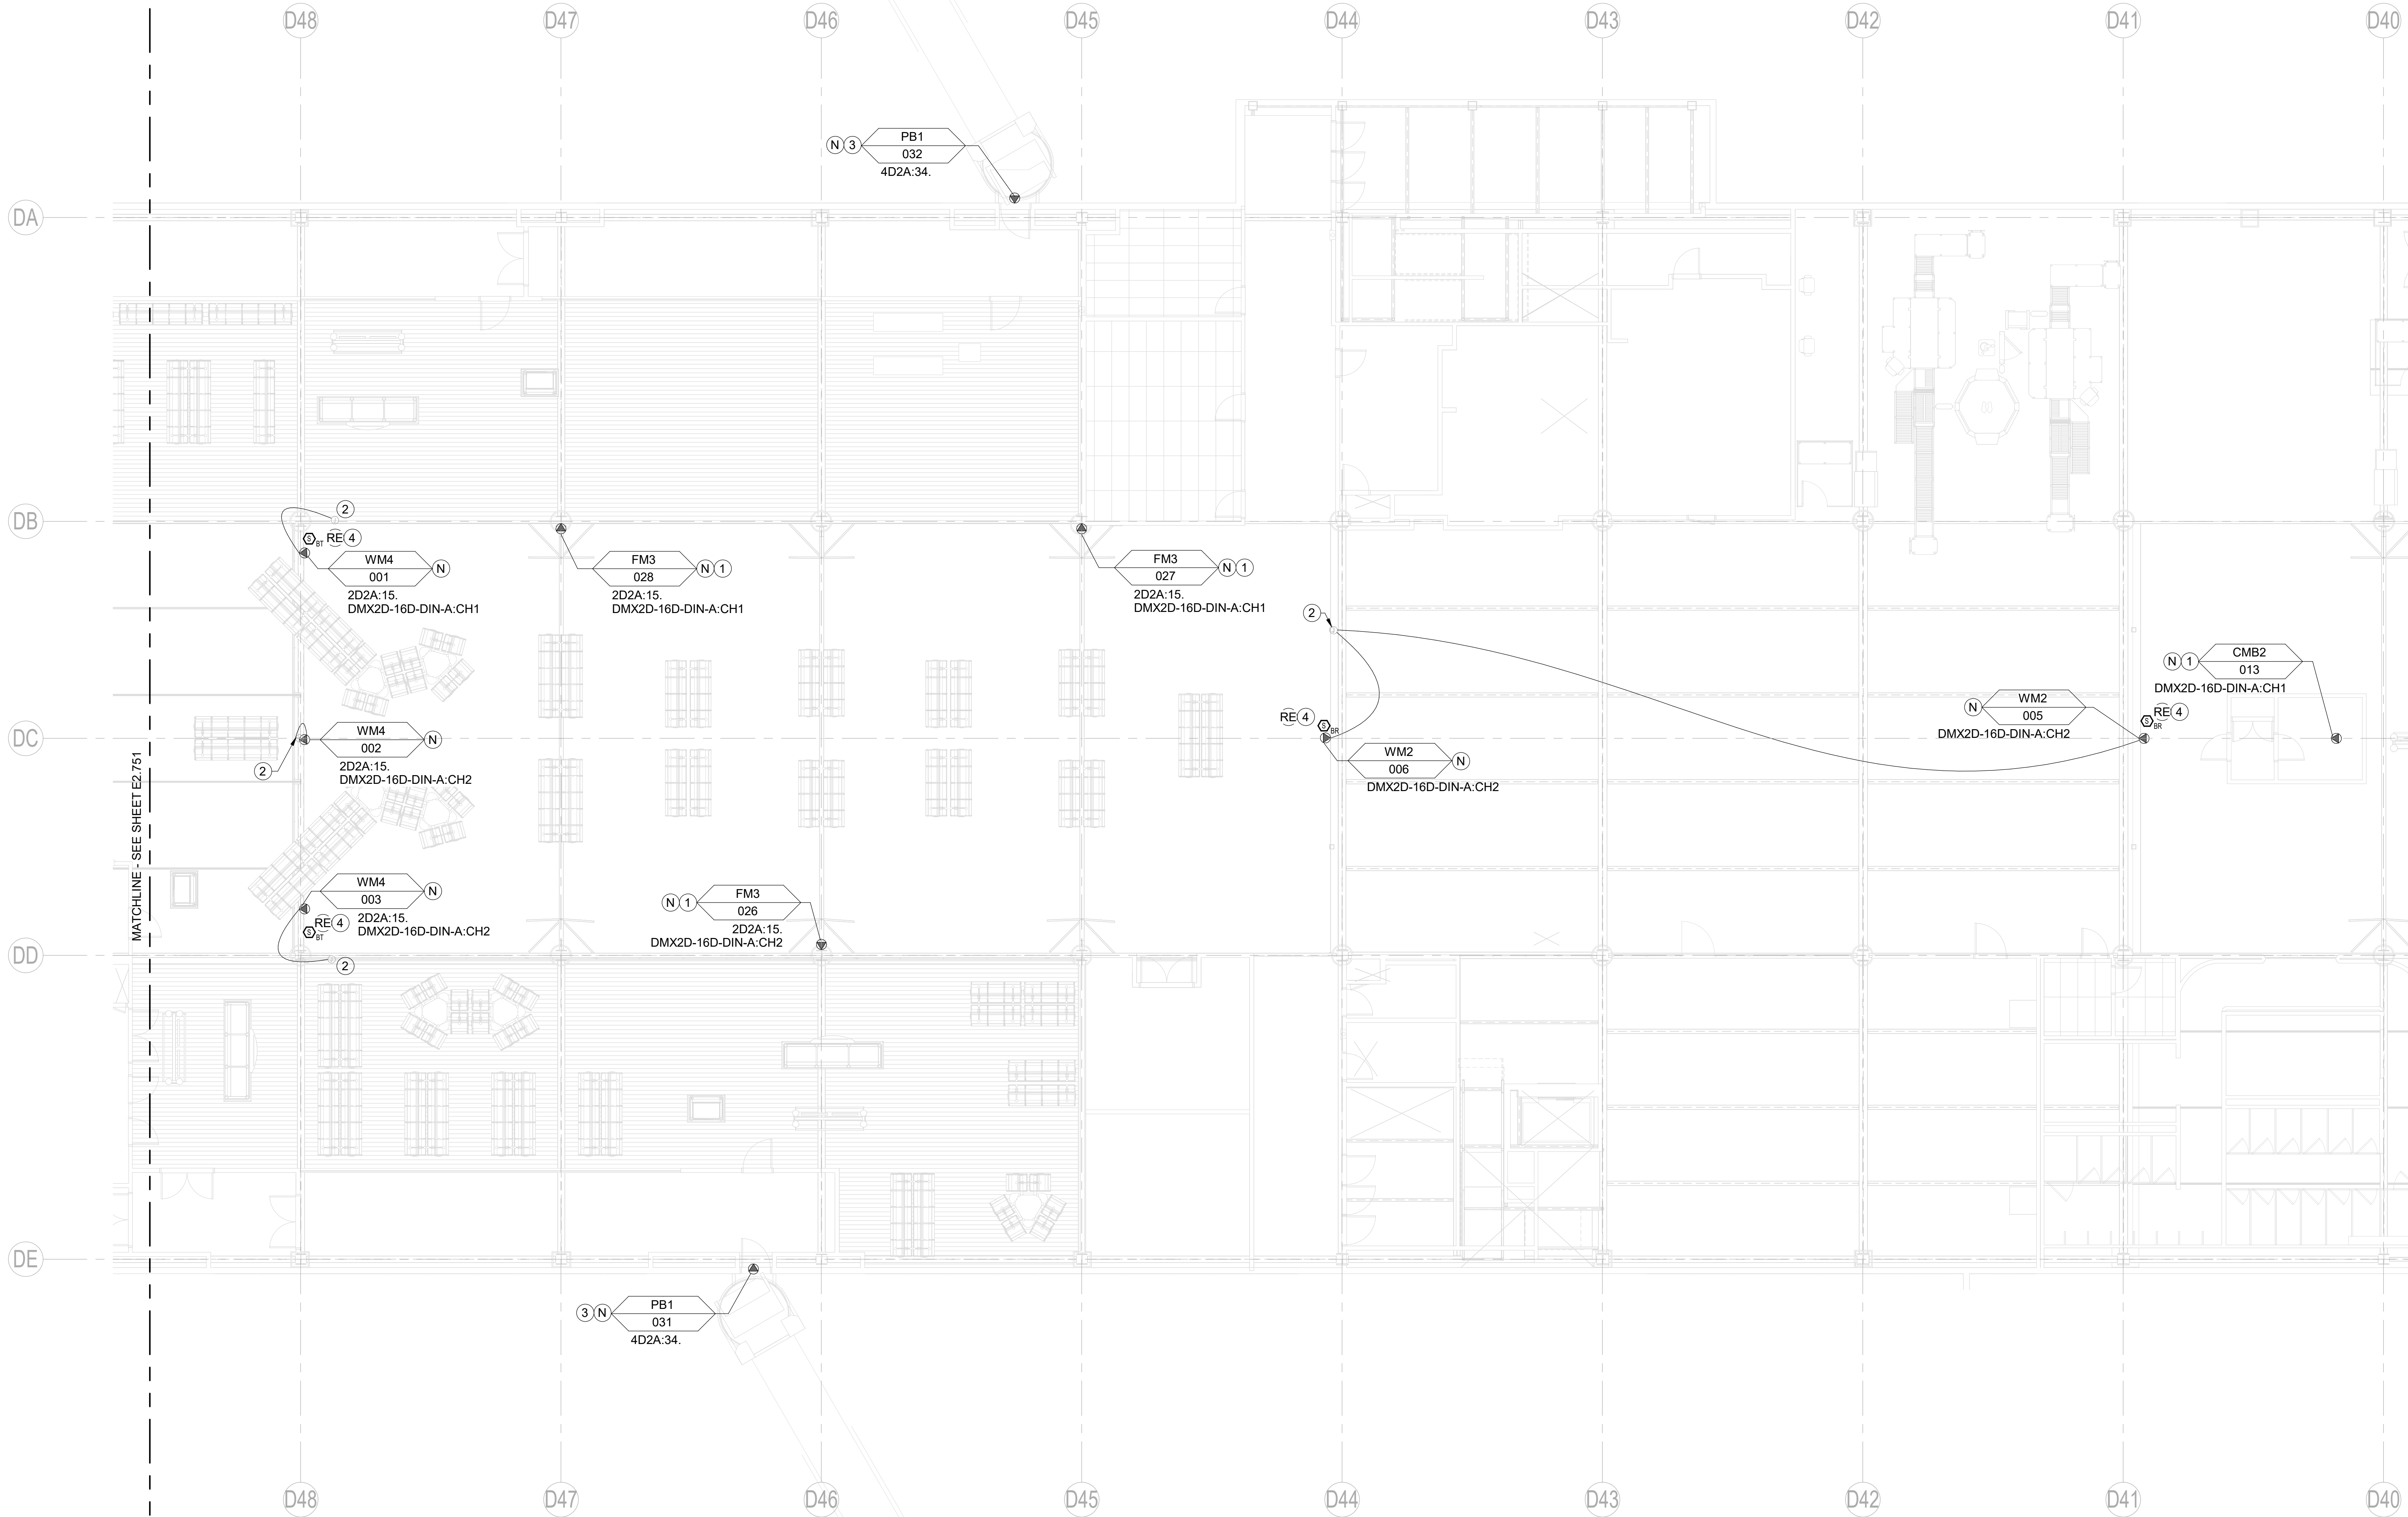

NOTE(S):

1. AT SIGNS SHOWN WITH DMX CHANNEL DESIGNATION, CONNECT UN-SWITCHED LINE VOLTAGE TO ETC DMX CONTROLLER FURNISHED WITH SIGN UNLESS OTHERWISE NOTED.
2. AT SIGNS SHOWN WITH DMX CHANNEL DESIGNATION, CONNECT NEW DMX CABLE TO ETC DMX CONTROLLER FURNISHED WITH SIGN.
3. DAISY CHAIN DMX CABLE BETWEEN SIGNS FROM 4 CHANNEL ETC GATEWAY IN THIS CONCOURSE. CONNECT TO ETC UNISON FOUNDRY 0-10V CONTROLLER PROVIDED WITH SIGN AND EXTEND 0-10V WIRING TO SIGN DRIVERS. SEE FLOOR PLANS FOR GATEWAY LOCATION AND SPECIFICATIONS FOR CABLE AND CONDUIT REQUIREMENTS. ROUTE ALL DMX CIRCUITS CONCEALED EXCEPT WHERE EXTENDING OUT TO SUSPENDED SIGNS.
4. WHERE NEW OR EXTENDED CIRCUITS ARE REQUIRED, CONCEAL CONDUIT AND PROVIDE PATCHING AND PAINTING AS REQUIRED.
5. REFER TO TYPICAL CABLE ROUTING DETAIL ON E5.001 FOR SUSPENDED SIGNAGE.

KEYNOTE(S) #:

1. CONNECT NEW SIGN TO EXISTING CIRCUIT.
2. EXTEND CIRCUIT TO NEW SURFACE MOUNT OR SUSPENDED SIGN. PROVIDE CONCEALED ACCESSIBLE JUNCTION BOX AND TRANSITION TO MC CABLE WHIP INTO SIGN.
3. PROVIDE NEW CIRCUIT AND CONNECT TO NEW SIGN. PROVIDE CONCEALED ACCESSIBLE JUNCTION BOX AND TRANSITION TO MC CABLE WHIP INTO SIGN.
4. RELOCATE BEAM DETECTOR TO ABOVE NEW SIGN. PLACE TO AVOID OBSTRUCTIONS AND MAINTAIN FUNCTIONAL ALIGNMENT OF DETECTOR BEAM GENERATORS AND RECEIVERS. EXTEND EXISTING CONNECTIONS OR PROVIDE NEW CONNECTIONS BACK TO LAST DEVICE OR HEAD END EQUIPMENT. MAINTAIN CONNECTIONS TO DOWNSTREAM EQUIPMENT AND DEVICES. RE-CALIBRATE AND RE-COMMISSION TO MAINTAIN EXISTING FUNCTIONALITY.

1 CONCOURSE D - ENPLANING - SECTOR 52 - REFLECTED CEILING PLAN - ELECTRICAL
SCALE: 1/8" = 1'-0"

NO.	DATE	BY	REVISIONS

dbc architecture

2505 se 11th ave #328
portland, or 97202

503.504.1230
dbcarchitecture.com


pae-engineers.com

151 SW 1st Avenue #300
Portland, OR 97204

503.226.2921
pae-engineers.com

20260904
EAL

103101
PAE

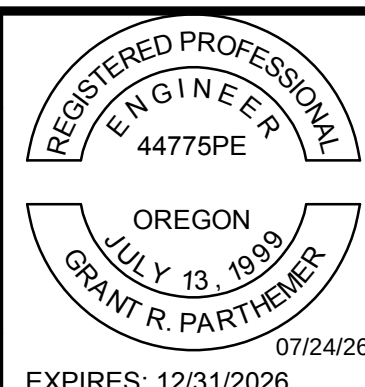

PORTLAND INTERNATIONAL AIRPORT
TERMINAL AND CONCOURSES WAYFINDING SIGNAGE
CONCOURSE D - ENPLANING - SECTOR 52 - REFLECTED CEILING PLAN - ELECTRICAL

KEY PLAN
SCALE: N.T.S.

SUBMITTED BY	JAY OSTLUND
DESIGNED BY	D. PEEK
DRAWN BY	P. MARKS
CHECKED BY	G. PARTHEMER
DATE	AUGUST 2026
SHEET NO.	70
TYPE	CD
DRAWING NO.	PDX 2026-512
DISC. SHT. NO.	E2.752

DRAWING SCALE IS REDUCED 50% WHEN SHEET SIZE IS 17" x 22".
GRAPHIC SCALE FOR REFERENCE ONLY