
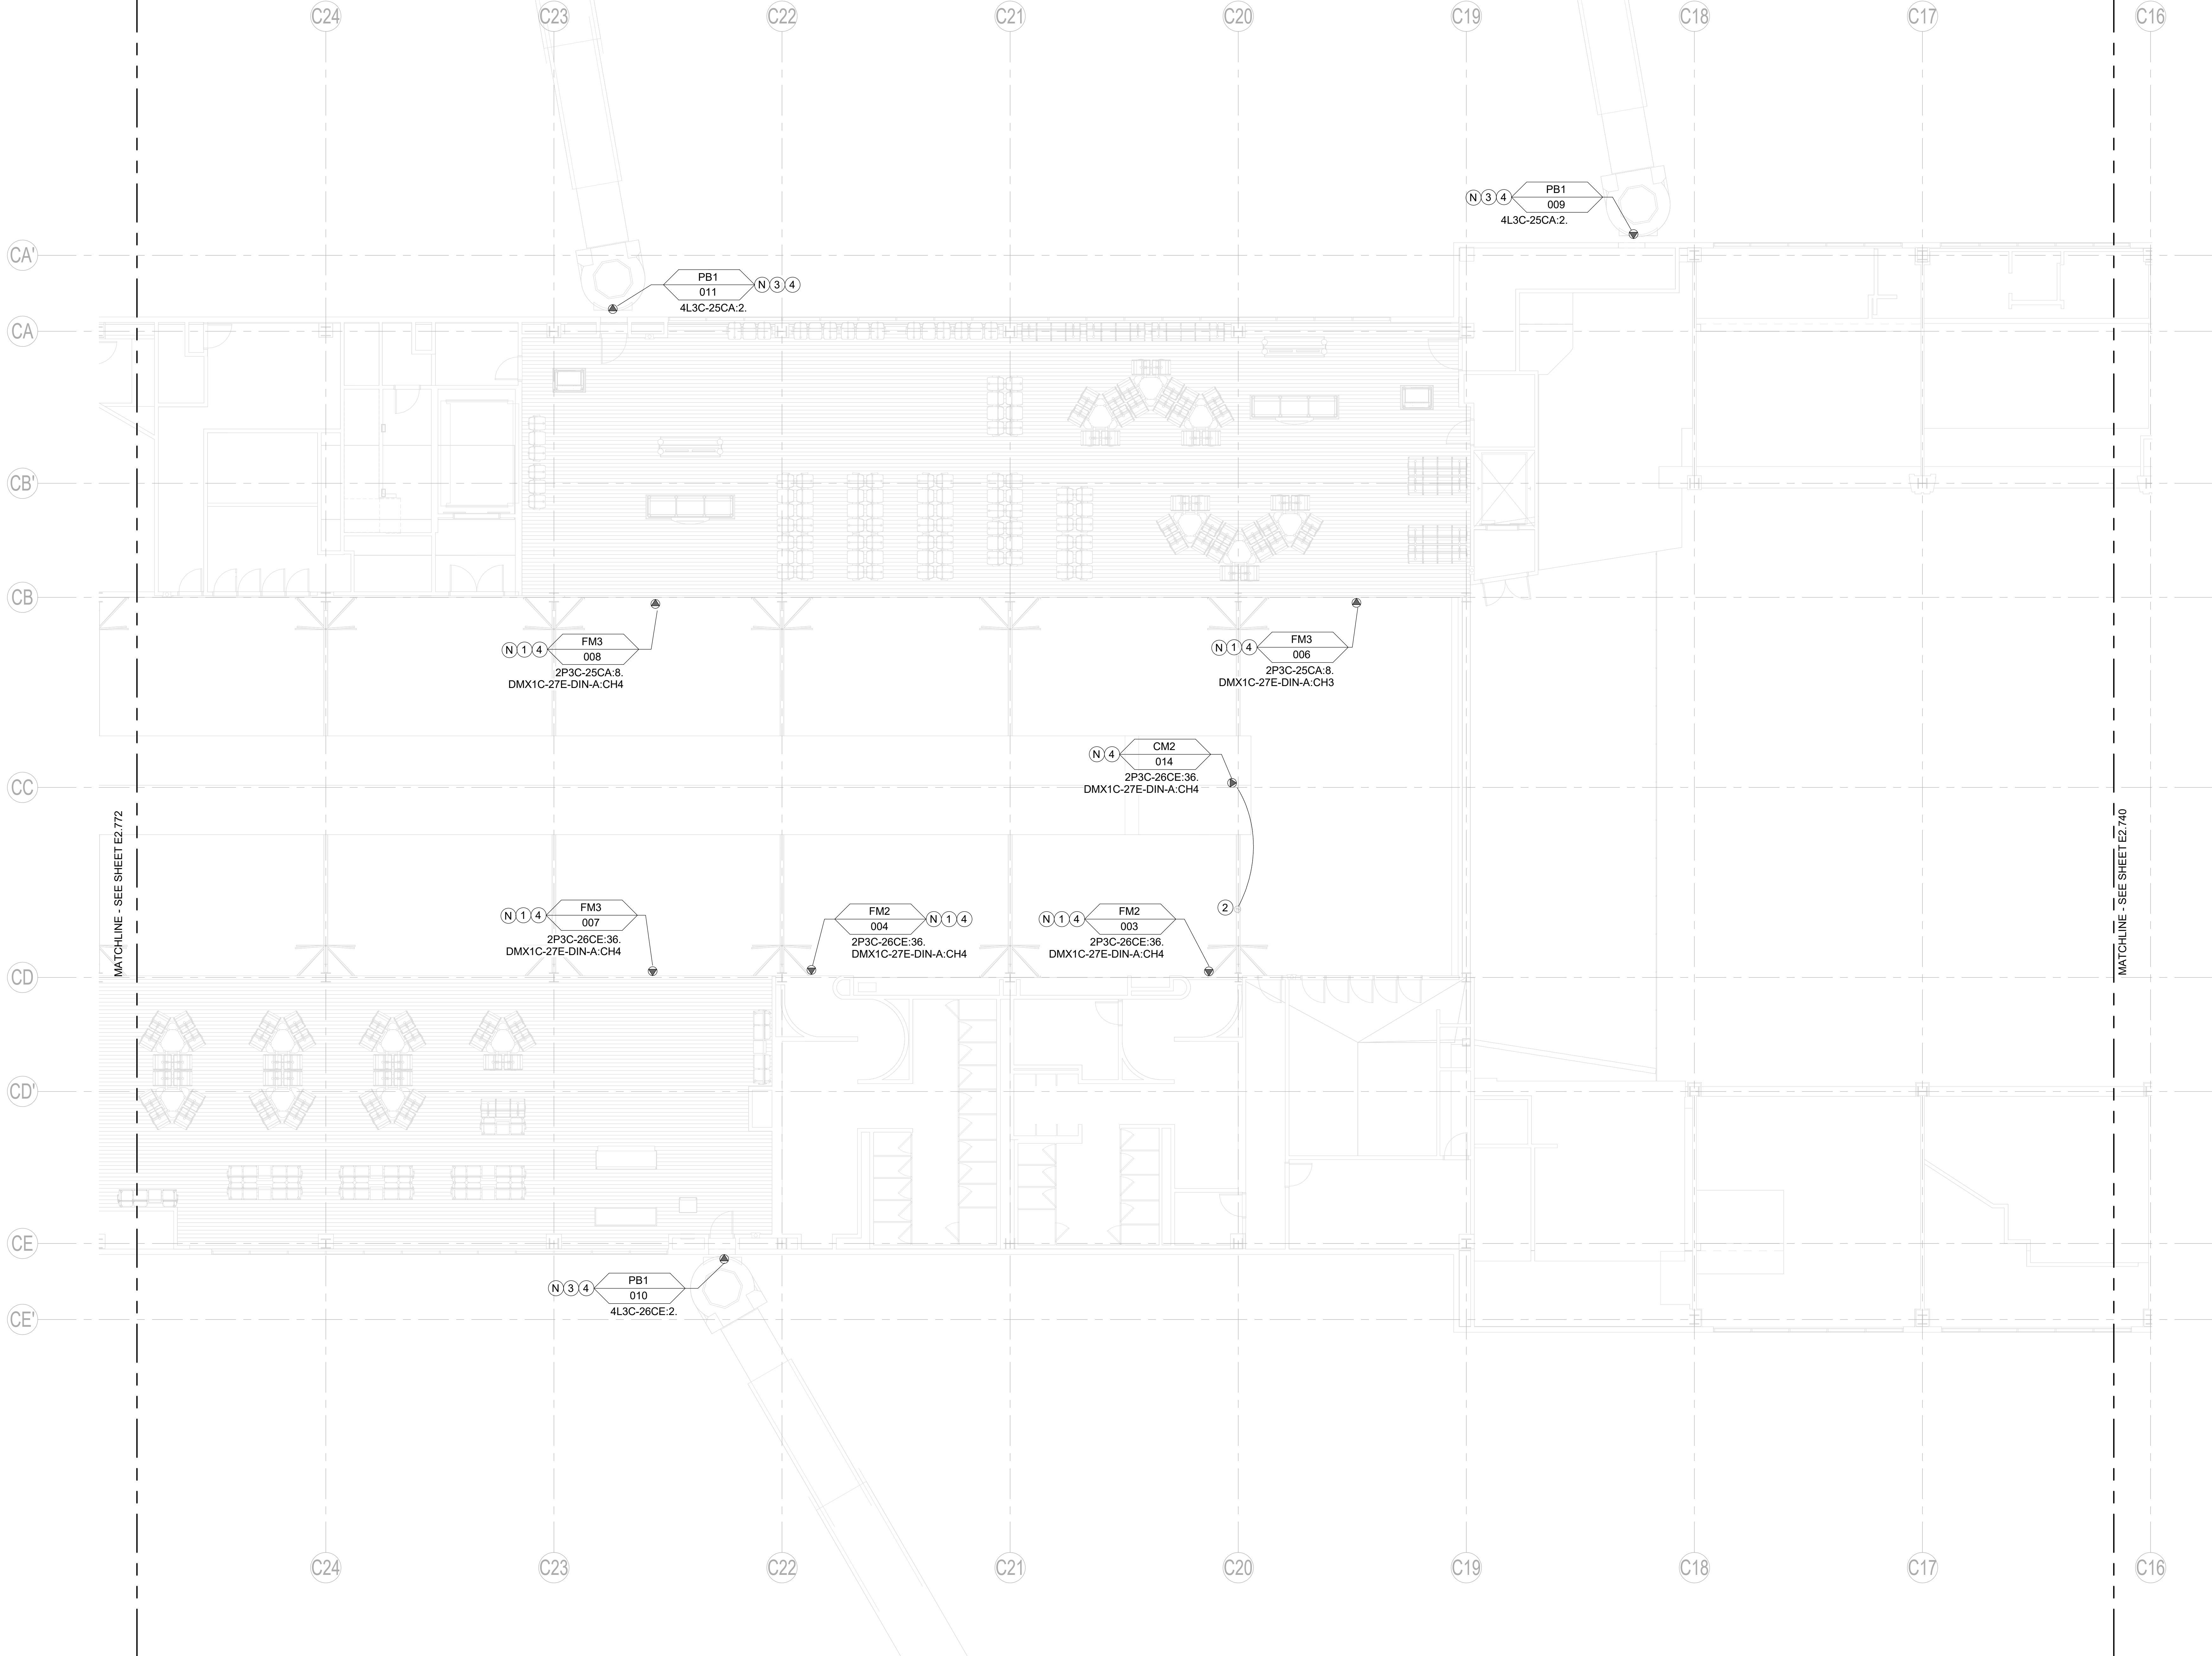


CAN YOU SEE THE AIRPLANES? THE ADJACENT SAMPLES SHOW THREE DIFFERENT LEVELS OF SHADING. SETTINGS FOR VIEWING AND PRINTING CONTENT ARE OPTIMIZED WHEN ALL THREE PLANES ARE VISIBLE. THIS GUIDANCE IS PROVIDED FOR REFERENCE ONLY.

DRAWING SCALE IS REDUCED 50% WHEN SHEET SIZE IS 11" x 17".
GRAPHIC SCALE FOR REFERENCE ONLY

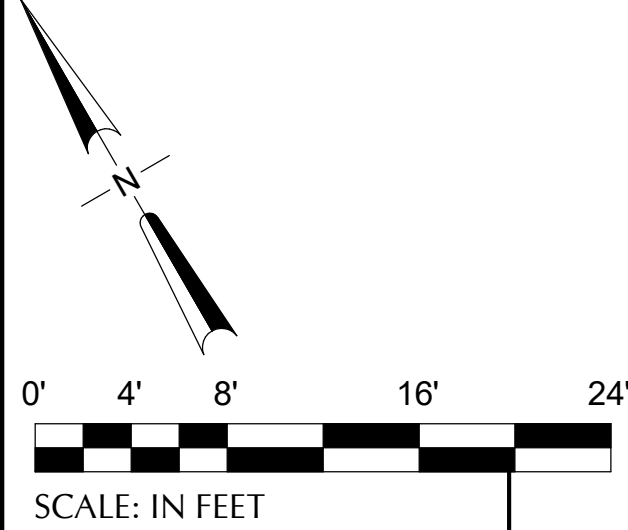


NOTE(S):

1. AT SIGNS SHOWN WITH DMX CHANNEL DESIGNATION, CONNECT UN-SWITCHED LINE VOLTAGE TO ETC DMX CONTROLLER FURNISHED WITH SIGN UNLESS OTHERWISE NOTED.
2. AT SIGNS SHOWN WITH DMX CHANNEL DESIGNATION, CONNECT NEW DMX CABLE TO ETC DMX CONTROLLER FURNISHED WITH SIGN.
3. DAISY CHAIN DMX CABLE BETWEEN SIGNS FROM 4 CHANNEL ETC GATEWAY IN THIS CONCOURSE. CONNECT TO ETC UNISON FOUNDRY 0-10V CONTROLLER PROVIDED WITH SIGN AND EXTEND 0-10V WIRING TO SIGN DRIVERS. SEE FLOOR PLANS FOR GATEWAY LOCATION AND SPECIFICATIONS FOR CABLE AND CONDUIT REQUIREMENTS. ROUTE ALL DMX CIRCUITS CONCEALED EXCEPT WHERE EXTENDING OUT TO SUSPENDED SIGNS.
4. WHERE NEW OR EXTENDED CIRCUITS ARE REQUIRED, CONCEAL CONDUIT AND PROVIDE PATCHING AND PAINTING AS REQUIRED.
5. REFER TO TYPICAL CABLE ROUTING DETAIL ON E5.001 FOR SUSPENDED SIGNAGE.

KEYNOTE(S):#

1. CONNECT NEW BLADE SIGN TO EXISTING CIRCUIT.
2. EXTEND CIRCUIT TO NEW SURFACE MOUNT OR SUSPENDED SIGN. PROVIDE CONCEALED ACCESSIBLE JUNCTION BOX AND TRANSITION TO MC CABLE WHIP INTO SIGN.
3. CONNECT NEW GATE SIGN TO EXISTING CIRCUIT.
4. CONNECTION THROUGH GREENGATE RELAY PANEL TO BE ELIMINATED. RECONNECT LOAD-SIDE WIRING TO PANELBOARD BREAKER SHOWN. SEE DEMOLITION PLAN, THIS SECTOR FOR ADDITIONAL INFORMATION.

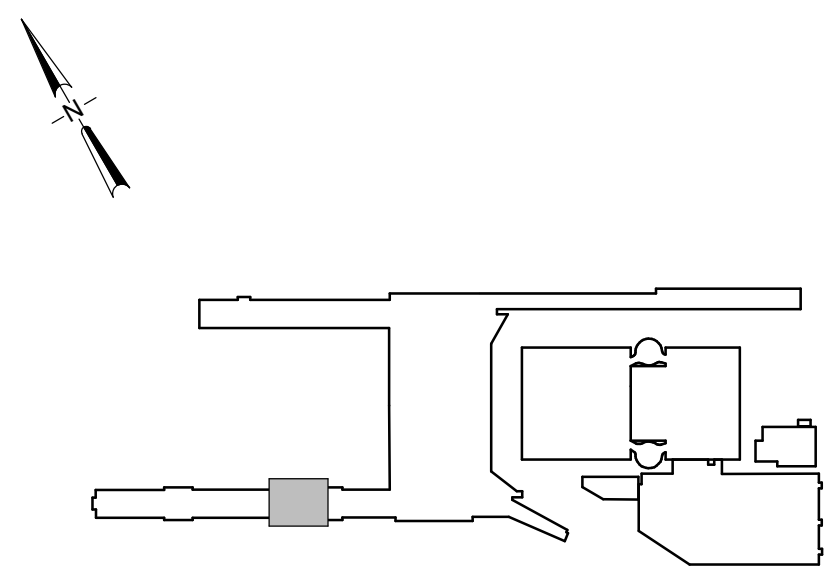

KEY PLAN
SCALE: N.T.S.

1 CONCOURSE C - ENPLANING - SECTOR 73 - REFLECTED CEILING PLAN - ELECTRICAL
SCALE: 1/8" = 1'-0"

																																								PORTLAND INTERNATIONAL AIRPORT										SUBMITTED BY JAY OSTLUND									
										dbc architecture										503.524.1230 portland, OR 97204										503.228.2921 portland, OR 97204										TERMINAL AND CONCOURSES WAYFINDING SIGNAGE										DRAWN BY P. MARKS									
										2505 se 11th ave #328 portland, OR 97202										dbcarchitecture.com										pae-engineers.com										CONCOURSE C - ENPLANING - SECTOR 73 - REFLECTED CEILING PLAN - ELECTRICAL										CHECKED BY G. PARTHMER									
										20260004										103101										07/24/26										DATE AUGUST 2026																			
										DATE										DATE										DRAWING NO. PDX 2026-512										DISC SHEET NO. E2.773																			
										BY										BY																																							
										REVISIONS										REVISIONS																																							