



CAN YOU SEE THE AIRPLANES? THE ADJACENT SAMPLES SHOW THREE DIFFERENT LEVELS OF SHADING SETTINGS FOR VIEWING AND PRINTING DRAWING CONTENT ARE OPTIMIZED WHEN ALL THREE PLANES ARE VISIBLE. THIS GUIDANCE IS PROVIDED FOR REFERENCE ONLY.


DRAWING SCALE IS REDUCED 50% WHEN SHEET SIZE IS 17" x 22".
GRAPHIC SCALE FOR REFERENCE ONLY

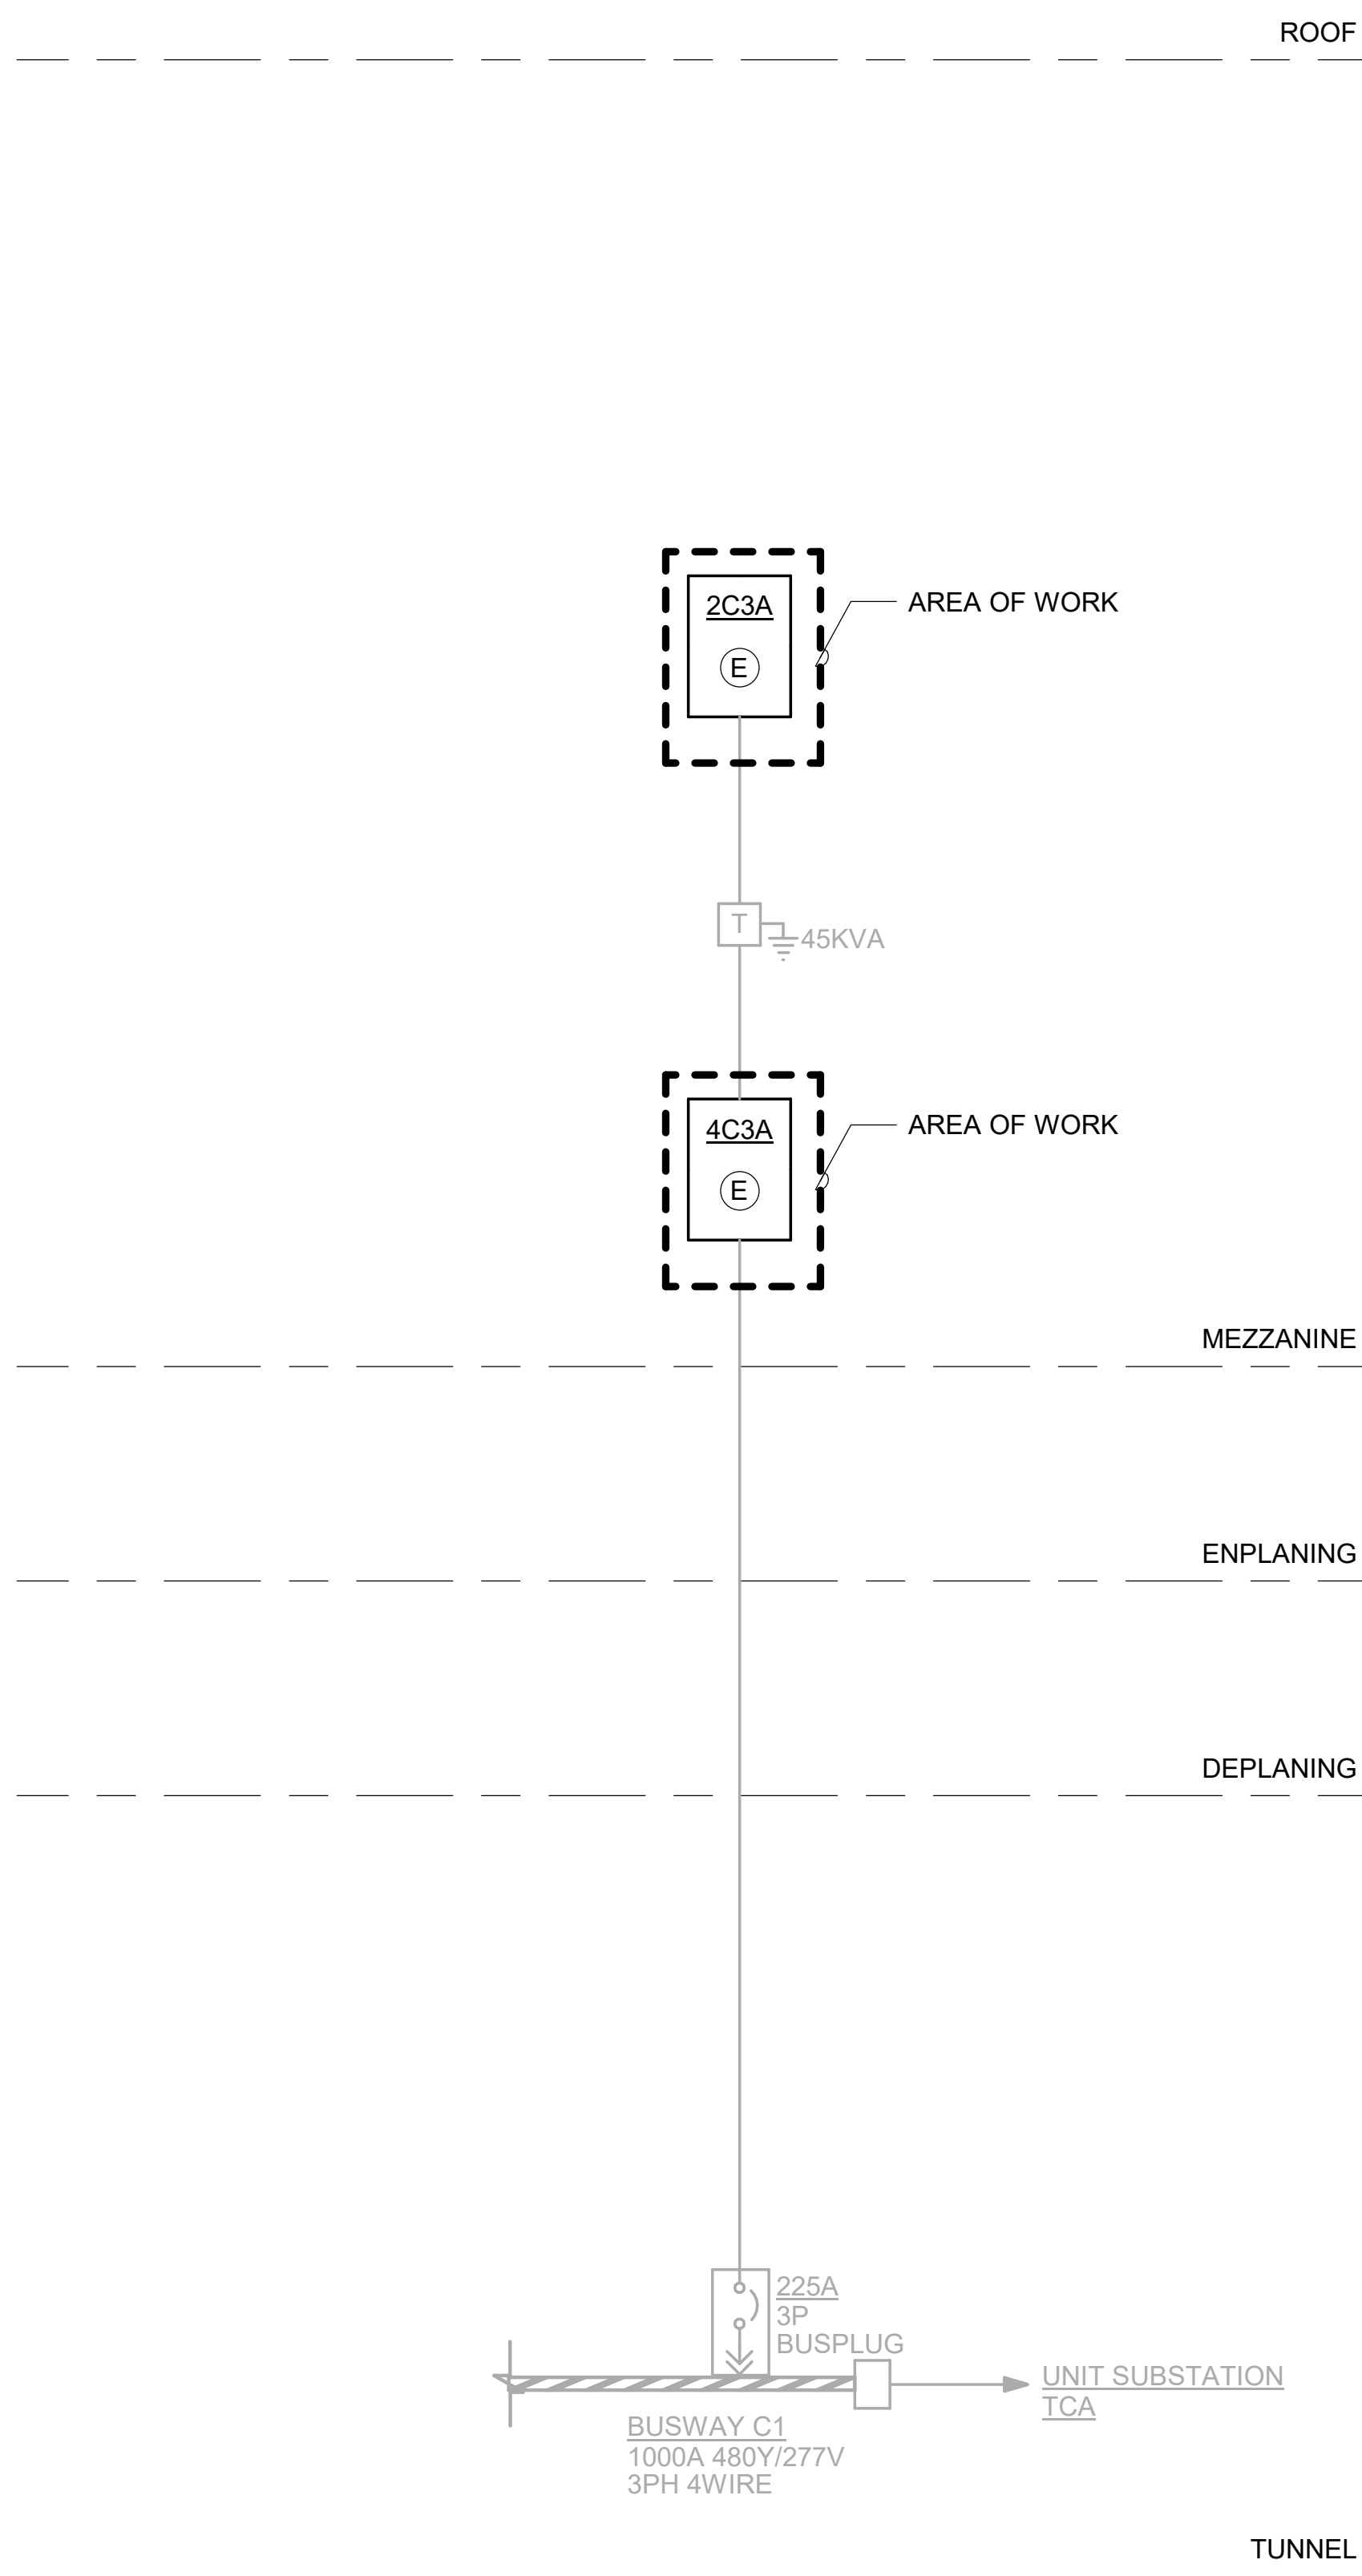

1 PARTIAL ONE LINE DIAGRAM - BUSDUCT C1
SCALE: NONE

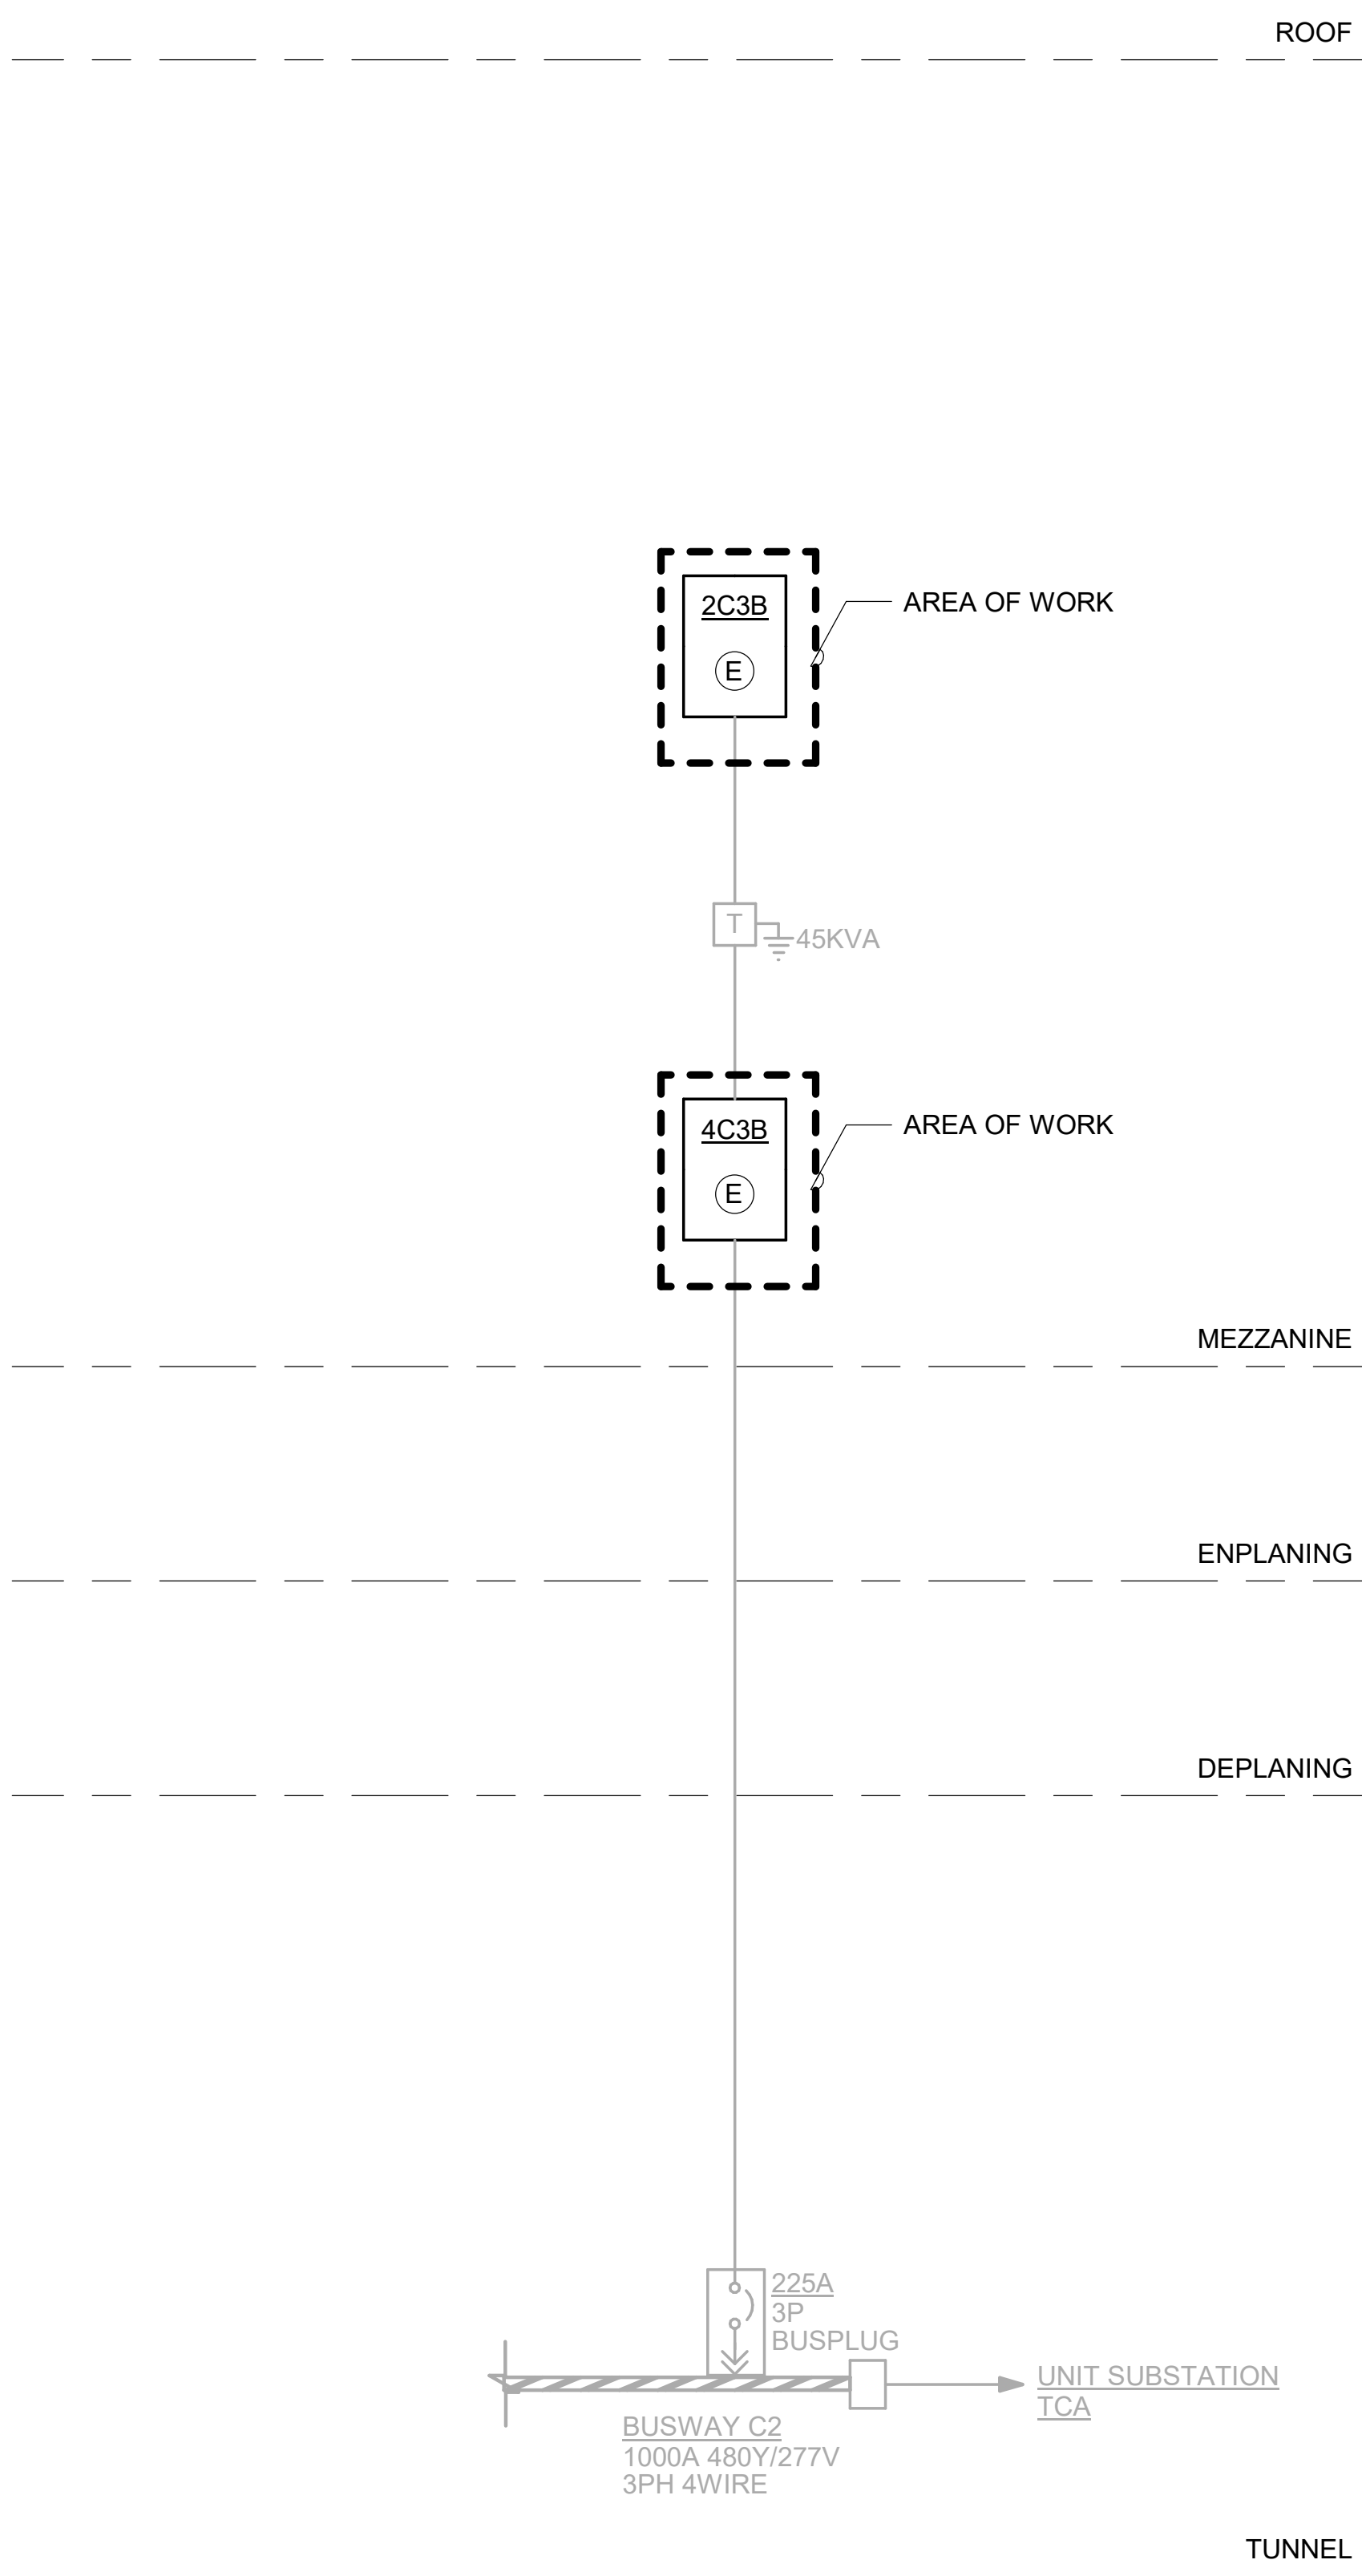

2 PARTIAL ONE LINE DIAGRAM - BUSDUCT C2
SCALE: NONE

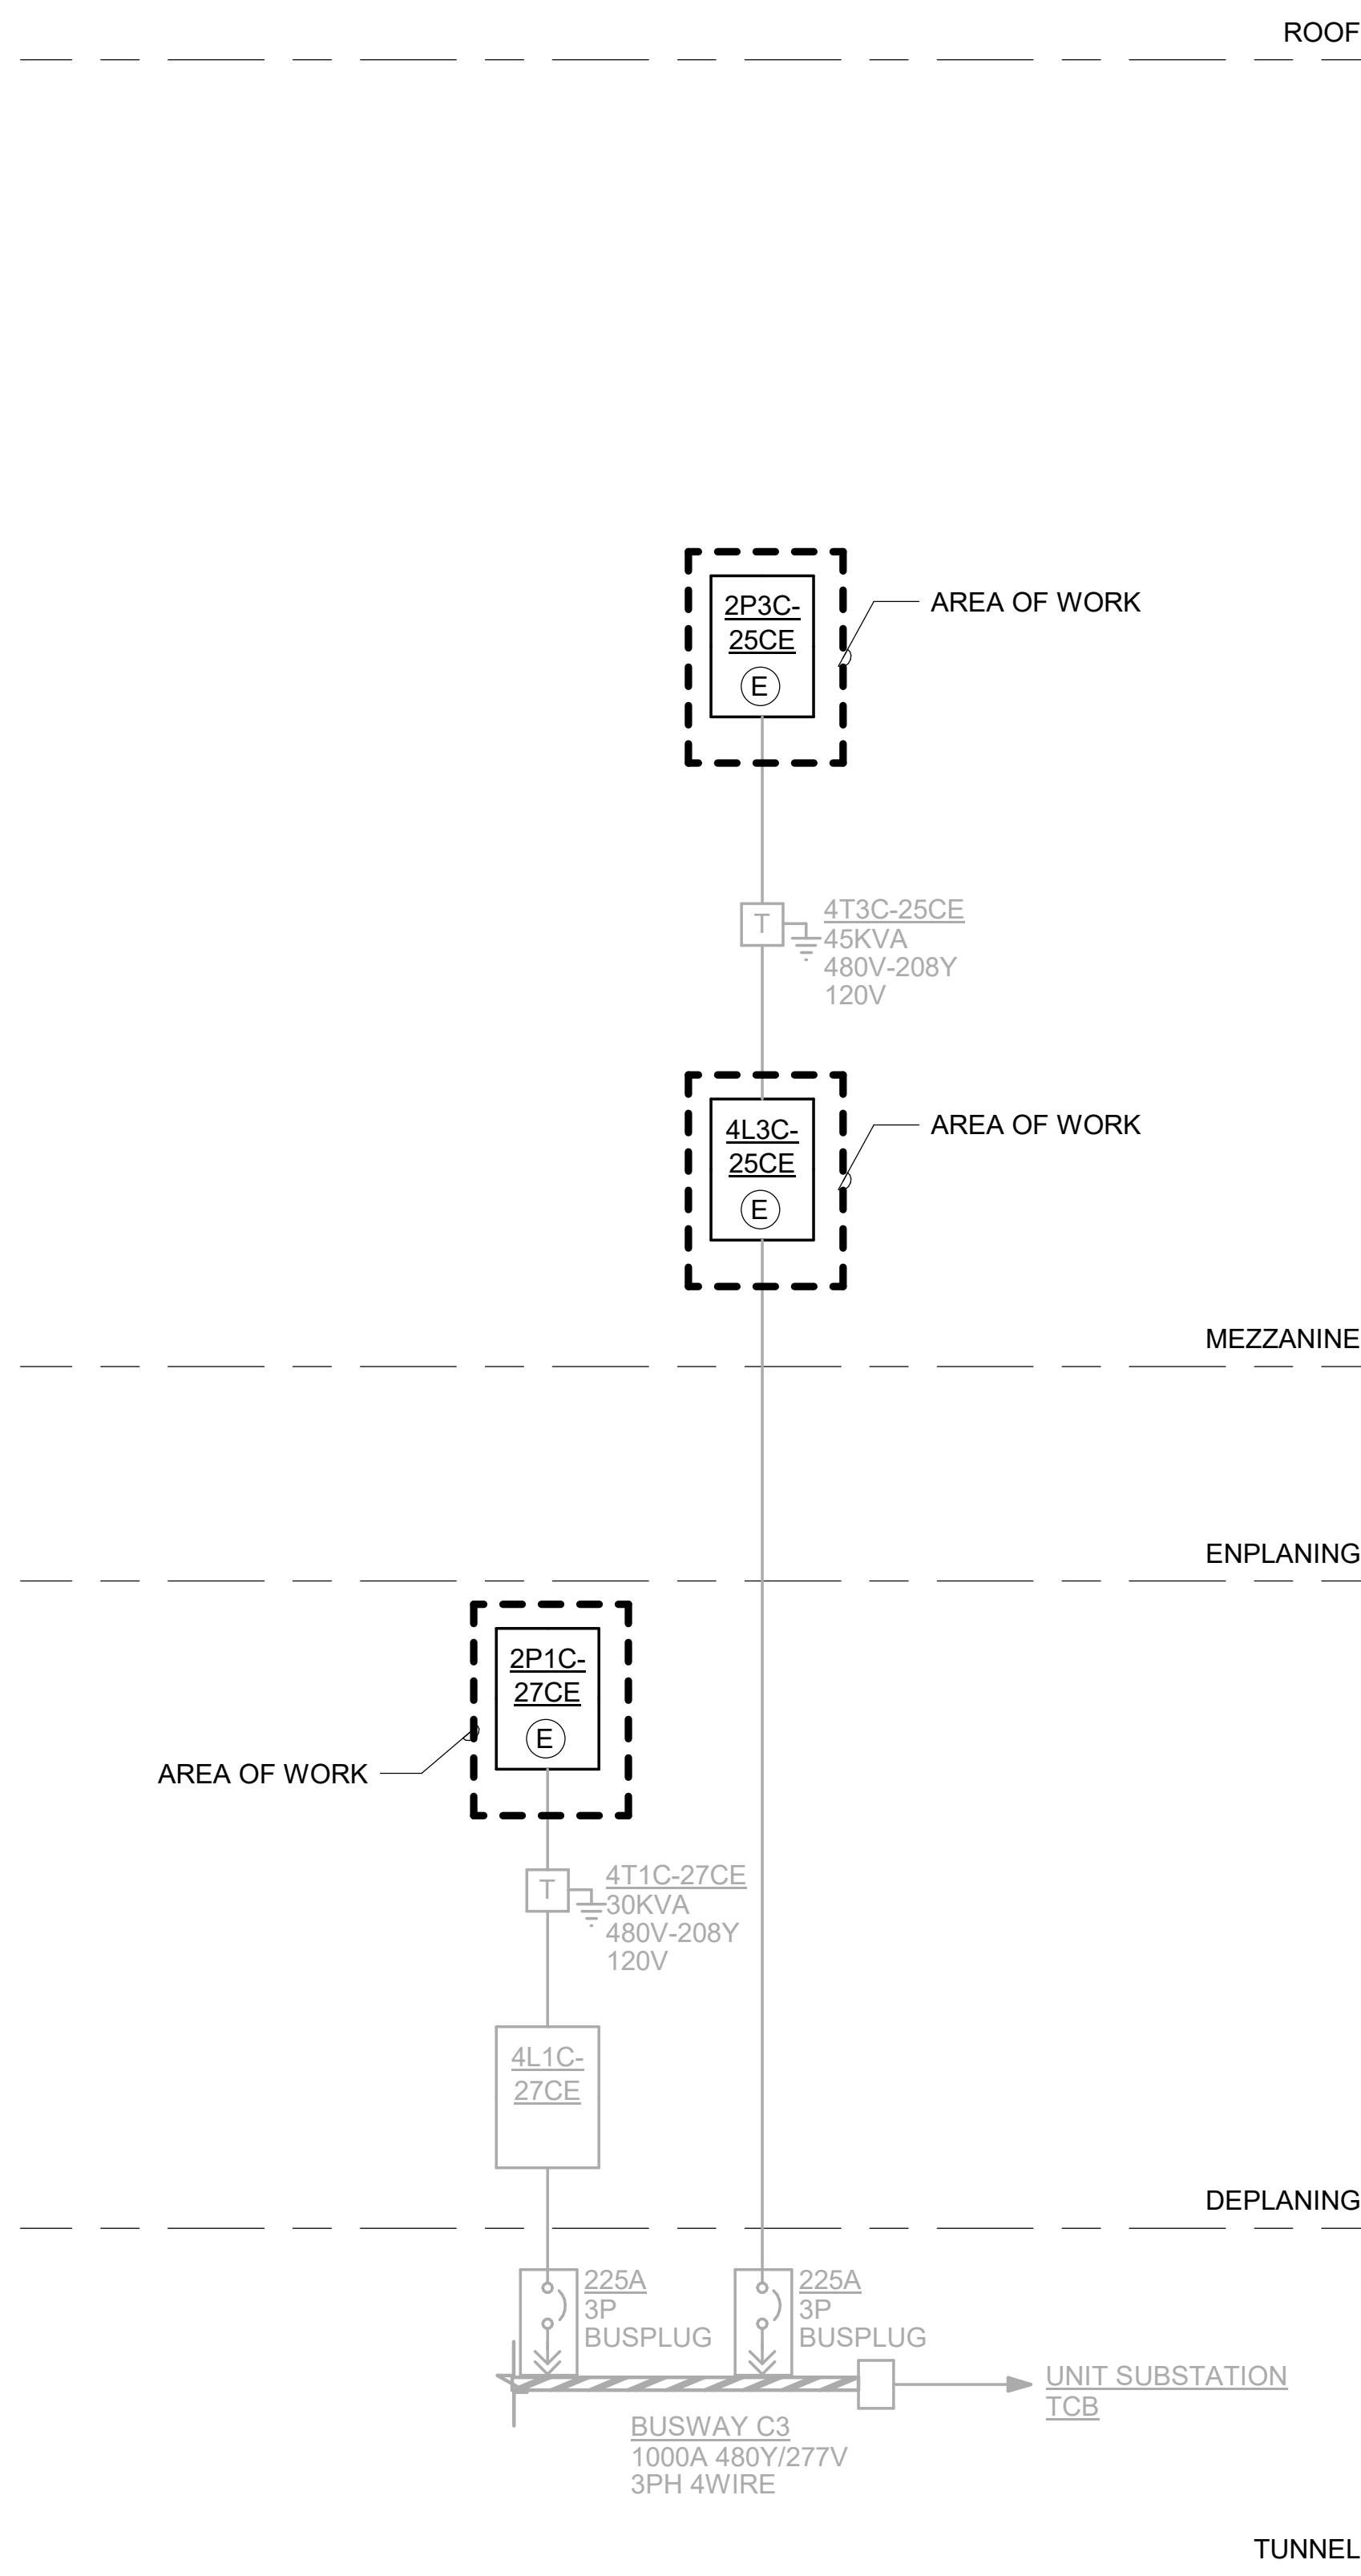

3 PARTIAL ONE LINE DIAGRAM - BUSDUCT C3
SCALE: NONE


NO.	DATE	BY	REVISIONS
1		B	
2		A	

Port of Portland

dbc architecture
2505 se 11th ave #325
portland, or 97202

PAE
pae-engineers.com
503.504.1230
dbcarchitecture.com

151 SW 1st Avenue #300
Portland, OR 97204
503.226.2921
pae-engineers.com

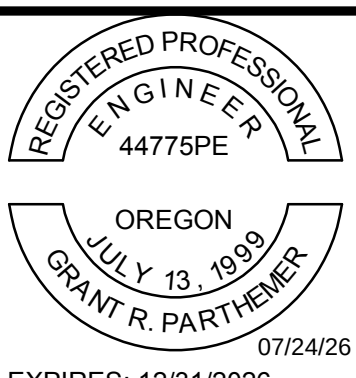

PORTLAND INTERNATIONAL AIRPORT		SUBMITTED BY	JAY OSTLUND
TERMINAL AND CONCOURSES WAYFINDING SIGNAGE		DESIGNED BY	D. PEEK
PARTIAL ONE LINES 3 - ELECTRICAL		DRAWN BY	P. MARKS
		CHECKED BY	G. PARTHEMER
		DATE	AUGUST 2026
		SHEET NO.	80
		TYPE	CD
		DRAWING NO.	PDX 2026-512
		ISS. BYT. NO.	E8.003

IF ELECTRONIC SIGNATURE IS BROKEN OR MISSING - THIS IS NOT A LEGAL DRAWING

DRAWING SCALE IS REDUCED 50% WHEN SHEET SIZE IS 17" x 22".