
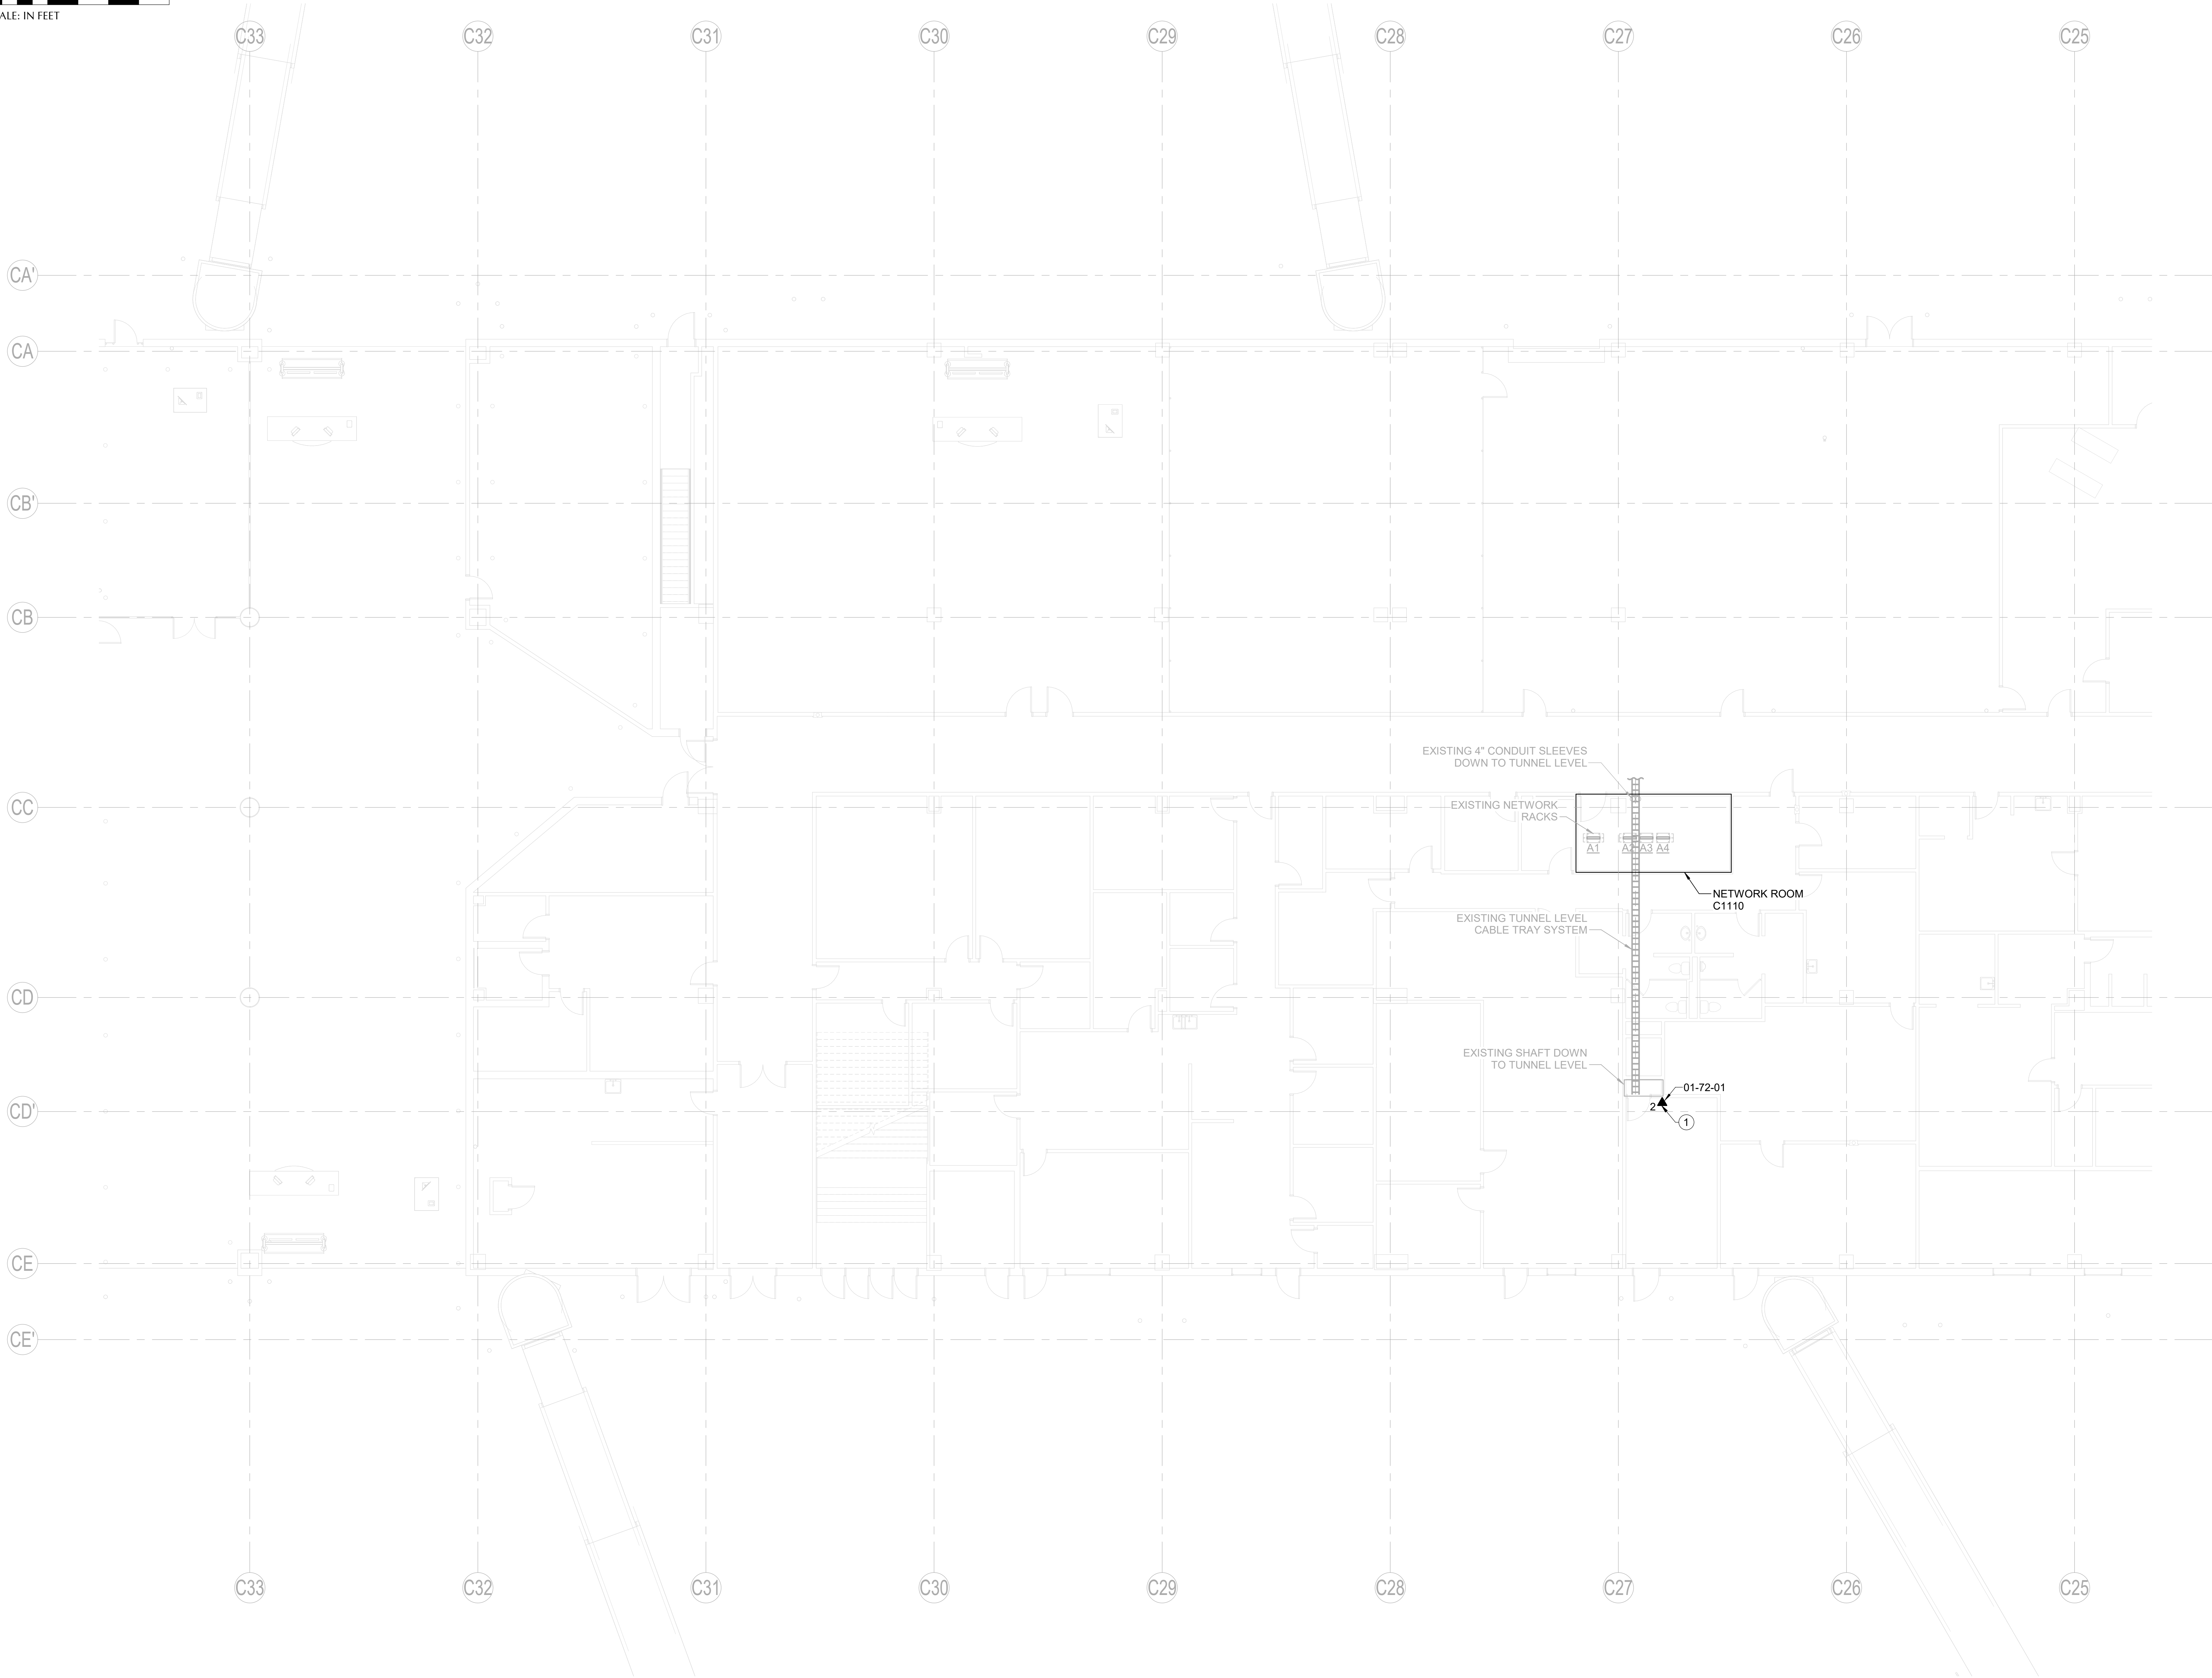


CAN YOU SEE THE AIRPLANES? THE ADJACENT SAMPLES SHOW THREE DIFFERENT LEVELS OF SHADING SETTINGS FOR VIEWING AND PRINTING CONTENT ARE OPTIMIZED WHEN ALL THREE PLANES ARE VISIBLE. THIS GUIDANCE IS PROVIDED FOR REFERENCE ONLY.

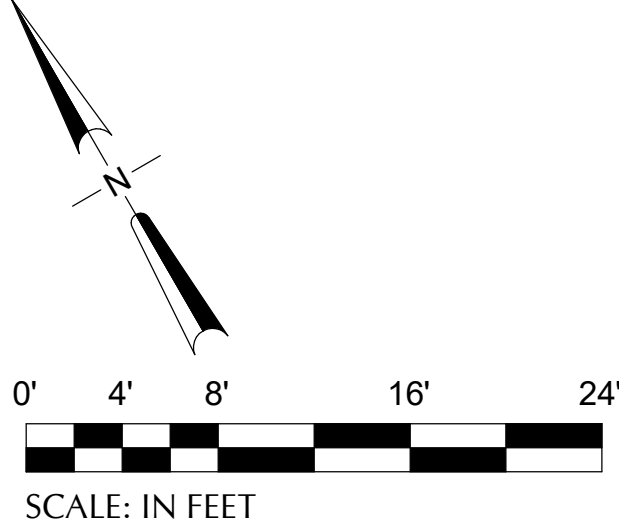

KEYNOTES

- ① DATA OUTLET FOR LIGHTING CONTROL PANEL. MOUNT OUTLET ADJACENT TO LIGHTING CONTROL PANEL AND PROVIDE CAT6A PATCH CABLE BETWEEN OUTLET AND PANEL. PROVIDE (1) 1\"/>

1 CONCURSE C - DEPLANING - SECTOR 72 - FLOOR PLAN - TECHNOLOGY
SCALE: 1/8\"/>


NO.	DATE	BY	REVISIONS

dbc architecture
2505 se 11th ave #326
portland, or 97202
503.504.1230
dbcarchitecture.com

PAE
pae-engineers.com
151 SW 1st Avenue #300
Portland, OR 97204
503.226.2921
pae-engineers.com


20260004
S&L

103101
P&L

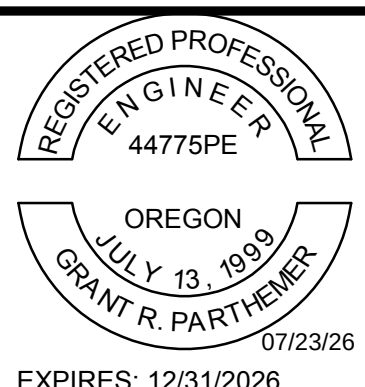

PORTLAND INTERNATIONAL AIRPORT	
TERMINAL AND CONCOURSES WAYFINDING SIGNAGE	
CONCURSE C - DEPLANING - SECTOR 72 - FLOOR PLAN - TECHNOLOGY	
DRAWING NO.	DISC. SHT. NO.
PDX 2026-512	T2.172

KEY PLAN
SCALE: N.T.S.

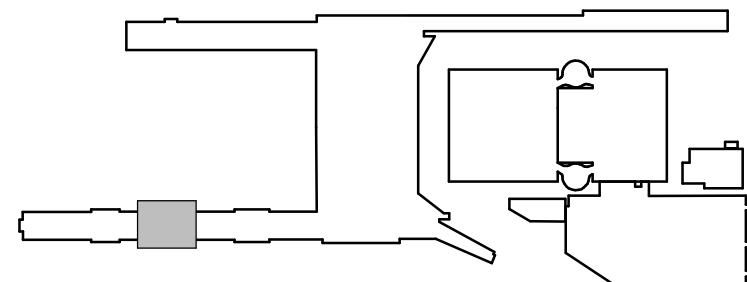

DRAWING SCALE IS REDUCED 50% WHEN SHEET SIZE IS 11\"/>